



CONSTRUCTION OF NEW MUNICIPAL SOFTBALL PARK REBID

PROJECT NO.: 08-18-C28-608

BID OPENING DATE: AUGUST 6, 2018 at 4:00 PM

A D D E N D U M NO. 1

Prospective bidders are advised that for purposes of this project, all original bid requirements and Addendum No. 1 requirements as expressed herein shall be considered part of the bid package. As such, bidders are advised to recognize and comply with all aspects of this bid.

Please see attached items as noted by project engineer

CONTRACTOR IS TO ACKNOWLEDGE ALL ADDENDUMS ON ORIGINAL BID PROPOSAL FORM

Signature, Acknowledge Add. #1

Date

Company Name (Print/Type Name)

A handwritten signature in blue ink, appearing to read "Gerardo Noriega", is written over a horizontal line.

Gerardo Noriega, CTPM
Director of Purchasing & Contracting

July 27, 2018

Date

/

All Addenda issued in respect to this project shall be considered official changes to the original bidding documents. It shall be the Respondent(s) responsibility to ensure that all Addenda have been received. Furthermore, respondents are advised that they must recognize, comply with, and recognize all Addendums on bid proposal form. Respondent(s) signature on bid form shall be interpreted as the bidder's "recognition and compliance to" official changes as outlined by the City of McAllen and as such are made part of the original solicitation/bidding documents.



JULY 26, 2018
AVO 33348

ADDENDUM No 1
SOFTBALL FIELD FACILITIES
MUNICIPAL PARK
McALLEN, TEXAS

This Addendum shall be considered part of the Construction Documents and is issued to change, amplify, add to, delete from, or otherwise explain the plans and specifications. Where provisions of this Addendum differ from those of the original Construction Documents, this Addendum shall take precedence over the original plans and specifications and shall govern.

Addendum Acknowledgement signature block below. This form is to be signed and included in Bid Package.

QUESTIONS

1. Question:
Will the new bleachers be taken out of this rebid? I do not see drawing L4.08 any longer in the documents. Will the bleachers being used just be the relocated ones? I do see the specifications (133125)
Answer:
New bleachers at new Field 5 and Field 6 have been removed from the project. The two existing bleachers from the old Field 1 (proposed playground area) are to be relocated to the new Field 4.
2. Question:
What is the budget of the project?
Answer:
The project budget is \$3 Million.
3. Question:
Is the contractor responsible for construction staking or will the city provide it?
Answer:
It is the contractor's responsibility to provide construction staking services.
4. Question:
When will construction begin?
Answer:
Groundbreaking will occur mid-October 2018, exact date will be determined at a later time.
5. Question:
When is last day for questions?
Answer:
The last day for submitting questions will be Tuesday, July 31, 2018.

GENERAL

1. Added “Delta 1” symbols and clouds to identify all modifications made on plan sheets and specification index.
2. Added Alternate #5 (Add & Deduct) – Net Backstops

FRONT ENDS

1. Working days for this project has been changed to 148 days (7 months – excludes weekends and public holidays).
2. Bid Schedule has been updated to include notes and Alternate Bid Item #5 Net Backstops.
3. Added Laboratory Service Report by Terracon Report No. 88181117.0001 for topsoil analysis with fertilizer recommendations.

BID SCHEDULE

1. Added Alternate #5 (Add & Deduct) – Net Backstops
2. Added the following notes to bid schedule.
“Notes:
 1. Refer to Geotechnical Report by Terracon Project No. 88175150 for all preparation requirements.
 2. All items are to be priced to be complete in place and fully functionally with all associated labor included.
 3. All mobilization, expected fees and permits are to be priced under each lump sum item.
 4. All items on plans and specifications shall be priced within this bid form.
 5. All alternates are to be filled out in order to be considered.
 6. If dewatering is required for installation of underground improvements. All operations and maintenance needed for removal of groundwater to properly install new improvements shall be subsidiary to the improvement being installed, no separate pay item.”
3. Added “Number of Working Days to Complete Contract (not to exceed 148 working days)”

CLARIFICATIONS

1. As part of base bid, existing scoreboards on Field #1, Field #2 and Field #3 are to be removed by contractor. New scoreboards to be furnished and installed by contractor. Refer to Detail 1, Sheet L4.05.
2. As part of base bid, existing scorekeeper’s table on Field #1, Field #2 and Field #3 are to be removed by contractor. New scorekeeper’s table and overhead to be furnished and installed by contractor. Refer to Detail 2, Sheet L4.06.
3. Roof canopy of existing dugouts on Field #1, Field #2 and Field #3 are to be reused on new dugouts of same fields.

PLAN SHEETS**Civil**

- C0.02 Added Dewatering Note.
If dewatering is required for installation of underground improvements. All operations and maintenance needed for removal of groundwater to properly install new improvements shall be subsidiary to the improvement being installed, no separate pay item.
- C0.04 Existing Field 3's scoreboard is to be removed by contractor and relocated. Include within base bid.
- C1.02 Flatwork leading to the playground and basketball court (Alternate) has been modified. Refer to Landscape plans for further dimension control.
- C2.02 Modified elevation for the playground and basketball court flatwork (Alternate) to reflect site plan changes.
- C3.02 Modified references files to reflect site plan flatwork changes.
Added Alternate 5 – Backstops Trench drains and underground system.
- C4.02 Modified references files to reflect site plan flatwork changes.
- C6.00 Modified references files to reflect site plan flatwork changes.

Architecture

- A2.1 Added outline of Cupola wall above. Added RCP key note #7 & revised key note #8.
- A2.2 Relocated ADA urinal, added ADA notes & dimensions.
- A2.3 Relocated ADA urinal, added ADA notes & dimensions.
- A3.1 Added Cupola & material call outs.
- A4.1 Added wall section at Cupola. Added ADA notes & dimensions.
- A4.2 Added wall detail at Cupola.

Structural

- S3.0 Refer to the following structural ADD#1 NARRATIVE for a description of changes.
- S4.0 Refer to the following structural ADD#1 NARRATIVE for a description of changes.
- S5.0 Refer to the following structural ADD#1 NARRATIVE for a description of changes.

Mechanical

- M1.01 Refer to the following mechanical ADDENDUM 1 NARRATIVE for a description of changes.
- M2.01 Refer to the following mechanical ADDENDUM 1 NARRATIVE for a description of changes.

Electrical

- E1.04 Refer to the following electrical ADDENDUM 1 NARRATIVE for a description of changes.
- E3.04 Refer to the following electrical ADDENDUM 1 NARRATIVE for a description of changes.

Plumbing

- P1.01 Refer to the following plumbing ADDENDUM 1 NARRATIVE for a description of changes.
- P1.02 Refer to the following plumbing ADDENDUM 1 NARRATIVE for a description of changes.

Landscape Architecture

- L2.02 Modified sidewalk and dimensions leading to playground area.
- L3.02 Modified sidewalk leading to playground area.
- L4.03 Added note to indicate Net Backstop as Alternate No. 5.
- L4.04 Added note to indicate Net Backstop as Alternate No. 5.
- L4.07 Revised Details 1 and 2 to indicate chain link fabric to be 9 gauge steel .
- L4.08 NEW SHEET. Added sheet to include details for net backstop.
- L4.09 NEW SHEET. Added sheet to include detail for net backstop.
- L5.00 Revised Overall Plant Schedule to indicate new Grass Hydromulch quantity due to sidewalk modification.
- L5.02 Modified sidewalk leading to playground area. Revised Plant Schedule to indicate new Grass Hydromulch quantity due to sidewalk modification.



Sub-bidders are hereby notified that this addendum shall be incorporated in their proposals, and it shall be construed that sub-bidders' proposals shall reflect with full knowledge, all items, changes and modifications to the Contract Documents herein specified.

NOTE: This form must be filled out completely (see section below) and submitted with your Bid Proposal.

WARNING: Failure of an Offeror to acknowledge receipt of this Addendum, as described herein, may result in REJECTION OF THE OFFER.

OFFEROR AUTHORIZED SIGNATURE

ACKNOWLEDGE RECEIPT OF ADDENDUM NO.1

OFFEROR PRINTED NAME

COMPANY NAME

Number of working days to complete contract _____ (not to exceed **148** working days).

The undersigned agrees, unless hereinafter stated otherwise to furnish all materials as shown and specified in the Plans and Specifications.

Bidder hereby agrees to commence work under this contract within 10 days after notice to PROCEED is issued and complete the work within ____ Working days, except City recognized holidays.

DATE: _____

Respectfully submitted,

BY: _____
(Signature)

(Type or Print Name)

(Title)

(Legal Company Name)

(Address)

(Phone Number)

(Seal - If bidder is a Corporation)

(Fax Number)

(E-Mail)

4. Cooperate with the Owner and separate contractors to accommodate this requirement.
- B. Work by Owner: The Owner will remove and retain possession of the following items prior to start of work under this Contract:
 1. Salvaged amenities and materials designated for removal by the demolition separate contract.
- C. Owner's Products: The Contractor shall remove and the Owner will take possession of the following items upon the start of work under this Contract:
 1. Salvaged amenities and materials designated for removal by the demolition separate contract...

1.4 OWNER OCCUPANCY

- A. The Owner intends to occupy the following portions of the project by the dates indicated:
 1. Within 148 working days of execution of construction agreement.

1.5 CONTRACTOR'S USE OF SITE AND PREMISES

- A. [Contractor shall have complete and exclusive use of site and premises for execution of the Work.
- B. Move any stored products under Contractor's control that interfere with the operations of the Owner.
- C. Assume full responsibility for protection and safekeeping of products under this Contract stored on site.
- D. Obtain and pay for use of any additional storage or work areas needed for operations.
- E. Coordinate use of site and premises with the Owner:
 1. Employee parking: parking lot along Quince.
 2. Access to site: from Quince
 3. Storage and staging areas: In designated areas that do not impede the surface drainage of the site or operations of swimming pool.
 4. Transport materials and equipment to and from construction area along routes approved by Owner.
- F. Conform to Building Rules and Regulations.
- G. Confine operations to construction area unless otherwise approved by Owner.

BID SCHEDULE
CITY OF McALLEN
SOFTBALL FIELD FACILITIES - MUNICIPAL PARK

Base Bid	Unit	Cost
Softball Fields Facilities Municipal Park Improvements	LS	\$
Site Irrigation	LS	\$
Total Base Bid		\$

Alternate #1 - Maintenance Building	LS	\$
Alternate #2 - Shade Structures	LS	\$
Alternate #3 - Basketball Court	LS	\$
Alternate #4 - Scoreboards	LS	\$
Alternate #5 - Net Backstop	LS	\$

Softball Field Facilities Municipal Park Improvements

Excludes: Alternates # 1- 4, Work Performed by Others/City and Site Irrigation

Work Performed by Others/City Include:

- Dismantle and Removal of Basketball Pavilion
- Court Striping on New Basketball Pavilion
- Demolition of Basketball Court Flatwork
- Dismantle and Relocation of Playground Structure
- Demolition of Playground Perimeter Sidewalk

Includes: Installation of Items Furnished by City

Installation of Items Furnished by City Include:

- Flag and Flag Poles

Park Improvements - Site Irrigation

Includes: Irrigation System of entire Park

Alternate #1 - Maintenance Building

Add:

- Driveway
- Dumpster Concrete Pad and Enclosure
- Storage Unit Concrete Pad
- Electrical Service Drop
- Adjacent Fence and Gates

Deduct:

- Irrigation from Driveway, Dumpster Pad and Storage Unit Pad

Alternate #2 - Shade Structures

Add:

- Furnish and Installation of Shade Structures for Fields # 5 and #6

Alternate #3 - Basketball Court

Add:

Concrete Flatwork excluding Pavilion Relocation
Adjacent Sidewalk extension from main path

Deduct:

Bermuda Grass Hydromulch from Concrete Pad and Sidewalk
Irrigation from Concrete Pad and Sidewalk

Alternate #4 - Scoreboards

Add:

Furnish and Installation of Scoreboards for Fields #1, #2 and #3

Alternate #5 - Net Backstop

Add:

Furnish and Installation of Net Backstop, Masonry Wall and Trench Drain for all 6 Fields.

Deduct:

Chain Link Backstop for Fields #4, #5 and #6.

Notes:

1. Refer to Geotechnical Report by Terracon Project No. 88175150 for all preparation requirements.
2. All items are to be priced to be complete in place and fully functionally with all associated labor included.
3. All mobilization, expected fees and permits are to be priced under each lump sum item.
4. All items on plans and specifications shall be priced within this bid form.
5. All alternates are to be filled out in order to be considered.
6. If dewatering is required for installation of underground improvements. All operations and maintenance needed for removal of groundwater to properly install new improvements shall be subsidiary to the improvement being installed, no separate pay item.

Number of Working Days to Complete Contract (not to exceed 148 working days)

LABORATORY SERVICES REPORT

Report Number: 88181117.0001
Service Date: 07/09/18
Report Date: 07/11/18 Revision 1 - Updated Topsoil Analysis

Terracon

1506 Mid Cities Dr
Pharr, TX 78577-2128
956-283-8254 Reg No: F-3272

Client

City of McAllen TX
Engineering Department
Attn: Mr. Eduardo Mendoza
311 N 15th St
McAllen, TX 78501-4705

Project

City of McAllen Softball Field Facilities Municipal Park
Bicentennial Boulevard and Quince Avenue
McAllen, TX

Project Number: 88181117

Mr. Juan M. Borjon representing Terracon Consultants, Inc. visited this site to retrieve twelve (12) topsoil samples. An updated report of the topsoil analysis is attached.


Services:

Terracon Rep.: Juan M. Borjon, P.E.
Reported To: Eduardo Mendoza with City of McAllen
Contractor:
Report Distribution:

(1) City of McAllen TX, Mr. Eduardo Mendoza

(1) City of McAllen TX, Mr. Zef Mendoza

Reviewed By:

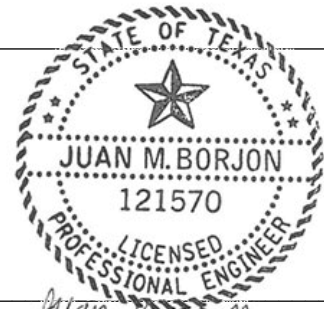

Juan M. Borjon
Juan M. Borjon, P.E.

Senior Staff Engineer

The tests were performed in general accordance with applicable ASTM, AASHTO, or DOT test methods. This report is exclusively for the use of the client indicated above and shall not be reproduced except in full without the written consent of our company. Test results transmitted herein are only applicable to the actual samples tested at the location(s) referenced and are not necessarily indicative of the properties of other apparently similar or identical materials.

SOIL ANALYSIS REPORT

CLIENT: 35420	PACE ANALYTICAL SERVICES INC 400 WEST BETHANY SUITE 190 ALLEN, TX 75013
-------------------------	---



6921 S. Bell
Amarillo, TX 79109
800.557.7509
806.677.0093
Fax 806.677.0329

LAB NO:	33295 - 33304
INVOICE NO:	150360
DATE RECEIVED:	07/04/2018
DATE REPORTED:	07/10/2018

SOIL ANALYSIS RESULTS FOR: MCALLEN SOFTBALL FIELD M PARK FIELD IDENTIFICATION: 88181117

METHOD USED:			1:1 Water-Soil		1:1 Water-Soil	XSL(I)	LOI(r)	Cd Reduction		c-Mehlich 3	Mehlich 3 ICP			Ammonium Acetate		Mehlich 3 ICP	DTPA				DTPA Sorbitol
Lab Number	Sample ID	Sample Depth	Soil pH	Buffer pH	Sol. Salts mmho/cm	Excess Lime	% Organic Matter	Nitrate-Nitrogen ppm lb. N/A		Phosphorus ppm P	Potassium ppm K	Sulfur ppm lb. S/A		Calcium ppm Ca	Magnesium ppm Mg	Sodium ppm Na	Zinc ppm Zn	Iron ppm Fe	Manganese ppm Mn	Copper ppm Cu	Boron ppm B
33295	1	0 - 8	7.6		0.37	Hi	3.2	4	10	54	512	32	77	3190	463	199	12.2	11	4	1.0	2.80
33296	2	0 - 8	8.0		0.19	Hi	2.9	5	12	67	394	15	36	2673	333	24	6.6	11	2	0.7	1.55
33297	3	0 - 8	7.7		0.27	Lo	3.3	7	17	116	473	19	46	2282	378	125	13.4	16	3	0.9	1.88
33298	4	0 - 8	8.0		0.22	Hi	3.0	4	10	51	561	17	41	3459	371	57	8.1	7	2	0.7	2.14
33299	5	0 - 8	8.0		0.24	Hi	1.4	8	19	28	492	21	50	3967	309	40	2.6	5	3	0.6	1.63
33300	6	0 - 8	7.4		0.19	No	2.6	6	14	66	841	13	31	2345	403	21	3.6	6	4	0.8	1.56
33301	7	0 - 8	7.9		0.20	Hi	2.9	3	7	41	644	11	26	3352	294	23	6.8	5	3	0.8	1.94
33302	8	0 - 8	8.1		0.21	Hi	1.2	3	7	17	449	12	29	4250	324	62	2.9	4	3	0.5	2.18
33303	9	0 - 8	8.1		0.16	Hi	1.2	2	5	21	453	10	24	3493	283	15	1.4	3	2	0.5	1.35
33304	10	0 - 8	7.9		0.18	Lo	1.5	4	10	32	415	9	22	2344	254	29	2.9	3	3	0.6	1.20

METHOD USED:			Hydrometer																	
Lab Number	Sample ID	Sample Depth	Soil Textural Classification	Sand %	Silt %	Clay %														
33295	1	0 - 8	Sandy Clay Loam	59.0	18.6	22.4														
33296	2	0 - 8	Sandy Loam	76.8	8.5	14.7														
33297	3	0 - 8	Sandy Loam	72.8	9.9	17.3														
33298	4	0 - 8	Sandy Loam	65.5	14.8	19.7														
33299	5	0 - 8	Sandy Clay Loam	63.9	12.5	23.6														
33300	6	0 - 8	Sandy Clay Loam	60.4	18.6	21.0														
33301	7	0 - 8	Sandy Loam	62.8	17.4	19.8														
33302	8	0 - 8	Sandy Clay Loam	55.1	18.7	26.2														
33303	9	0 - 8	Sandy Loam	68.8	16.2	15.0														
33304	10	0 - 8	Sandy Loam	70.0	13.8	16.2														

Analyses are representative of the samples submitted Samples are retained 30 days after report of analysis Explanations of soil analysis terms are available upon request

Reviewed and
Approved By: Kelly Brauer
Data Review Coordinator

Kelly Brauer

Page 1 of 2
07/10/2018 3:41 pm

SOIL ANALYSIS REPORT

CLIENT: 35420	PACE ANALYTICAL SERVICES INC 400 WEST BETHANY SUITE 190 ALLEN, TX 75013
-------------------------	---



6921 S. Bell
Amarillo, TX 79109
800.557.7509
806.677.0093
Fax 806.677.0329

LAB NO:	33295 - 33304
INVOICE NO:	150360
DATE RECEIVED:	07/04/2018
DATE REPORTED:	07/10/2018

SOIL ANALYSIS RESULTS FOR: MCALLEN SOFTBALL FIELD M PARK **FIELD IDENTIFICATION:** 88181117

FERTILIZER RECOMMENDATIONS:																	POUNDS ACTUAL NUTRIENT PER ACRE																
Lab Number	Sample ID	Crop To Be Grown	Yield Goal	Lime, ECC Tons/A to raise pH to:			N	P ₂ O ₅	K ₂ O	Zn	S	Mn	Cu	MgO	B	Ca	Cl																
				6.0	6.5	7.0																											
33295	1																																
33296	2																																
33297	3																																
33298	4																																
33299	5																																
33300	6																																
33301	7																																
33302	8																																
33303	9																																
33304	10																																

Cation Exchange Capacity										
CEC	%H	%K	%Ca	%Mg	%Na					
22	0	6	73	18	1					
17	0	6	77	16	1					
16	0	7	70	19	3					
22	0	7	78	14	1					
24	0	5	83	11	1					
17	0	12	68	19	1					
21	0	8	80	12	0					
25	0	5	84	11	1					
21	0	6	83	11	0					
15	0	7	78	14	1					

SPECIAL COMMENTS AND SUGGESTIONS:
Lab Number(s): 33295, 33296, 33297, 33298, 33299, 33300, 33301, 33302, 33303, 33304 Servi-Tech Laboratory fertilizer recommendations were not requested.

SOIL ANALYSIS REPORT

CLIENT: 35420	PACE ANALYTICAL SERVICES INC 400 WEST BETHANY SUITE 190 ALLEN, TX 75013
-------------------------	---



6921 S. Bell
Amarillo, TX 79109
800.557.7509
806.677.0093
Fax 806.677.0329

LAB NO:	33305 - 33306
INVOICE NO:	150360
DATE RECEIVED:	07/04/2018
DATE REPORTED:	07/10/2018

SOIL ANALYSIS RESULTS FOR: MCALLEN SOFTBALL FIELD M PARK FIELD IDENTIFICATION: 88181117

METHOD USED:			1:1 Water-Soil		1:1 Water-Soil	XSL(I)	LOI(r)	Cd Reduction		c-Mehlich 3	Mehlich 3 ICP		Ammonium Acetate		Mehlich 3 ICP	DTPA				DTPA Sorbitol	
Lab Number	Sample ID	Sample Depth	Soil pH	Buffer pH	Sol. Salts mmho/cm	Excess Lime	% Organic Matter	Nitrate-Nitrogen ppm lb. N/A		Phosphorus ppm P	Potassium ppm K	Sulfur ppm lb. S/A		Calcium ppm Ca	Magnesium ppm Mg	Sodium ppm Na	Zinc ppm Zn	Iron ppm Fe	Manganese ppm Mn	Copper ppm Cu	Boron ppm B
33305	11	0 - 8	8.1		0.20	Hi	1.7	1	2	18	400	12	29	3477	335	84	14.8	4	2	0.7	1.77
33306	12	0 - 8	7.5		0.21	No	2.4	4	10	36	677	7	17	2096	406	74	3.5	10	4	0.9	1.70

METHOD USED:			Hydrometer																	
Lab Number	Sample ID	Sample Depth	Soil Textural Classification			Sand %	Silt %	Clay %												
33305	11	0 - 8	Sandy Loam			65.4	17.3	17.3												
33306	12	0 - 8	Sandy Clay Loam			54.8	18.3	26.9												

FERTILIZER RECOMMENDATIONS:														POUNDS ACTUAL NUTRIENT PER ACRE										Cation Exchange Capacity					
Lab Number	Sample ID	Crop To Be Grown	Yield Goal	Lime, ECC Tons/A to raise pH to:			N	P ₂ O ₅	K ₂ O	Zn	S	Mn	Cu	MgO	B	Ca	Cl	CEC	%H	%K	%Ca	%Mg	%N						
				6.0	6.5	7.0																							
33305	11																	22	0	5	81	13							
33306	12																	16	0	11	66	21							

SPECIAL COMMENTS AND SUGGESTIONS:																													
Lab Number(s): 33305, 33306																													
Servi-Tech Laboratory fertilizer recommendations were not requested.																													

Analyses are representative of the samples submitted Samples are retained 30 days after report of analysis Explanations of soil analysis terms are available upon request

Reviewed and
Approved By: Kelly Brauer
Data Review Coordinator

Kelly Brauer

Page 1 of 1
07/10/2018 3:41 pm

Lab SampleRange: 33195-33316

Amarillo: Soil Data Quality Control Report

FIA

Soil: Nitrate-Nitrogen (FIA)

Jul 5 2018 7:20AM 547493 Batch: A Instrument: AMA-LACHAT QuikChem 8500

Sample													Count	X1	XL	STD1	STDL	RSTD1	RSTD1	Acceptable Range	Outliers LT(%)		
	1	2	3	4	5	6	7	8	9	10	11	12									1	2	3
CCV	4.9	4.8	4.9	4.8									5,405	4.8		0.5		10.3		4.5 - 5.5			
MB	0.5	0.0											2,499	0.2		0.6				-0.5 - 0.5			
SHIP	<u>4.5</u>	<u>4.4</u>											3,022	2.8	2.7	1.7	0.7	60.2	24.2	1.4 - 4.1	3	1	0
TAN2	<u>8.9</u>	6.6	7.2										523	7.4	7.4	0.6	0.5	7.4	6.2	6.5 - 8.3	28	5	1
CLAW	18.6	18.9	19.2										2,809	19.8	19.7	2.1	1.5	10.6	7.7	16.7 - 22.7	19	3	1
KEY	2.9	3.3											419	2.9	2.8	0.4	0.3	14.1	12.1	2.2 - 3.5	28	4	0

LAB #	33235	33313
ORIGINAL	8.7	0.4
DUPLICATE	8.6	0.5
% RD	1.4	32.9

<u>Outliers</u>	<u>Blinds</u>	<u>All QCs</u>	<u>Acceptable</u>	<u>Reject</u>	Total Adjusted Outliers (>66.7%)	17/18 94.4%
1 SD		7/10 70.0%	(>=33.3%)			
2 SD		9/10 90.0%	(>=66.7%)	(<25%)	Agronomic Relevance	1
3 SD		10/10 100.0%	(100%)	(<75%)		

Order of Analysis: TAN2-1, CLAW-1, KEY-1, CCV-1, MB-1, 33195-33222, SHIP-1, 33223-33254, TAN2-2, CCV-2, 33255-33285, CLAW-2, 33286-33316, >33235, KEY-2, CCV-3, >33313, MB-2, SHIP-2, TAN2-3, CLAW-3, CCV-4

Missing Samples:

<u>Approved</u>	<u>Date / Tme</u>	<u>Name</u>	<u>Type</u>	<u>Comment</u>
Y	07/05/2018 3:54 pm	StevenH	Signer	
Y	07/05/2018 12:49 pm	AmyW	Analyst	

[X] ACCEPTABLE: May release all data upon final review of individual results.

[] CAUTION: May release some or all data upon intense scrutiny of individual results.

[] REJECTION: Hold all data and re-analyse part or all data.

Lab SampleRange: 33195-33316

Amarillo: Soil Data Quality Control Report

FIA

Soil: Nitrate-Nitrogen (FIA)

Jul 5 2018 7:20AM 547493 Batch: A Instrument: AMA-LACHAT QuikChem 8500

Sample													Count	X1	XL	STD1	STD1	RSTD1	RSTD1	Acceptable Range	Outliers LT(%)		
	1	2	3	4	5	6	7	8	9	10	11	12									1	2	3
CCV	4.9	4.8	4.9	4.8									5,405	4.8		0.5		10.3		4.5 - 5.5			
MB	0.5	0.0											2,499	0.2		0.6				-0.5 - 0.5			
SHIP	<u>4.5</u>	<u>4.4</u>											3,022	2.8	2.7	1.7	0.7	60.2	24.2	1.4 - 4.1	3	1	0
TAN2	<u>8.9</u>	6.6	7.2										523	7.4	7.4	0.6	0.5	7.4	6.2	6.5 - 8.3	28	5	1
CLAW	18.6	18.9	19.2										2,809	19.8	19.7	2.1	1.5	10.6	7.7	16.7 - 22.7	19	3	1
KEY	2.9	3.3											419	2.9	2.8	0.4	0.3	14.1	12.1	2.2 - 3.5	28	4	0

LAB #	33235	33313
ORIGINAL	8.7	0.4
DUPLICATE	8.6	0.5
% RD	1.4	32.9

<u>Outliers</u>	<u>Blinds</u>	<u>All QCs</u>	<u>Acceptable</u>	<u>Reject</u>	Total Adjusted Outliers (>66.7%)	17/18 94.4%
1 SD		7/10 70.0%	(>=33.3%)			
2 SD		9/10 90.0%	(>=66.7%)	(<25%)	Agronomic Relevance	1
3 SD		10/10 100.0%	(100%)	(<75%)		

Order of Analysis: TAN2-1, CLAW-1, KEY-1, CCV-1, MB-1, 33195-33222, SHIP-1, 33223-33254, TAN2-2, CCV-2, 33255-33285, CLAW-2, 33286-33316, >33235, KEY-2, CCV-3, >33313, MB-2, SHIP-2, TAN2-3, CLAW-3, CCV-4

Missing Samples:

<u>Approved</u>	<u>Date / Tme</u>	<u>Name</u>	<u>Type</u>	<u>Comment</u>
Y	07/05/2018 3:54 pm	StevenH	Signer	
Y	07/05/2018 12:49 pm	AmyW	Analyst	

[X] ACCEPTABLE: May release all data upon final review of individual results.

[] CAUTION: May release some or all data upon intense scrutiny of individual results.

[] REJECTION: Hold all data and re-analyse part or all data.

Lab SampleRange: 33202-33316

Amarillo: Soil Data Quality Control Report

Soil: Ammonium Acetate Exchangeable Calcium (ICP)

Jul 5 2018 7:27AM 547507 Batch: A Instrument: Agilent ICP 5100

Sample													Count	X1	XL	STD1	STDL	RSTD1	RSTD1	Acceptable Range	Outliers LT(%)		
	1	2	3	4	5	6	7	8	9	10	11	12									1	2	3
CCV	242	243	241										4,616	256		11		4.3		225 - 275			
MB	-2	<u>-11</u>											2,281	22		58				-5 - 50			
FRB	20	42											0							-			
TAN2	2,316	2,205	2,211										461	2,367	2,365	129	115	5.4	4.9	2,135 - 2,595	31	3	1
CLAW	4,871	4,806	4,800										2,040	4,962	4,967	220	173	4.4	3.5	4,621 - 5,312	23	3	1
KEY	5,500	5,550	5,595										392	5,736	5,723	183	160	3.2	2.8	5,403 - 6,043	29	3	1

LAB #	33231	33316
ORIGINAL	2162	439
DUPLICATE	2288	445
% RD	5.6	1.5

<u>Outliers</u>	<u>Blinds</u>	<u>All QCs</u>	<u>Acceptable</u>	<u>Reject</u>	Total Adjusted Outliers (>66.7%)	17/18 94.4%
1 SD		5/9 55.6%	(>=33.3%)			
2 SD		9/9 100.0%	(>=66.7%)	(<25%)	Agronomic Relevance	25
3 SD		9/9 100.0%	(100%)	(<75%)		

Order of Analysis:

Missing Samples: NONE

<u>Approved</u>	<u>Date / Tme</u>	<u>Name</u>	<u>Type</u>	<u>Comment</u>
Y	07/05/2018 3:52 pm	StevenH	Signer	
Y	07/05/2018 11:44 am	CaseyJ	Analyst	

[X] ACCEPTABLE: May release all data upon final review of individual results.

[] CAUTION: May release some or all data upon intense scrutiny of individual results.

[] REJECTION: Hold all data and re-analyse part or all data.

Lab SampleRange: 33202-33316

Amarillo: Soil Data Quality Control Report

Soil: Ammonium Acetate Exchangeable Magnesium (ICP)

Jul 5 2018 7:27AM 547507 Batch: A Instrument: Agilent ICP 5100

Sample													Count	X1	XL	STD1	STDL	RSTD1	RSTD1	Acceptable Range	Outliers LT(%)		
	1	2	3	4	5	6	7	8	9	10	11	12									1	2	3
CCV	48.2	48.0	48.1										4,616	49.6		1.7		3.5		45.0 - 55.0			
MB	-1.2	-2.6											2,290	4.7		11.5				-2.0 - 15.0			
FRB	4.0	8.4											0							-			
TAN2	289.0	279.1	281.0										461	303.1	302.5	16.4	14.3	5.4	4.7	273.9 - 331.1	33	3	1
CLAW	365.4	356.2	357.9										2,043	373.2	372.5	17.7	15.3	4.7	4.1	341.9 - 403.2	29	3	0
KEY	230.7	235.6	237.4										392	246.9	246.2	8.5	7.5	3.4	3.0	231.2 - 261.2	33	5	0

LAB #	33231	33316
ORIGINAL	159.1	84.4
DUPLICATE	168.2	85.8
% RD	5.5	1.6

<u>Outliers</u>	<u>Blinds</u>	<u>All QCs</u>	<u>Acceptable</u>	<u>Reject</u>	Total Adjusted Outliers (>66.7%)	16/18 88.9%
1 SD		3/9 33.3%	(>=33.3%)			
2 SD		8/9 88.9%	(>=66.7%)	(<25%)	Agronomic Relevance	10
3 SD		9/9 100.0%	(100%)	(<75%)		

Order of Analysis:

Missing Samples: NONE

<u>Approved</u>	<u>Date / Tme</u>	<u>Name</u>	<u>Type</u>	<u>Comment</u>
Y	07/05/2018 3:52 pm	StevenH	Signer	
Y	07/05/2018 11:44 am	CaseyJ	Analyst	

[X] ACCEPTABLE: May release all data upon final review of individual results.

[] CAUTION: May release some or all data upon intense scrutiny of individual results.

[] REJECTION: Hold all data and re-analyse part or all data.

Lab SampleRange: 33199-33316

Amarillo: Soil Data Quality Control Report

ICP

Soil: DTPA Extractable Iron (ICP)

Jul 5 2018 7:27AM 547508 Batch: A Instrument: Agilent ICP 5100

Sample	1	2	3	4	5	6	7	8	9	10	11	12	Count	X1	XL	STD1	STD1	RSTD1	RSTD1	Acceptable Range	Outliers LT(%)		
																					1	2	3
CCV	19.6	19.7											4,125	19.7		0.9		4.4		18.0 - 22.0			
MB	0.1	0.0											2,286	0.3		0.4				-0.5 - 0.5			
TAN2	77.1	77.2	86.3										469	73.4	72.8	7.0	5.6	9.5	7.7	61.6 - 84.0	26	4	2
CLAW	7.0	6.5											2,029	7.3	7.2	2.0	0.8	27.3	11.0	5.6 - 8.8	3	1	1
KEY	3.9	3.9											385	4.2	4.1	0.5	0.4	12.4	9.3	3.3 - 4.9	22	5	1
LAB #	33304																						
ORIGINAL	3.2																						
DUPLICATE	3.5																						
% RD	10.8																						

Outliers	Blinds	All QCs	Acceptable	Reject	Total Adjusted Outliers (>66.7%)	11/12	91.7%
1 SD		6/7 85.7%	(>=33.3%)				
2 SD		7/7 100.0%	(>=66.7%)	(<25%)			
3 SD		7/7 100.0%	(100%)	(<75%)			

Order of Analysis: TAN2-1, CLAW-1, KEY-1, CCV-1, MB-1, 33199, 33201-33206, 33265, 33267, 33269, 33271, 33273, 33275, 33277, 33279, 33281, 33283, 33285, 33287, 33289, 33291, 33293, 33295-33300, TAN2-2, 33301-33310, 33314-33316, >33304, MB-2, CLAW-2, KEY-2, TAN2-3, CCV-2

Missing Samples:

Approved	Date / Time	Name	Type	Comment
Y	07/05/2018 3:53 pm	StevenH	Signer	
Y	07/05/2018 1:19 pm	AshleighR	Analyst	

[] ACCEPTABLE: May release all data upon final review of individual results.

[X] CAUTION: May release some or all data upon intense scrutiny of individual results.

[] REJECTION: Hold all data and re-analyse part or all data.

Lab SampleRange: 33199-33316

Amarillo: Soil Data Quality Control Report

Soil: DTPA Extractable Manganese (ICP)

Jul 5 2018 7:27AM 547508 Batch: A Instrument: Agilent ICP 5100

Sample													Count	X1	XL	STD1	STD1	RSTD1	RSTD1	Acceptable Range	Outliers LT(%)		
	1	2	3	4	5	6	7	8	9	10	11	12									1	2	3
CCV	9.9	10.1											4,125	10.0		0.5		4.9		9.0 - 11.0			
MB	0.1	0.0											2,286	0.1		0.2				-0.5 - 0.5			
TAN2	95.6	93.9	88.3										469	97.7	97.3	7.1	6.2	7.2	6.3	85.0 - 109.7	32	4	0
CLAW	14.5	13.4											2,029	15.8	15.7	1.7	1.4	10.9	8.9	12.9 - 18.5	26	3	1
KEY	6.0	6.2											387	5.6	5.5	0.7	0.5	11.7	9.2	4.5 - 6.5	23	4	2
LAB #	33304																						
ORIGINAL	2.6																						
DUPLICATE	2.7																						
% RD	0.3																						

<u>Outliers</u>	<u>Blinds</u>	<u>All QCs</u>	<u>Acceptable</u>	<u>Reject</u>	<u>Total Adjusted Outliers (>66.7%)</u>	12/12 100.0%
1 SD		4/7 57.1%	(>=33.3%)			
2 SD		7/7 100.0%	(>=66.7%)	(<25%)		
3 SD		7/7 100.0%	(100%)	(<75%)		

Order of Analysis:

Missing Samples: NONE

<u>Approved</u>	<u>Date / Tme</u>	<u>Name</u>	<u>Type</u>	<u>Comment</u>
Y	07/05/2018 3:53 pm	StevenH	Signer	
Y	07/05/2018 1:19 pm	AshleighR	Analyst	

[X] ACCEPTABLE: May release all data upon final review of individual results.

[] CAUTION: May release some or all data upon intense scrutiny of individual results.

[] REJECTION: Hold all data and re-analyse part or all data.

Lab SampleRange: 33199-33316

Amarillo: Soil Data Quality Control Report

Soil: DTPA Extractable Copper (ICP)

Jul 5 2018 7:27AM 547508 Batch: A Instrument: Agilent ICP 5100

Sample	1	2	3	4	5	6	7	8	9	10	11	12	Count	X1	XL	STD1	STD1	RSTD1	RSTD1	Acceptable Range	Outliers LT(%)		
																					1	2	3
CCV	0.50	0.50											4,125	0.49		0.04		8.8		0.45 - 0.55			
MB	0.02	0.01											2,286	0.01		0.01		86.7		-0.10 - 0.10			
TAN2	0.79	0.76	0.73										469	0.76	0.76	0.08	0.05	10.1	6.8	0.66 - 0.86	17	1	0
CLAW	1.36	1.27											2,029	1.26	1.26	0.09	0.07	7.1	5.7	1.12 - 1.41	26	3	1
KEY	0.64	0.63											387	0.61	0.61	0.04	0.03	6.5	5.3	0.55 - 0.68	26	5	1
LAB #	33304																						
ORIGINAL	0.56																						
DUPLICATE	0.51																						
% RD	9.4																						

<u>Outliers</u>	<u>Blinds</u>	<u>All QCs</u>	<u>Acceptable</u>	<u>Reject</u>	<u>Total Adjusted Outliers (>66.7%)</u>	12/12 100.0%
1 SD		6/7 85.7%	(>=33.3%)			
2 SD		7/7 100.0%	(>=66.7%)	(<25%)		
3 SD		7/7 100.0%	(100%)	(<75%)		

Order of Analysis:

Missing Samples: NONE

<u>Approved</u>	<u>Date / Tme</u>	<u>Name</u>	<u>Type</u>	<u>Comment</u>
Y	07/05/2018 3:53 pm	StevenH	Signer	
Y	07/05/2018 1:19 pm	AshleighR	Analyst	

[X] ACCEPTABLE: May release all data upon final review of individual results.

[] CAUTION: May release some or all data upon intense scrutiny of individual results.

[] REJECTION: Hold all data and re-analyse part or all data.

Lab SampleRange: 33199-33316

Amarillo: Soil Data Quality Control Report

Soil: DTPA Extractable Zinc (ICP)

Jul 5 2018 7:27AM 547508 Batch: A Instrument: Agilent ICP 5100

Sample	1	2	3	4	5	6	7	8	9	10	11	12	Count	X1	XL	STD1	STD1	RSTD1	RSTD1	Acceptable Range	Outliers LT(%)		
																					1	2	3
CCV	0.98	0.99											4,164	0.98		0.09		8.8		0.90 - 1.10			
MB	0.03	0.05											2,286	0.04		0.29				-0.10 - 0.10			
TAN2	5.73	5.57	5.32										469	5.58	5.54	0.51	0.31	9.1	5.6	4.93 - 6.16	12	2	1
CLAW	1.47	1.37											2,029	1.44	1.44	0.22	0.09	15.1	6.3	1.26 - 1.62	3	1	0
KEY	0.49	0.48											387	0.50	0.46	0.48	0.05	96.7	10.0	0.37 - 0.56	1	1	1
LAB #	33304																						
ORIGINAL	2.86																						
DUPLICATE	2.63																						
% RD	8.5																						

<u>Outliers</u>	<u>Blinds</u>	<u>All QCs</u>	<u>Acceptable</u>	<u>Reject</u>	<u>Total Adjusted Outliers (>66.7%)</u>	12/12 100.0%
1 SD		7/7 100.0%	(>=33.3%)			
2 SD		7/7 100.0%	(>=66.7%)	(<25%)		
3 SD		7/7 100.0%	(100%)	(<75%)		

Order of Analysis:

Missing Samples: NONE

<u>Approved</u>	<u>Date / Tme</u>	<u>Name</u>	<u>Type</u>	<u>Comment</u>
Y	07/05/2018 3:53 pm	StevenH	Signer	
Y	07/05/2018 1:19 pm	AshleighR	Analyst	

[X] ACCEPTABLE: May release all data upon final review of individual results.

[] CAUTION: May release some or all data upon intense scrutiny of individual results.

[] REJECTION: Hold all data and re-analyse part or all data.

Lab SampleRange: 33199-33316

Amarillo: Soil Data Quality Control Report

Soil: DTPA-Sorbitol Boron

Jul 5 2018 7:27AM 547508 Batch: A Instrument: Agilent ICP 5100

Sample	1	2	3	4	5	6	7	8	9	10	11	12	Count	X1	XL	STD1	STD1	RSTD1	RSTD1	Acceptable Range	Outliers LT(%)		
																					1	2	3
CCV	0.49	0.50											544	0.50		0.02		4.9		0.45 - 0.55			
MB	0.02	0.02											372	0.01		0.02				-0.10 - 0.10			
TAN2	<u>0.29</u>	0.25	0.26										469	0.23	0.23	0.06	0.02	24.8	9.3	0.18 - 0.27	3	0	0
CLAW	1.31	1.22											476	1.32	1.32	0.07	0.06	5.1	4.2	1.21 - 1.43	30	5	1
KEY	0.87	0.84											387	0.86	0.86	0.05	0.04	5.5	4.2	0.79 - 0.94	22	5	2
LAB #	33304																						
ORIGINAL	1.20																						
DUPLICATE	1.11																						
% RD	7.8																						

<u>Outliers</u>	<u>Blinds</u>	<u>All QCs</u>	<u>Acceptable</u>	<u>Reject</u>	<u>Total Adjusted Outliers (>66.7%)</u>	11/12	91.7%
1 SD		3/7 42.9%	(>=33.3%)				
2 SD		6/7 85.7%	(>=66.7%)	(<25%)			
3 SD		7/7 100.0%	(100%)	(<75%)			

Order of Analysis:

Missing Samples: NONE

<u>Approved</u>	<u>Date / Tme</u>	<u>Name</u>	<u>Type</u>	<u>Comment</u>
Y	07/05/2018 3:53 pm	StevenH	Signer	
Y	07/05/2018 1:19 pm	AshleighR	Analyst	

[X] ACCEPTABLE: May release all data upon final review of individual results.

[] CAUTION: May release some or all data upon intense scrutiny of individual results.

[] REJECTION: Hold all data and re-analyse part or all data.

Lab SampleRange: 33199-33316

Amarillo: Soil Data Quality Control Report

ICP

Soil: Mehlich 3 Extractable Phosphorus (ICP)

Jul 5 2018 7:27AM 547509 Batch: A Instrument: Agilent ICP 5100

Sample													Count	X1	XL	STD1	STDL	RSTD1	RSTD1	Acceptable Range	Outliers LT(%)		
	1	2	3	4	5	6	7	8	9	10	11	12									1	2	3
CCV	20.7	20.7	20.6										3,250	19.7		0.9		4.3		18.0 - 22.0			
MB	0.0	0.2											2,024	0.7		2.8				-0.2 - 0.2			
FRB	1.3	0.7											0							-			
TAN2	80.4	84.4	78.7										2,046	77.7	77.8	4.2	3.3	5.4	4.3	71.2 - 84.4	23	2	1
CLAW	58.2	59.2	58.7										806	58.5	58.5	2.2	2.1	3.8	3.5	54.4 - 62.6	33	3	0
KEY	38.1	39.3	37.4										539	38.0	38.0	1.5	1.3	3.9	3.4	35.4 - 40.6	30	4	0

LAB #	33273	33313
ORIGINAL	112.3	8.7
DUPLICATE	113.4	9.0
% RD	1.0	3.7

Outliers	Blinds	All QCs	Acceptable	Reject	Total Adjusted Outliers (>66.7%)	18/18 100.0%
1 SD		8/9 88.9%	(>=33.3%)			
2 SD		9/9 100.0%	(>=66.7%)	(<25%)	Agronomic Relevance	2
3 SD		9/9 100.0%	(100%)	(<75%)		

Order of Analysis: FRB-1, FRB-2, KEY-1, TAN2-1, CLAW-1, CCV-1, MB-1, 33199-33224, KEY-2, 33225-33256, TAN2-2, CCV-2, 33257-33265, 33267, 33269, 33271, 33273, 33275, 33277, 33279, 33281, 33283, 33285, 33287, 33289, 33291, 33293, 33295-33302, CLAW-2, 33303-33316, >33273, >33313, MB-2, KEY-3, TAN2-3, CLAW-3, CCV-3

Missing Samples:

Approved	Date / Tme	Name	Type	Comment
Y	07/05/2018 3:53 pm	StevenH	Signer	
Y	07/05/2018 12:52 pm	CaseyJ	Analyst	

[X] ACCEPTABLE: May release all data upon final review of individual results.

[] CAUTION: May release some or all data upon intense scrutiny of individual results.

[] REJECTION: Hold all data and re-analyse part or all data.

Lab SampleRange: 33199-33316

Amarillo: Soil Data Quality Control Report

Soil: Mehlich 3 Extractable Potassium (ICP)

Jul 5 2018 7:27AM 547509 Batch: A Instrument: Agilent ICP 5100

Sample													Count	X1	XL	STD1	STD1	RSTD1	RSTD1	Acceptable Range	Outliers LT(%)		
	1	2	3	4	5	6	7	8	9	10	11	12									1	2	3
CCV	51	51	51										3,240	50		2		4.2		45 - 55			
MB	6	<u>11</u>											2,014	5		18				-1 - 10			
FRB	3	2											0							-			
TAN2	378	406	376										2,042	390	387	96	27	24.5	7.0	333 - 442	1	0	0
CLAW	423	417	406										687	421	421	21	17	5.0	4.1	386 - 455	25	5	0
KEY	352	353	371										539	346	344	21	16	6.1	4.5	313 - 375	22	1	1

LAB # 33273 33313
 ORIGINAL 376 224
 DUPLICATE 419 245
 % RD 10.6 8.8

<u>Outliers</u>	<u>Blinds</u>	<u>All QCs</u>	<u>Acceptable</u>	<u>Reject</u>	Total Adjusted Outliers (>66.7%)	16/18 88.9%
1 SD		8/9 88.9%	(>=33.3%)			
2 SD		9/9 100.0%	(>=66.7%)	(<25%)	Agronomic Relevance	10
3 SD		9/9 100.0%	(100%)	(<75%)		

Order of Analysis:

Missing Samples: NONE

<u>Approved</u>	<u>Date / Tme</u>	<u>Name</u>	<u>Type</u>	<u>Comment</u>
Y	07/05/2018 3:53 pm	StevenH	Signer	
Y	07/05/2018 12:52 pm	CaseyJ	Analyst	

[] ACCEPTABLE: May release all data upon final review of individual results.

[X] CAUTION: May release some or all data upon intense scrutiny of individual results.

[] REJECTION: Hold all data and re-analyse part or all data.

Lab SampleRange: 33199-33316

Amarillo: Soil Data Quality Control Report

Soil: Mehlich 3 Extractable Sodium (ICP)

Jul 5 2018 7:27AM 547509 Batch: A Instrument: Agilent ICP 5100

Sample													Count	X1	XL	STD1	STD1	RSTD1	RSTD1	Acceptable Range	Outliers LT(%)		
	1	2	3	4	5	6	7	8	9	10	11	12									1	2	3
CCV	20.5	20.4	20.4										3,228	20.0		0.9		4.5		18.0 - 22.0			
MB	<u>-4.3</u>	-0.8											2,004	1.0		3.7				-1.0 - 10.0			
FRB	5.5	5.0											0							-			
TAN2	11.1	11.1	9.7										1,970	12.2	11.8	2.7	2.0	22.6	16.9	7.8 - 15.7	24	7	2
CLAW	13.5	12.6	11.5										809	13.4	13.4	1.6	1.1	11.8	8.4	11.1 - 15.6	19	3	1
KEY	6.9	7.0	5.3										539	6.5	6.3	1.6	1.0	24.8	15.7	4.3 - 8.2	14	4	2

LAB #	33273	33313
ORIGINAL	31.2	8.5
DUPLICATE	30.9	8.2
% RD	1.2	3.1

<u>Outliers</u>	<u>Blinds</u>	<u>All QCs</u>	<u>Acceptable</u>	<u>Reject</u>	Total Adjusted Outliers (>66.7%)	17/18 94.4%
1 SD		7/9 77.8%	(>=33.3%)			
2 SD		9/9 100.0%	(>=66.7%)	(<25%)		
3 SD		9/9 100.0%	(100%)	(<75%)		
					Agronomic Relevance	5

Order of Analysis:

Missing Samples: NONE

<u>Approved</u>	<u>Date / Tme</u>	<u>Name</u>	<u>Type</u>	<u>Comment</u>
Y	07/05/2018 3:54 pm	StevenH	Signer	
Y	07/05/2018 12:52 pm	CaseyJ	Analyst	

[X] ACCEPTABLE: May release all data upon final review of individual results.

[] CAUTION: May release some or all data upon intense scrutiny of individual results.

[] REJECTION: Hold all data and re-analyse part or all data.

Lab SampleRange: 33199-33316

Amarillo: Soil Data Quality Control Report

Soil: Mehlich 3 Extractable Sulfur (ICP)

Jul 5 2018 7:27AM 547509 Batch: A Instrument: Agilent ICP 5100

Sample													Count	X1	XL	STD1	STDL	RSTD1	RSTD1	Acceptable Range	Outliers LT(%)		
	1	2	3	4	5	6	7	8	9	10	11	12									1	2	3
CCV	2.1	2.1	2.1										3,238	2.0		0.1		6.7		1.8 - 2.2			
MB	<u>-3.5</u>	-0.6											2,012	0.3		1.9				-1.0 - 1.0			
FRB	-1.2	0.3											0							-			
TAN2	9.7	8.7	7.7										2,019	9.1	9.0	1.3	1.1	14.6	11.9	6.9 - 11.1	25	3	1
CLAW	11.0	10.4	9.4										828	12.2	12.1	2.1	1.4	17.3	11.5	9.3 - 14.8	13	2	1
KEY	8.7	11.3	8.5										535	10.3	10.3	1.8	1.3	17.7	13.1	7.6 - 13.0	20	2	1

LAB #	33273	33313
ORIGINAL	8.1	7.8
DUPLICATE	9.7	8.3
% RD	18.1	6.9

<u>Outliers</u>	<u>Blinds</u>	<u>All QCs</u>	<u>Acceptable</u>	<u>Reject</u>	<u>Total Adjusted Outliers (>66.7%)</u>	17/18 94.4%
1 SD		4/9 44.4%	(>=33.3%)			
2 SD		9/9 100.0%	(>=66.7%)	(<25%)	Agronomic Relevance	5
3 SD		9/9 100.0%	(100%)	(<75%)		

Order of Analysis:

Missing Samples: NONE

<u>Approved</u>	<u>Date / Tme</u>	<u>Name</u>	<u>Type</u>	<u>Comment</u>
Y	07/05/2018 3:54 pm	StevenH	Signer	
Y	07/05/2018 12:52 pm	CaseyJ	Analyst	

[X] ACCEPTABLE: May release all data upon final review of individual results.

[] CAUTION: May release some or all data upon intense scrutiny of individual results.

[] REJECTION: Hold all data and re-analyze part or all data.

Lab SampleRange: 33295-33306

Amarillo: Soil Data Quality Control Report

Hydrometer

Soil: Percent Sand (Hydrometer)

Jul 5 2018 7:42AM 547521 Batch: A Instrument: AMA-BAL1 AE200-012

Sample	1	2	3	4	5	6	7	8	9	10	11	12	Count	X1	XL	STD1	STDL	RSTD1	RSTDL	Acceptable Range	Outliers LT(%)		
																					1	2	3
MB	100.00												197	100.00		0.00		0.0		99.00 - 100.00			
PLP	<u>54.03</u>												60	47.84	46.96	5.00	2.97	10.4	6.3	41.02 - 52.90	12	5	2
LAB #	33298																						
ORIGINAL	65.53																						
DUPLICATE	65.52																						
% RD	0.0																						
<u>Outliers</u>	<u>Blinds</u>			<u>All QCs</u>			<u>Acceptable</u>			<u>Reject</u>			Total Adjusted Outliers (>66.7%)			3/3 100.0%							
1 SD					<u>0/1</u>	0.0%	(>=33.3%)																
2 SD					1/1	100.0%	(>=66.7%)			(<25%)													
3 SD					1/1	100.0%	(100%)			(<75%)													

Order of Analysis: MB-1, PLP-1, 33295-33296, 33298-33306, >33298

Missing Samples:

<u>Approved</u>	<u>Date / Tme</u>	<u>Name</u>	<u>Type</u>	<u>Comment</u>
Y	07/06/2018 4:53 pm	ARRoyle	Signer	
Y	07/06/2018 4:10 pm	JacobD	Analyst	

[] ACCEPTABLE: May release all data upon final review of individual results.

[] CAUTION: May release some or all data upon intense scrutiny of individual results.

[x] REJECTION: Hold all data and re-analyse part or all data.

Lab SampleRange: 33295-33306

Amarillo: Soil Data Quality Control Report

Soil: Percent Clay (Hydrometer)

Jul 5 2018 7:42AM 547521 Batch: A Instrument: AMA-BAL1 AE200-012

Sample	1	2	3	4	5	6	7	8	9	10	11	12	Count	X1	XL	STD1	STD1	RSTD1	RSTD1	Acceptable Range	Outliers LT(%)		
																					1	2	3
MB	0.00												197	0.00		0.00				-2.00 - 2.00			
PLP	16.15												60	14.59	14.63	1.70	1.25	11.6	8.5	12.14 - 17.12	15	3	3
LAB #	33298																						
ORIGINAL	19.70																						
DUPLICATE	19.70																						
% RD	0.0																						
Outliers	Blinds		All QCs		Acceptable		Reject		Total Adjusted Outliers (>66.7%)											3/3 100.0%			
1 SD			0/1 0.0%		(>=33.3%)																		
2 SD			1/1 100.0%		(>=66.7%)		(<25%)																
3 SD			1/1 100.0%		(100%)		(<75%)																

Order of Analysis:

Missing Samples: NONE

<u>Approved</u>	<u>Date / Tme</u>	<u>Name</u>	<u>Type</u>	<u>Comment</u>
Y	07/06/2018 4:53 pm	ARRoyle	Signer	
Y	07/06/2018 4:10 pm	JacobD	Analyst	

[] ACCEPTABLE: May release all data upon final review of individual results.

[x] CAUTION: May release some or all data upon intense scrutiny of individual results.

[] REJECTION: Hold all data and re-analyse part or all data.

Lab SampleRange: 33202-33310

Amarillo: Soil Data Quality Control Report

pH Electrode

Soil: pH Water-Soil (1:1)

Jul 5 2018 8:23AM 547544 Batch: A Instrument: Amarillo Auto pH

Sample	1	2	3	4	5	6	7	8	9	10	11	12	Count	X1	XL	STD1	STDL	RSTD1	RSTDL	Acceptable Range		Outliers LT(%)		
																				1	2	3		
CCV	4.10	4.09	4.09	4.16	4.10	4.10							6,124	4.12		0.06		1.4		4.00 -	4.40			
HAR1	5.21	5.24	5.18	5.20	5.18	5.17							3,021	5.17	5.18	0.09	0.07	1.7	1.4	5.03 -	5.33	28	4	1
LAB #	33204	33269	33285	33295	33304	33307																		
ORIGINAL	8.03	8.20	7.97	7.65	7.94	8.09																		
DUPLICATE	8.14	8.14	7.29	7.73	7.77	7.89																		
% RD	1.3	0.7	8.9	1.1	2.2	2.4																		
Outliers	Blinds		All QCs		Acceptable		Reject		Total Adjusted Outliers (>66.7%)										17/18	94.4%				
1 SD			6/6 100.0%		(>=33.3%)																			
2 SD			6/6 100.0%		(>=66.7%)		(<25%)												Agronomic Relevance		0.1			
3 SD			6/6 100.0%		(100%)		(<75%)																	

Order of Analysis: 33202-33206, 33265, 33267, >33204, CCV-1, HAR1-1, 33269, 33271, 33273, 33275, 33277, 33279, 33281, >33269, CCV-2, HAR1-2, 33283, 33285, 33287, 33289, 33291, 33293, 33295, >33285, CCV-3, HAR1-3, 33296-33302, >33295, CCV-4, HAR1-4, 33303-33309, >33304, CCV-5, HAR1-5, 33310, >33307, CCV-6, HAR1-6

Missing Samples:

<u>Approved</u>	<u>Date / Tme</u>	<u>Name</u>	<u>Type</u>	<u>Comment</u>
Y	07/05/2018 3:52 pm	StevenH	Signer	
Y	07/05/2018 12:21 pm	AuroraD	Analyst	

[] ACCEPTABLE: May release all data upon final review of individual results.

[X] CAUTION: May release some or all data upon intense scrutiny of individual results.

[] REJECTION: Hold all data and re-analyse part or all data.

Lab SampleRange: 33202-33310

Amarillo: Soil Data Quality Control Report

Soil: Soluble Salts Water-Soil EC (1:1) mmho/cm

Jul 5 2018 8:23AM 547544 Batch: A Instrument: AMA-EC JenWay

Sample	1	2	3	4	5	6	7	8	9	10	11	12	Count	X1	XL	STD1	STD1	RSTD1	RSTD1	Acceptable Range	Outliers LT(%)		
																					1	2	3
CCV	1.427	1.412	1.426	1.410	1.405	1.410							0							-			
HAR1	0.346	0.334	0.343	0.328	0.342	0.341							3,026	0.339	0.336	0.025	0.021	7.5	6.1	0.295 - 0.378	29	5	1
LAB #	33204	33269	33285	33295	33304	33307																	
ORIGINAL	0.464	0.122	0.383	0.370	0.176	0.224																	
DUPLICATE	0.470	0.112	0.407	0.386	0.189	0.232																	
% RD	1.3	8.5	6.1	4.2	7.3	3.5																	
Outliers	Blinds		All QCs		Acceptable		Reject		Total Adjusted Outliers (>66.7%)										18/18	100.0%			
1 SD			6/6 100.0%		(>=33.3%)																		
2 SD			6/6 100.0%		(>=66.7%)		(<25%)												Agronomic Relevance		0.05		
3 SD			6/6 100.0%		(100%)		(<75%)																

Order of Analysis:

Missing Samples: NONE

<u>Approved</u>	<u>Date / Tme</u>	<u>Name</u>	<u>Type</u>	<u>Comment</u>
Y	07/05/2018 3:52 pm	StevenH	Signer	
Y	07/05/2018 12:21 pm	AuroraD	Analyst	

[X] ACCEPTABLE: May release all data upon final review of individual results.

[] CAUTION: May release some or all data upon intense scrutiny of individual results.

[] REJECTION: Hold all data and re-analyse part or all data.

Lab SampleRange: 33202-33310

Soil: Buffer pH - Sikora

Amarillo: Soil Data Quality Control Report
Jul 5 2018 8:23AM 547544 Batch: A Instrument: Amarillo Auto pH

Sample													Count	X1	XL	STD1	STDL	RSTD1	RSTD1	Acceptable Range	Outliers LT(%)		
	1	2	3	4	5	6	7	8	9	10	11	12									1	2	3
CCV	6.42	6.44	6.45	6.42	6.44	6.43							1,171	6.52		0.19		2.8		6.29 - 6.59			
HAR1	6.55	6.54	6.60	6.56	6.55	6.56							1,404	6.58	6.58	0.06	0.04	0.9	0.6	6.50 - 6.66	16	3	2

LAB #
ORIGINAL
DUPLICATE
% RD

Outliers	Blinds	All QCs	Acceptable	Reject	Total Adjusted Outliers (>66.7%)	12/12 100.0%
1 SD		5/6 83.3%	(>=33.3%)			
2 SD		6/6 100.0%	(>=66.7%)	(<25%)		
3 SD		6/6 100.0%	(100%)	(<75%)	Agronomic Relevance	0.1

Order of Analysis:

Missing Samples: 33202 33203 33204 33205 33206 33265 33267 >33204 33269 33271 33273 33275 33277 33279 33281 >33269 33283 33285 33287 33289 33291 33293 33295 >33285 33296 33297 33298 33299 33300 33301 33302 >33295 33303 33304 33305 33306 33307 33308 >33304 >33307

Approved	Date / Tme	Name	Type	Comment
Y	07/05/2018 3:52 pm	StevenH	Signer	
Y	07/05/2018 12:21 pm	AuroraD	Analyst	

- [X] ACCEPTABLE: May release all data upon final review of individual results.
 [] CAUTION: May release some or all data upon intense scrutiny of individual results.
 [] REJECTION: Hold all data and re-analyse part or all data.

Lab SampleRange: 33297-33392

Amarillo: Soil Data Quality Control Report

Hydrometer

Soil: Percent Sand (Hydrometer)

Jul 9 2018 7:36AM 547850 Batch: A Instrument: AMA-YSI 2700

Sample	1	2	3	4	5	6	7	8	9	10	11	12	Count	X1	XL	STD1	STDL	RSTD1	RSTD1	RSTD1	RSTD1	Acceptable Range	Outliers LT(%)											
	1	2	3																															
MB	100.00												198	100.00		0.00		0.0			99.00 - 100.00													
PLP	52.91												61	47.94	47.08	5.02	3.09	10.5	6.6		40.91 - 53.26	13	5	2										
LAB #	33297																																	
ORIGINAL	72.77																																	
DUPLICATE	71.83																																	
% RD	1.3																																	
Outliers	Blinds												All QCs												Acceptable	Reject	Total Adjusted Outliers (>66.7%) 3/3 100.0%							
1 SD													1/1 100.0%												>=33.3%									
2 SD													1/1 100.0%												>=66.7%					<25%				
3 SD													1/1 100.0%												(100%)					<75%				

Order of Analysis: MB-1, PLP-1, 33297, 33392, >33297

Missing Samples:

<u>Approved</u>	<u>Date / Time</u>	<u>Name</u>	<u>Type</u>	<u>Comment</u>
Y	07/10/2018 3:24 pm	KellyB	Signer	
Y	07/10/2018 2:58 pm	JacobD	Analyst	

[X] ACCEPTABLE: May release all data upon final review of individual results.

[] CAUTION: May release some or all data upon intense scrutiny of individual results.

[] REJECTION: Hold all data and re-analyse part or all data.

Lab SampleRange: 33297-33392

Amarillo: Soil Data Quality Control Report

Soil: Percent Clay (Hydrometer)

Jul 9 2018 7:36AM 547850 Batch: A Instrument: AMA-YSI 2700

Sample	1	2	3	4	5	6	7	8	9	10	11	12	Count	X1	XL	STD1	STD1	RSTD1	RSTD1	Acceptable Range	Outliers LT(%)		
																					1	2	3
MB	0.00												198	0.00		0.00				-2.00 - 2.00			
PLP	14.87												61	14.62	14.65	1.69	1.25	11.6	8.5	12.15 - 17.15	15	3	3
LAB #	33297																						
ORIGINAL	17.33																						
DUPLICATE	15.92																						
% RD	8.5																						
<u>Outliers</u>		<u>Blinds</u>				<u>All QCs</u>							<u>Acceptable</u>		<u>Reject</u>						Total Adjusted Outliers (>66.7%) 3/3 100.0%		
1 SD					1/1	100.0%							(>=33.3%)										
2 SD					1/1	100.0%							(>=66.7%)		(<25%)								
3 SD					1/1	100.0%							(100%)		(<75%)								

Order of Analysis:

Missing Samples: NONE

<u>Approved</u>	<u>Date / Tme</u>	<u>Name</u>	<u>Type</u>	<u>Comment</u>
Y	07/10/2018 3:24 pm	KellyB	Signer	
Y	07/10/2018 2:58 pm	JacobD	Analyst	

[X] ACCEPTABLE: May release all data upon final review of individual results.

[] CAUTION: May release some or all data upon intense scrutiny of individual results.

[] REJECTION: Hold all data and re-analyse part or all data.

SAMPLE LOCATION PLAN

City of McAllen Softball Field Facilities Municipal Park ■ McAllen, TX

July 9, 2018 ■ Terracon Project No. 88181117



DIAGRAM IS FOR GENERAL LOCATION ONLY, AND IS NOT
INTENDED FOR CONSTRUCTION PURPOSES

AERIAL PHOTOGRAPHY PROVIDED BY
MICROSOFT BING MAPS

ADD#1
July 26, 2018

“Softball Field Facilities Municipal Park Reno.”

PLEASE NOTE CHANGES AS FOLLOWS:

Structural Attachments:

B. Replacement of (3) 22x34 sheets (S3.0, S4.0, and S5.0).


End of ADD #1



Mc

ADDENDUM 1 NARRATIVE

To: City of McAllen Parks and Recreation. **Date:** 07/26/2018
From: Hugo H. Avila, P.E.
Thomas E. Dearmin, P.E. **AVO:** 33348.001
Email: hAvila@Halff.com **Project:** City of McAllen Softball Field Facilities.
TDearmin@halff.com Municipal Park.
Subject: Addendum No. 1

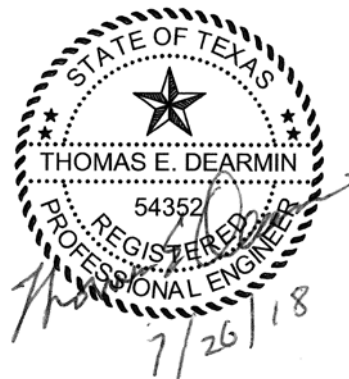

The following are additions, modifications and clarification notes made to the plans and specifications. The changes are outlined by item number.

MECHANICAL

- ITEM 1. Modification: Sheet M1.01, to Keyed Note 1. Modified verbiage to reflect cupola addition.
- ITEM 2. Modification: Sheet M1.01, to Mechanical Plan. Removed relief hoods and re-route ductwork.
- ITEM 3. Removal: Sheet M2.01, Relief Hood Schedule. Relief Hood Schedule has been deleted. Schedule no longer applies

ELECTRICAL

- ITEM 1. Addition: Sheet E1.04, added cupola plans for lighting and power. Added Keyed Notes #10 and #11.
- ITEM 2. Modification: Sheet E3.04, modified panel schedule 'L3' to reflect electrical circuit to outlet at cupola.

PLUMBING

- ITEM 1. Modification: Sheet P1.01, added Keyed Note 4. Keynote to terminate VTR inside cupola addition.
- ITEM 2. Modification: Sheet P1.01, added Keyed Note 5. Keynote to incorporate trap primer lines under slab.
- ITEM 3. Modification: Sheet P1.02, added trap primer valve above ceiling.

STORM DRAINAGE LINE CONSTRUCTION NOTES:

CITY OF McALLEN
SOFTBALL FIELD FACILITIES
MUNICIPAL PARK
McALLEN, TEXAS

- 1) CONTRACTOR TO PROVIDE POSITIVE OUTFLOW FOR DRAINAGE BASIN AT ALL TIMES. IN THE CASE OF A STORM EVENT, CAPACITY FOR STORM WATER RUNOFF SHALL BE PROVIDED ON SITE AS A TEMPORARY DETENTION FACILITY TO MINIMIZE ADJACENT LOCAL FLOODING.
- 2) CONTRACTOR SHALL PROVIDE A SEQUENCE OF WORK FOR STORM DRAINAGE TIE INS THAT PROVIDES POSITIVE OUTFLOW AT ALL TIMES.
- 3) CONTRACTOR TO FIELD VERIFY THE LOCATION OF EXISTING UTILITIES & FACILITIES PRIOR TO CONSTRUCTION.
- 4) ALL REINFORCED CONCRETE STORM PIPES SHALL BE CLASS III WITH RUBBER GASKET SEALED JOINTS, UNLESS OTHERWISE NOTED ON PLANS.
- 5) ALL HIGH DENSITY POLYETHYLENE (HDPE) STORM PIPES SHALL HAVE WATERTIGHT JOINTS.

- | | | |
|--|-------|----------|
| CITY OF MCALLEN PUBLIC UTILITY (MPU) | (956) | 681-1600 |
| CITY OF MCALLEN PUBLIC WORKS | (956) | 681-4000 |
| TEXAS ONE CALL | (800) | 344-8377 |
| TESS | (800) | 810-7676 |
| TEXAS 511 SERVICE | (800) | 700-2443 |
| AT&T TEXAS | (800) | 288-2020 |
| TIME WARNER CABLE | (800) | 222-5355 |
| AEP TEXAS | (800) | 344-8377 |
| CITY OF MCALLEN ENGINEERING DEPARTMENT | (956) | 681-1130 |
| CITY OF MCALLEN MAINTENANCE | (956) | 681-1700 |
| CITY OF MCALLEN WASTE WATER SYSTEMS | (956) | 681-1700 |
| CITY OF MCALLEN TRAFFIC OPS (CITY FIBER) | (956) | 681-2500 |

- 2) CONTRACTOR TO EXPOSE ANY EXISTING UTILITY THAT MAY BE IN CONFLICT PRIOR TO START OF EXCAVATION.
- 3) ALL EXISTING UTILITIES SHOWN ARE FROM BEST INFORMATION AVAILABLE. NEITHER THE ENGINEER NOR THE CITY TAKE RESPONSIBILITY FOR ACCURACY OF LOCATION.
- 4) CONTRACTOR SHALL AT ALL TIMES ALLOW ACCESS TO EXISTING DRIVEWAY OR PROVIDE/MAINTAIN ALTERNATIVE ALL-WEATHER ROUTES.
- 5) ANY DAMAGES TO FENCES, WALKS, OR PRIVATE PROPERTY SHALL BE REPAIRED BY THE CONTRACTOR AT HIS EXPENSE.
- 6) ALL CONSTRUCTION MATERIALS TESTING WILL BE COORDINATED THROUGH THE OWNER.
- 7) WORK REQUIRED TO BE INSPECTED BY THE CITY SHALL OCCUR DURING REGULAR WORKING HOURS, MONDAY THROUGH FRIDAY. NO WORK TO OCCUR DURING CITY HOLIDAYS, NON-WORKING HOURS, MONDAY THROUGH FRIDAY, AND WEEKENDS UNLESS APPROVED BY THE CITY. INSPECTION OVERTIME COSTS TO BE PAID BY CONTRACTOR.
- 8) USE CLASS 'B' EMBEDMENT FOR UTILITY TRENCHES UNDER PAVEMENT.
- 9) IT SHALL BE THE CONTRACTOR'S RESPONSIBILITY TO REMOVE ALL EXCAVATED MATERIAL AND DEBRIS FROM THE SITE.
- 10) McALLEN PUBLIC UTILITY (MPU) NOTE- ALL EXISTING WATER MAINS AND FIRE HYDRANTS ARE TO REMAIN ACTIVE UNTIL PROPOSED WATER IMPROVEMENTS ARE COMPLETE AND READY FOR CONNECTION. NIGHT TIME CONNECTIONS WILL BE REQUIRED.
- 11) McALLEN PUBLIC UTILITY (MPU) NOTE- CONTRACTOR IS RESPONSIBLE FOR COORDINATING WITH MPU REGARDING REMOVAL OF EXISTING WATER METERS PRIOR TO COMMENCEMENT OF ANY REMOVED WORK.
- 12) McALLEN PUBLIC UTILITY (MPU) NOTE- EXISTING SEWER MAINS ARE TO REMAIN ACTIVE UNTIL PROPOSED SECTIONS ARE COMPLETE AND READY FOR CONNECTION.
- 13) CONTRACTOR IS RESPONSIBLE FOR ALL MPU FEES AS REQUIRED INCLUDING BUT NOT LIMITED TO TAPPING AND METER FEES.

BENCHMARK AND TOPOGRAPHY NOTES:

TEMPORARY BENCHMARKS (TBM) AND TOPOGRAPHIC SURVEY INFORMATION WAS PROVIDED BY THE CITY OF MCALLEN UNDER SEPERATE CONTRACT:

- 1) TBM #1: SET ON CURB INLET WITHIN PARK'S PARKING LOT LIMITS, APPROXIMATELY 450' WEST OF THE INTERSECTION OF QUINCE ST. AND N. BICENTENNIAL BLVD.
ELEVATION= 115.16 (NAVD88)
N= 16505622.31
E= 1070065.94
(NAD83)

PAVING CONSTRUCTION NOTES:

- 1) HOT MIX ASPHALT CONCRETE TO BE IN ACCORDANCE WITH TXDOT SPECIFICATION TYPE "D"
- 2) SUBGRADE EXCAVATION AND RECOMPACTION TO BE INCLUDED IN PRICE BID PER SQUARE YARD FOR "LIME TREATED SUBGRADE."
- 3) CONTRACTOR TO FILL BEHIND CURBS AND WALKS AND SHAPE TO ENSURE PROPER DRAINAGE.
- 4) CONTRACTOR SHALL "LAY DOWN" CURB SECTION AT DRIVEWAYS LOCATIONS SHOWN ON DRAWINGS. CONTRACTOR SHALL BE REQUIRED TO GRADE FROM EXISTING DRIVES AND PARKING AREAS TO MATCH GRADES AND ALLOW SMOOTH TRANSITIONS AND PROPER DRAINAGE. (NO SEPARATE PAY)
- 5) CONSTRUCTION JOINTS TO EXISTING PAVEMENT SHALL BE MADE BY EITHER CUTTING BACK EXISTING TO PRODUCE A SLIGHTLY BEVELED EDGE FOR THE FULL THICKNESS OF THE WEARING COURSE OR A SUITABLE LAP JOINT SHALL BE MADE. SAW CUTTING REQUIRED.
- 6) NO TRAFFIC SHALL BE ALLOWED ON THE FINISHED WEARING SURFACE UNTIL AT LEAST 12 HOURS AFTER COMPLETION OF ROLLING.
- 7) WHEN TYING INTO EXISTING CURB, EXPOSE REBAR AND FORM EXPANSION JOINT PER DETAIL.
- 8) ANY SETTLEMENT UNDER PAVEMENT DUE TO INADEQUATE COMPACTION OF UTILITY LINE BACKFILL SHALL BE CAUSE FOR RECOMPACTION OF TRENCH AND REPLACEMENT OF PAVEMENT SECTION AT CONTRACTOR'S EXPENSE.
- 9) HOT MIX ASPHALT CONCRETE TRANSPORT TRUCKS TO BE EQUIPPED WITH CANVAS COVERS TO BE UTILIZED DURING MATERIAL HAULING. MATERIAL DELIVERED TO SITE AT IMPROPER TEMPERATURE SHALL BE REJECTED. HOT MIX SHALL BE LAID AT A MINIMUM TEMPERATURE OF 225°F

- 1) ALL PROPOSED SEWER LINES WILL BE SDR 26 PIPE MATERIAL (UNLESS OTHERWISE NOTED).
- 2) CONTRACTOR TO PROVIDE DEFLECTION TEST IN ACCORDANCE WITH TCEQ CHAPTER 217.57 (b),
MANDRAL TO BE PULLED IN BOTH DIRECTIONS
- 3) CONTRACTOR TO PROVIDE LOW PRESSURE AIR TEST IN ACCORDANCE WITH TCEQ CHAPTER 217.57 (a),
(1), 30 DAYS AFTER INSTALLATION. NO WATER TEST ALLOWED.
- 4) CONTRACTOR TO FIELD VERIFY THE LOCATION OF EXISTING UTILITIES & FACILITIES PRIOR
TO CONSTRUCTION.
- 5) ALL CROSSING OF WASTEWATER COLLECTION LINES AND WATERLINES CONSTRUCTED IN
ACCORDANCE WITH TCEQ REGULATIONS CHAPTER 290 AND 217.
- 6) CONTRACTOR TO PROVIDE LEAKAGE TEST FOR MANHOLE IN ACCORDANCE WITH TCEQ CHAPTER
217.58 (a), (b) OF THE STATE WASTEWATER CODE NO WATER TEST ALLOWED.
- 7) NO WATER JETTING ALLOWED, MECHANICAL COMPACTION REQUIRED.
- 8) ALL STRUCTURES TO BE ADJUSTED BY THE CONTRACTOR TO MEET FINAL GRADES, A
MAXIMUM OF 2 FEET OF THROAT RINGS WILL BE ALLOWED.

BENCHMARKS PROVIDED BY CITY OF McALLEN

TBM #1
SET ON CURB INLET WITHIN PARK'S PARKING LOT LIMITS , APPROXIMATELY 450' WEST OF THE INTERSECTION OF QUINCE ST. AND N. BICENTENNIAL BLVD. ELEVATION= 115.16 (NAVD88) E= 16605622.31 E= 1070065.94 (NAD83)
TBM #2
SET ON CURB INLET AT THE SOUTHWEST CORNER OF TAMARACK AVENUE AND N. BICENTENNIAL BLVD. ELEVATION= 115.80 (NAVD88) E= 16606328.72 E= 1070579.89 (NAD83)

Project No.: 33348.001

Issued: July 2018

Drawn By: FC

Checked By: RM

Scale: AS NOTED

Sheet Title

GENERAL NOTES

C0.02

Sheet Number




AREA OF DEMOLITION

NOTES:

1. ALL MATERIAL CALLED OUT TO BE REMOVED BY THE CONTRACTOR SHALL BE DISPOSED IN A LEGAL MANNER AT THE CONTRACTOR'S EXPENSE.
2. PAVEMENT REMOVAL IS INCLUDING, BUT NOT LIMITED TO, ASPHALT PAVEMENT, BASE MATERIAL, SUBGRADE, CURB & GUTTER, WHEEL STOPS AND CONCRETE SIDEWALK AS REQUIRED.
3. POLES AND BASES TO BE REMOVED. SIGNS TO BE SALVAGED AND REUSED.
4. DURING CONSTRUCTION THE CONTRACTOR MAY ENCOUNTER BURIED CONCRETE FOUNDATIONS WITH REBAR. THE CONTRACTOR WILL BE RESPONSIBLE FOR REMOVAL AND DISPOSAL OF SAID FOUNDATIONS TO A DEPTH OF FIVE (5) FEET. BIDDERS SHALL PROVIDE A UNIT COST (PER TON) FOR THIS ITEM. THE OWNER WILL REQUIRE THE CONTRACTOR TO PROVIDE CERTIFIED WEIGHT TICKETS FOR PAYMENT OF THIS ITEM.
5. COORDINATE WITH LANDSCAPE PLANS FOR ADDITIONAL TREES THAT MAY NEED REMOVAL.
6. COORDINATE WITH IRRIGATION PLANS FOR ADDITIONAL IRRIGATION INFORMATION.

LEGEND			
	WATER VALVE		SIGN
	FRESNO TREE		WATER VALVE MARKER
	MESQUITE TREE		TELEPHONE MARKER
	ALAMO TREE		FIRE HYDRANT
	EBONY TREE		CONTROL VALVE
	PALM TREE		TRAFFIC SIGN
	DOWN GUY		POWER POLE
	LIGHT POLE		TRAFFIC SIGNAL BOX
	ELECTRICAL BOX		FIELD DRAIN/GRATED INLET
	WATER METER		TV CABLE BOX
	SPRINKLER		TRANSFORMER
	MANHOLE DRAIN		SANITARY SEWER MANHOLE
	INLET		
			W — WATER LINE
			— GAS LINE
			— SAN. SEW. LINE
			— D — DRAINAGE LINE
			— T — TELEPHONE LINE
			— IR — IRRIGATION LINE
			— F — FENCE LINE
			— W — WROUGHT IRON FENCE

0 25 50 75 100
SCALE: 1"=50' (22 X 34)
SCALE 1"=100' (11 X 17)

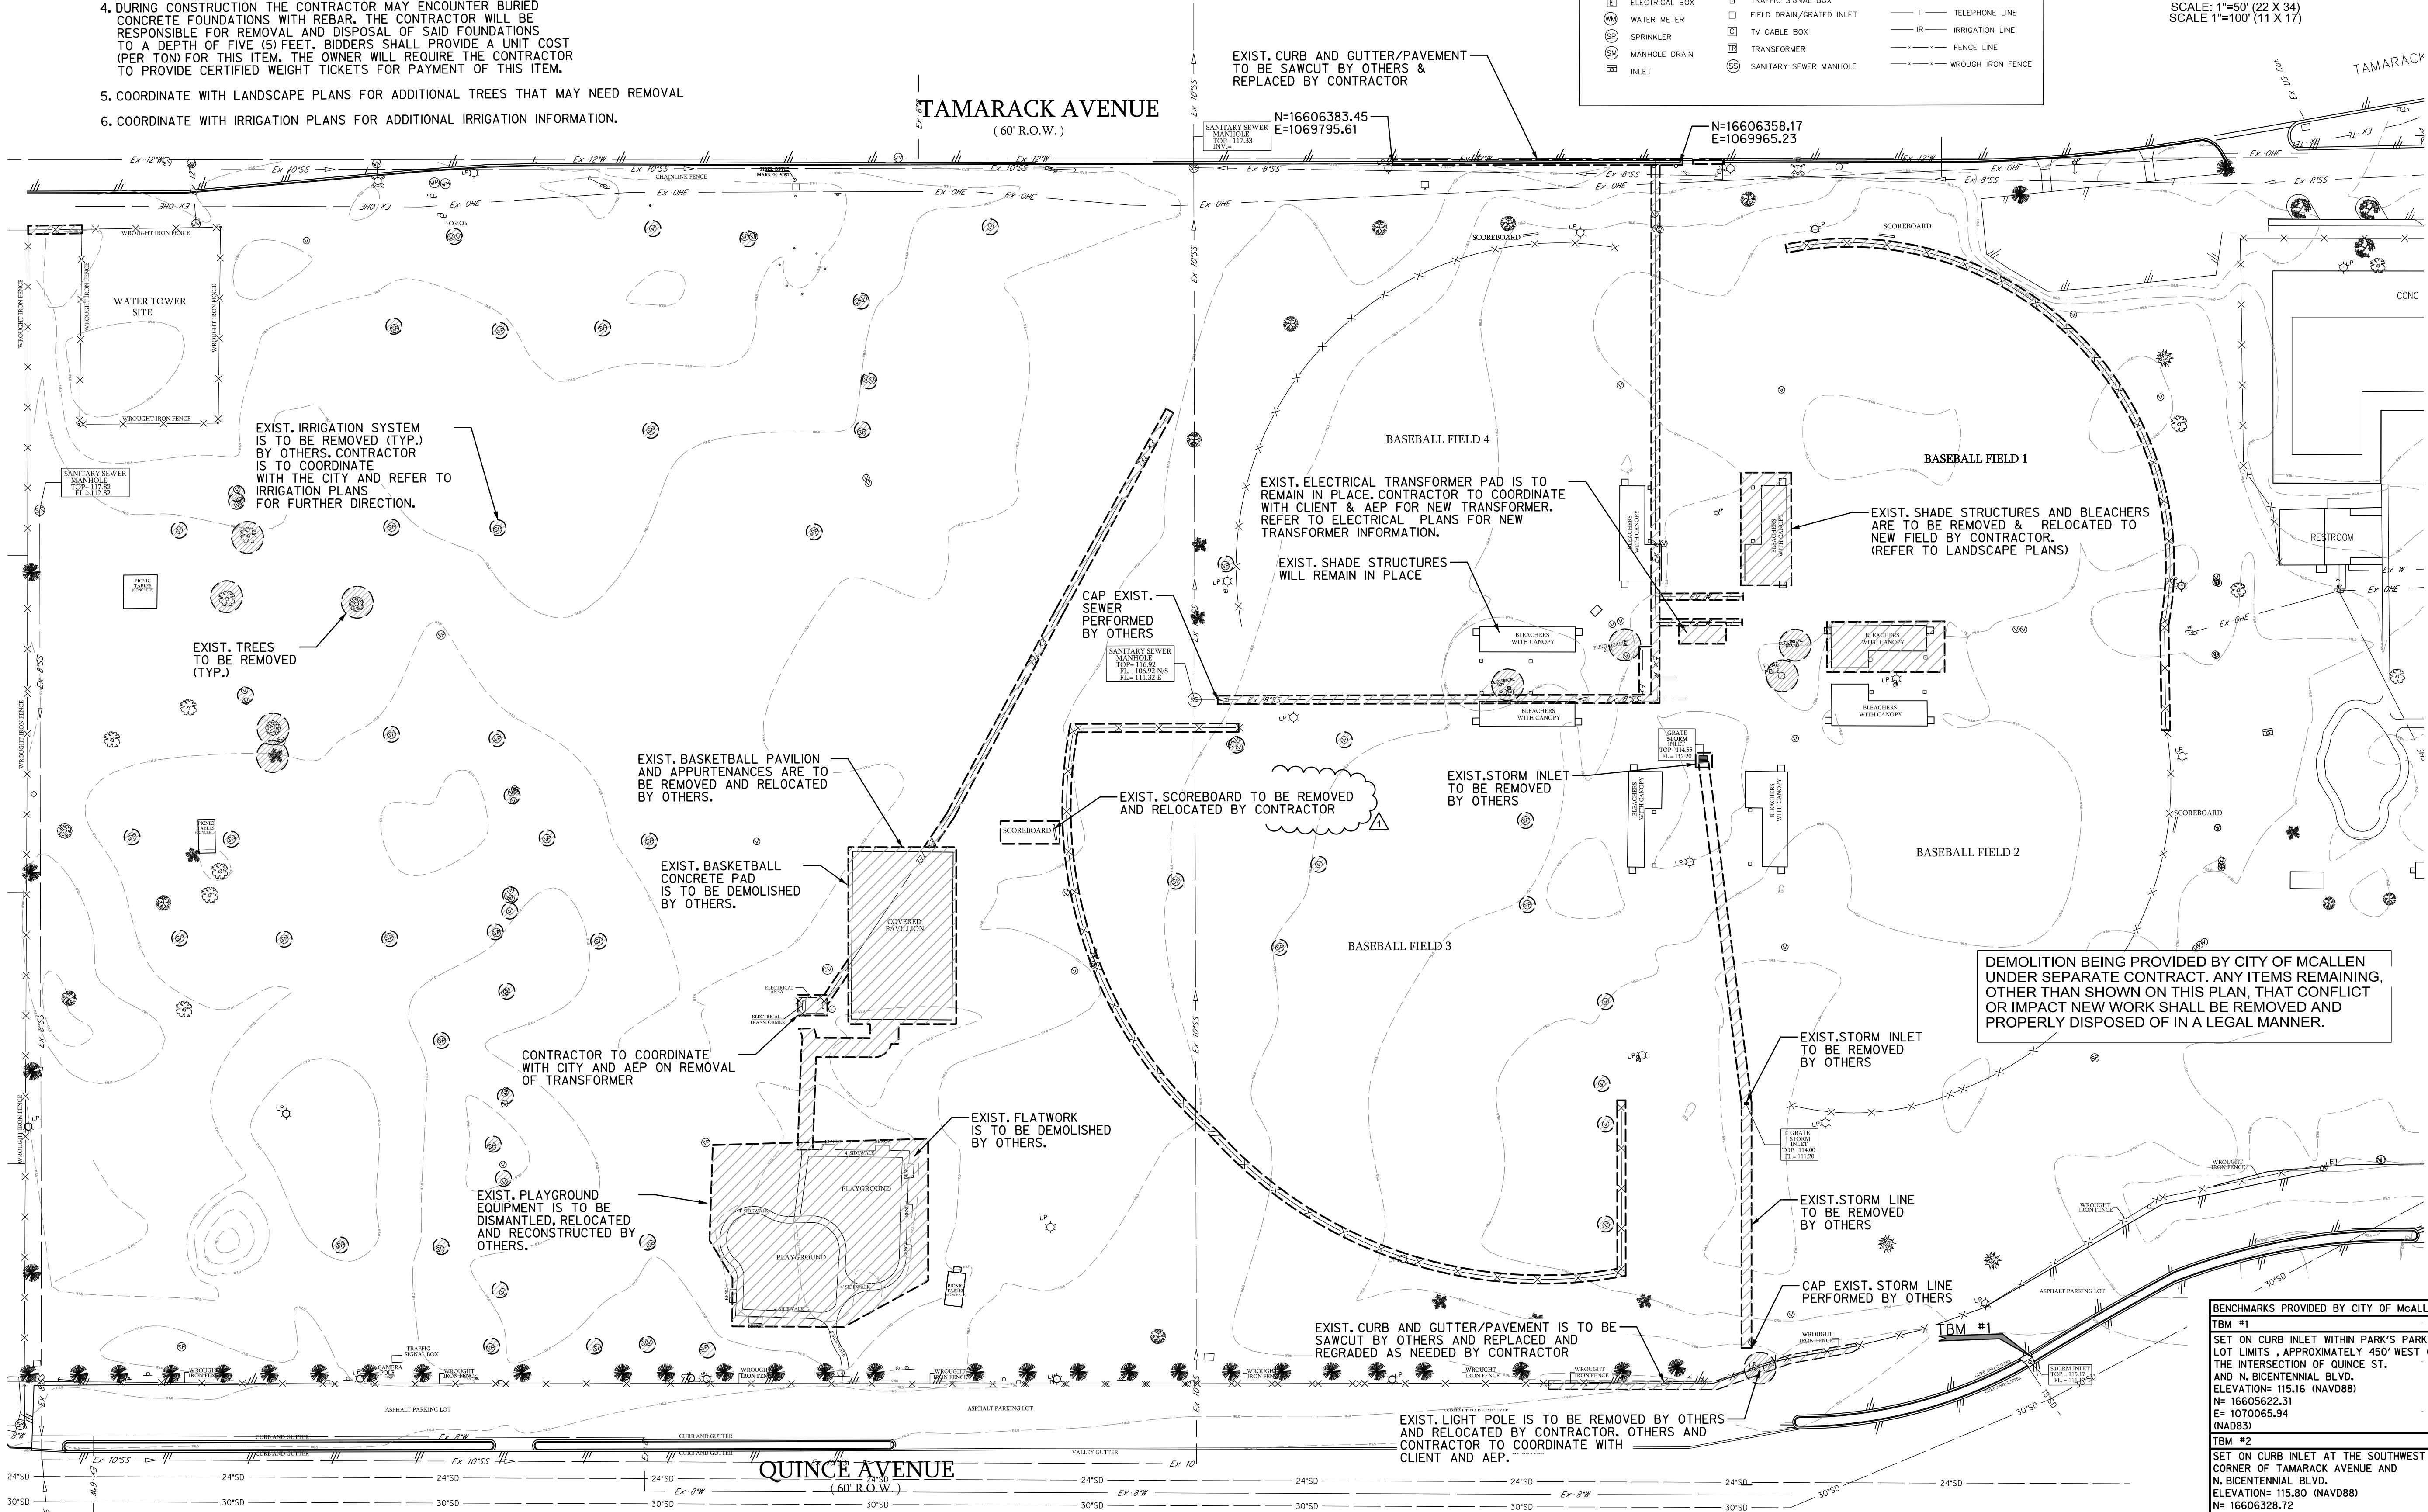

CITY OF McALLEN
SOFTBALL FIELD FACILITIES
MUNICIPAL PARK
McALLEN, TEXAS



5000 WEST MILITARY HWY., SUITE 100
McALLEN, TEXAS 78503
TEL (956) 664-4286
FAX (956) 664-4282
TDC# FNNR-512

Revision No.	Date	Description	Addendum No.
1	7-26-2018		No.1



The Seal appearing on this document was authorized by Robert L. Saenz, P.E. Number 82072 on July 26, 2018. Alteration of a sealed document without proper notification to the responsible engineer is an offense under the Texas Engineering Practice Act. The Record Copy of this drawing is on file at the office of HALFF Associates, Inc., 5000 W. Military, Suite 100, McAllen, TX 78503. TBP# FNNR-512


Project No.: 33348.001
Issued: July 2018
Drawn By: FC
Checked By: RM
Scale: AS NOTED
Sheet Title

DEMOLITION PLAN
(FOR INFORMATION ONLY)

C0.04

Sheet Number

BENCHMARKS PROVIDED BY CITY OF McALLEN
TBM #1
SET ON CURB INLET WITHIN PARK'S PARKING LOT LIMITS, APPROXIMATELY 450' WEST OF THE INTERSECTION OF QUINCE ST. AND N. BICENTENNIAL BLVD.
ELEVATION= 115.16 (NAVD88)
N= 16605622.31
E= 1070065.94
(NAD83)
TBM #2
SET ON CURB INLET AT THE SOUTHWEST CORNER OF TAMARACK AVENUE AND N. BICENTENNIAL BLVD.
ELEVATION= 115.80 (NAVD88)
N= 16606328.72
E= 1070579.89
(NAD83)

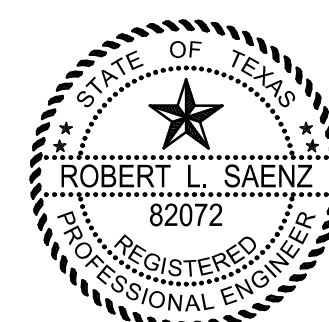
[illegible]


The Seal appearing on this document was authorized by Robert L. Soenz, P.E. Number 82072 on July 26, 2018. Alteration of a sealed document without proper notification to the responsible engineer is an offense under the Texas Engineering Practice Act. The Record Copy of this drawing is on file at the offices of Haff Associates, Inc., 5000 W. Military Suite 100, McAllen, TX 78503. TSPE FIRM #F-312

CONTROL PLAN

CT.02

Sheet Number

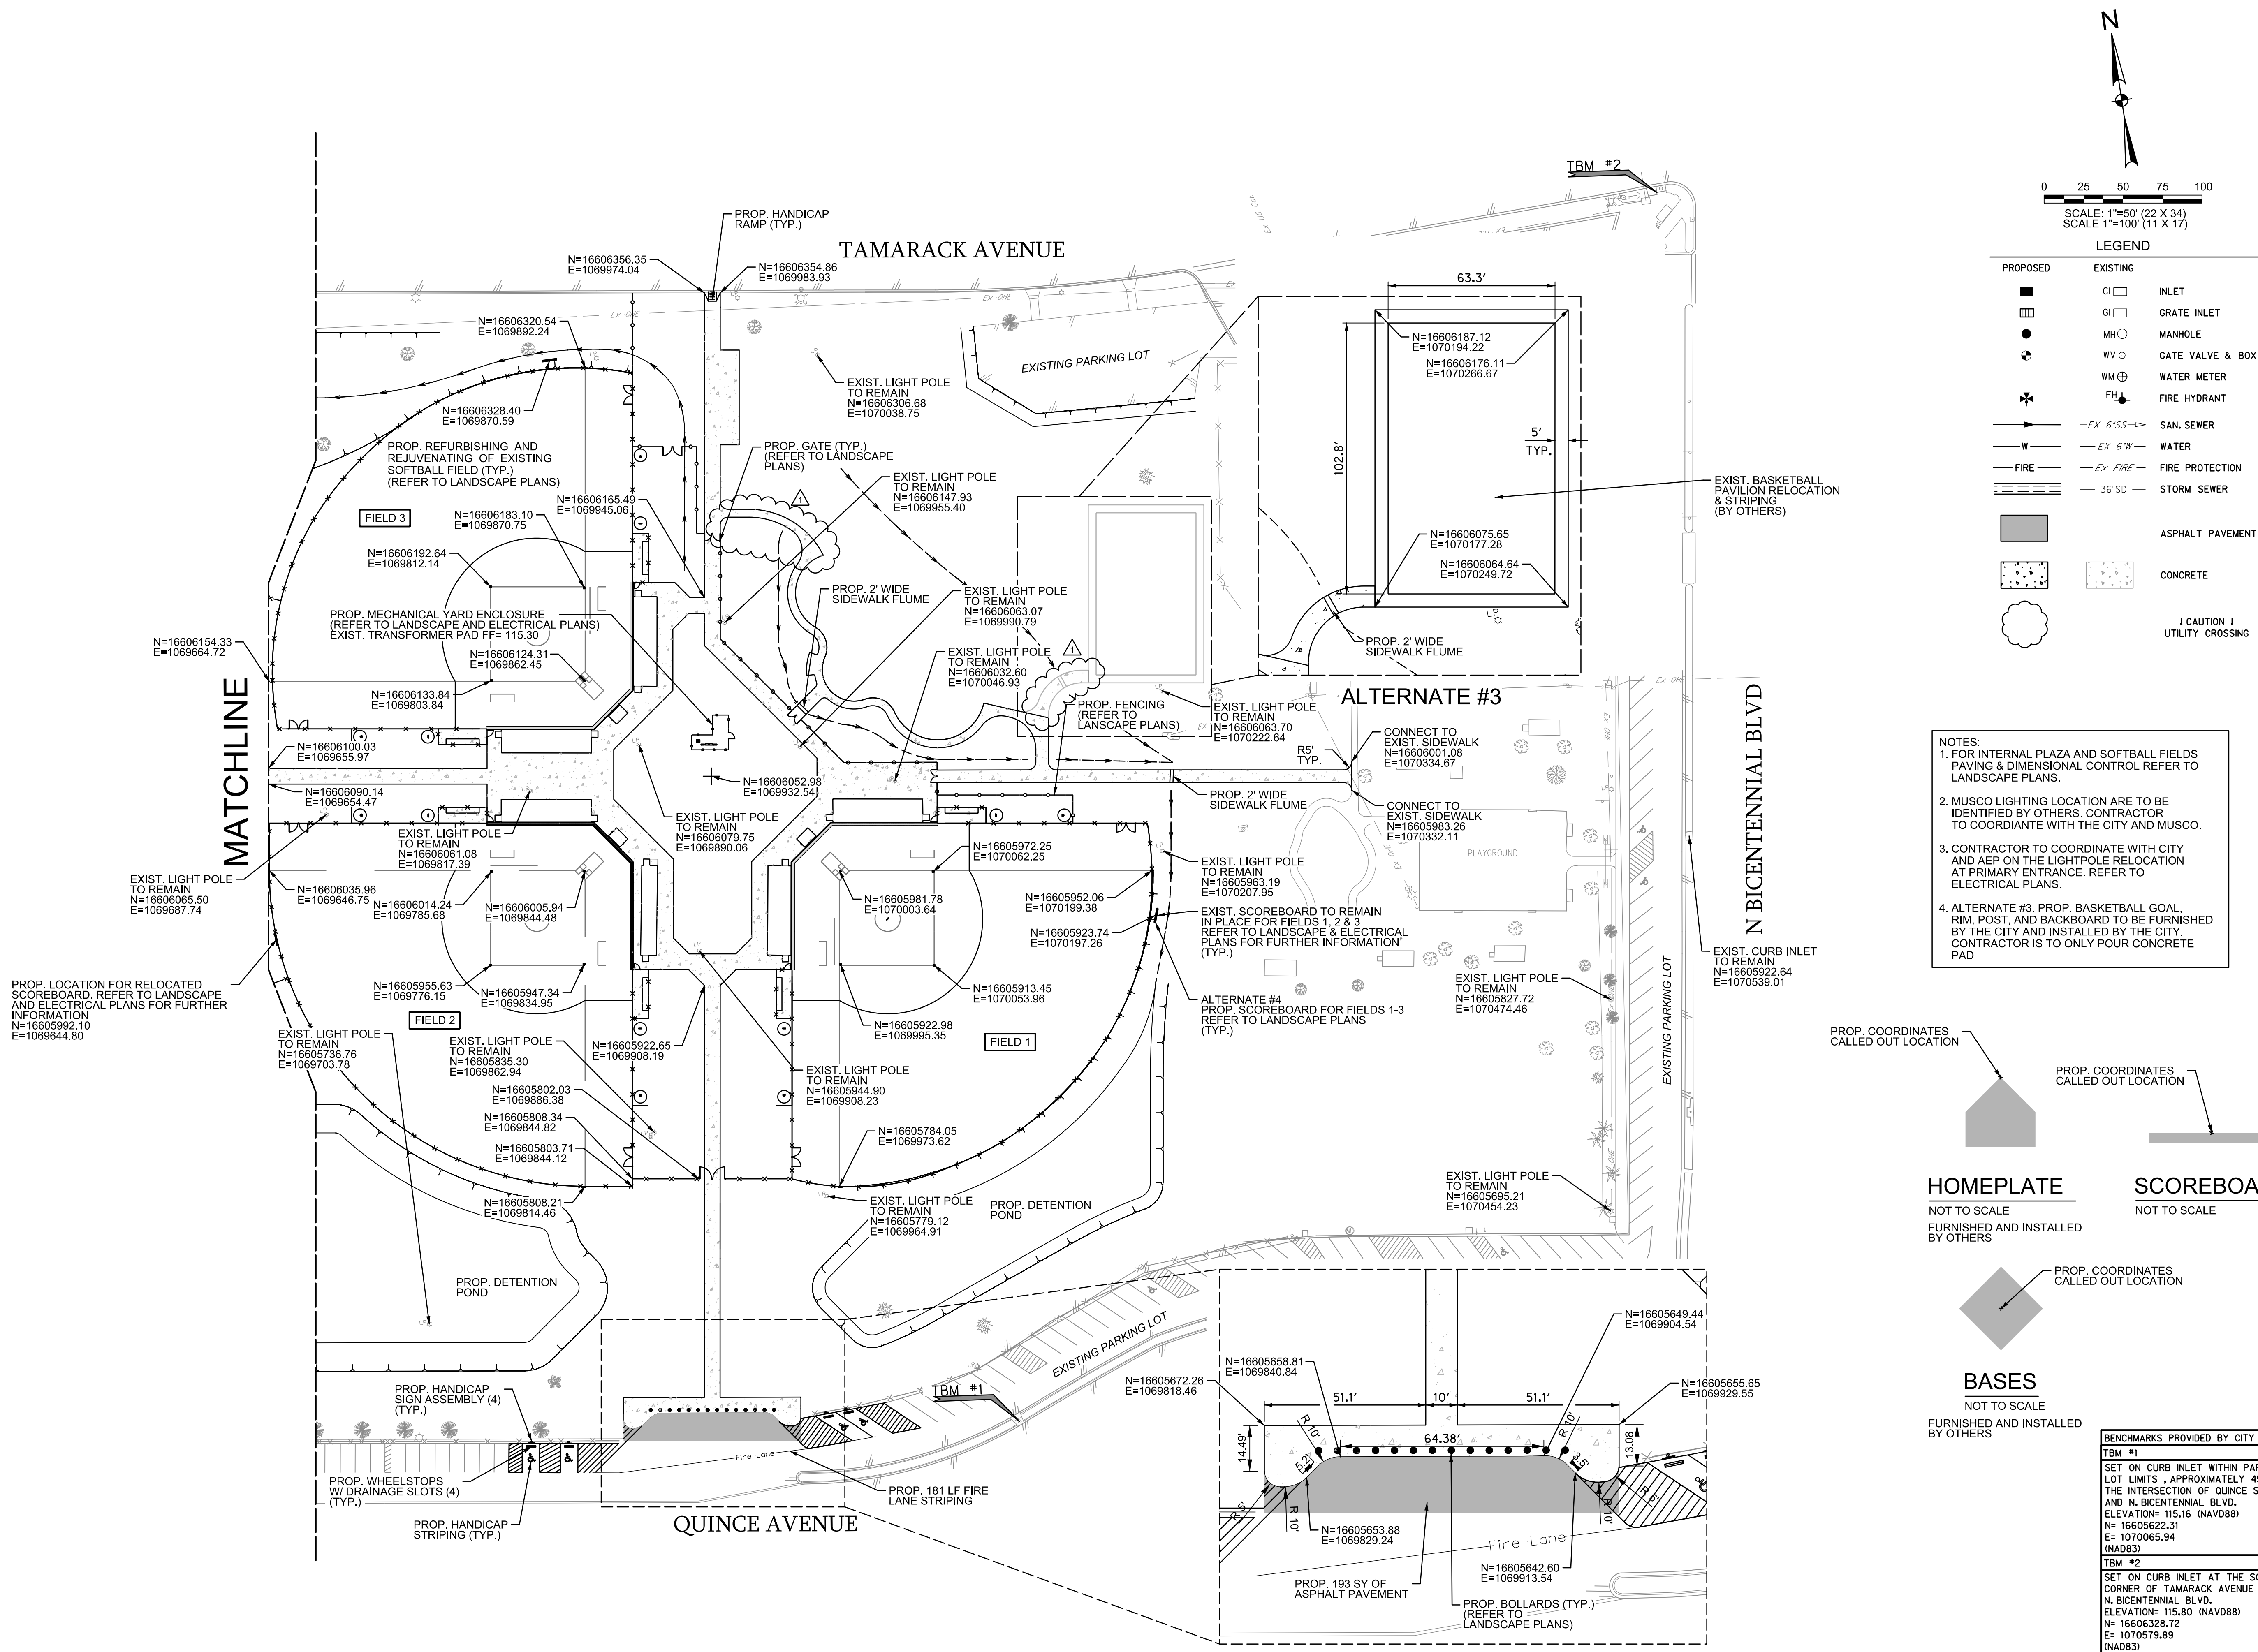

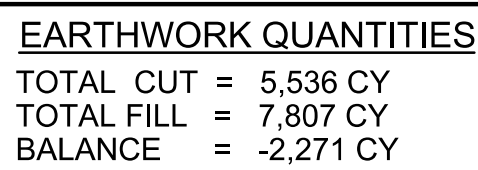


NOTES:


1. EARTHWORK QUANTITIES WERE CALCULATED FROM EXISTING GRADE TO PROPOSED GRADES, WITH THE ASSUMPTION THAT ALL EXISTING DIRTWORK WILL BE UTILIZED AS FILL MATERIAL. CONTRACTOR TO COORDINATE WITH THE CITY FOR DIRTWORK TREATMENT.
2. ALL QUANTITIES ARE IN PLACE AND NO SHRINKAGE OR SWELLING WAS TAKEN INTO ACCOUNT.
3. EARTHWORK QUANTITIES WERE CALCULATED FROM EXISTING GRADE TO PROPOSED GRADES, 4" OF TOPSOIL AT FIELDS AND 2" OF TOPSOIL AT DISTURBED AREA INCLUDED.
4. ALL PROP. SIDEWALK CROSS SLOPES SHALL NOT EXCEED 2%.
5. ALL PROP. SIDEWALK RUNNING SLOPES SHALL NOT EXCEED 5%.
6. ALL PROP. CURB RAMP SIDE SLOPES SHALL NOT EXCEED 2%.
7. ALL PROP. CURB RAMP RUNNING SLOPES SHALL NOT EXCEED 8.33%.

GEOTECH REPORT BY:
TERRACON CONSULTANTS, INC.
PROJECT NO. 88175150
DATE: SEPTEMBER 18, 2017

BENCHMARKS PROVIDED BY CITY OF McALLEN TBM #1 SET ON CURB INLET WITHIN PARK'S PARKING LOT LIMITS , APPROXIMATELY 450' WEST OF THE INTERSECTION OF QUINCE ST. N. BICENTENNIAL BLVD. ELEVATION= 115.16 (NAVD88) N= 16505522.31 E= 1070065.94 (NAED83)
TBM #2 SET ON CURB INLET AT THE SOUTHWEST CORNER OF TAMARACK AVENUE AND N. BICENTENNIAL BLVD. ELEVATION= 115.80 (NAVD88) N= 16606328.72 E= 1070579.89 (NAED83)

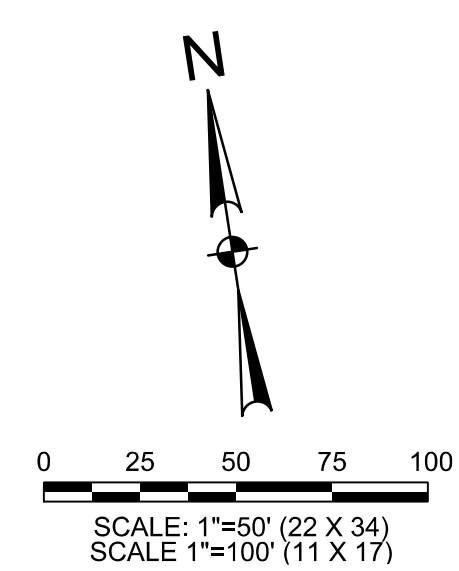

LEGEND		
PROPOSED	EXISTING	
—100.00—	--100.00--	CONTOUR
→		DRAINAGE FLOW ARROW
+ [FL100.00]		FLOW LINE
+ [TG100.00]		TOP OF GRATE
+ [100.00]		FINISHED GRADE

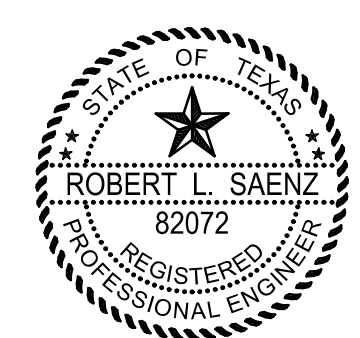[illegible]

The Seal appearing on this document was authorized by Robert L. Soenz, P.E. Number 82072 on July 26, 2018. Alteration of a sealed document without proper notification to the responsible engineer is an offense under the Texas Engineering Practice Act. The Record Copy of this drawing is on file at the offices of Haff Associates, Inc., 5000 W. Military Suite 100, McAllen, TX 78503. TP&E FIRM #F-312

Project No.:	33348.001
Issued:	July 2018
Drawn By:	FC
Checked By:	RM
Scale:	AS NOTED
Sheet Title	
GRADING PLAN	
C2.02	
Sheet Number	

CITY OF McALLEN
SOFTBALL FIELD FACILITIES
MUNICIPAL PARK
McALLEN, TEXAS




HALFF
5000 WEST MILITARY HWY., SUITE 100
MCALLEN, TX 78503
TEL (956) 664-0286
FAX (956) 664-0282
TRB# EBM #E 312

A circular professional engineer seal for the State of Texas. The outer ring contains the text "STATE OF TEXAS" at the top and "REGISTERED PROFESSIONAL ENGINEER" at the bottom, separated by stars. In the center is a five-pointed star. Below the star, the name "ROBERT L. SAENZ" is written in a bold, sans-serif font, and below that, the registration number "82072" is displayed.

Project No.:	33348.001
Issued:	July 2018
Drawn By:	FC
Checked By:	RM
Scale:	AS NOTED
Sheet Title	

C3.02

Sheet Number

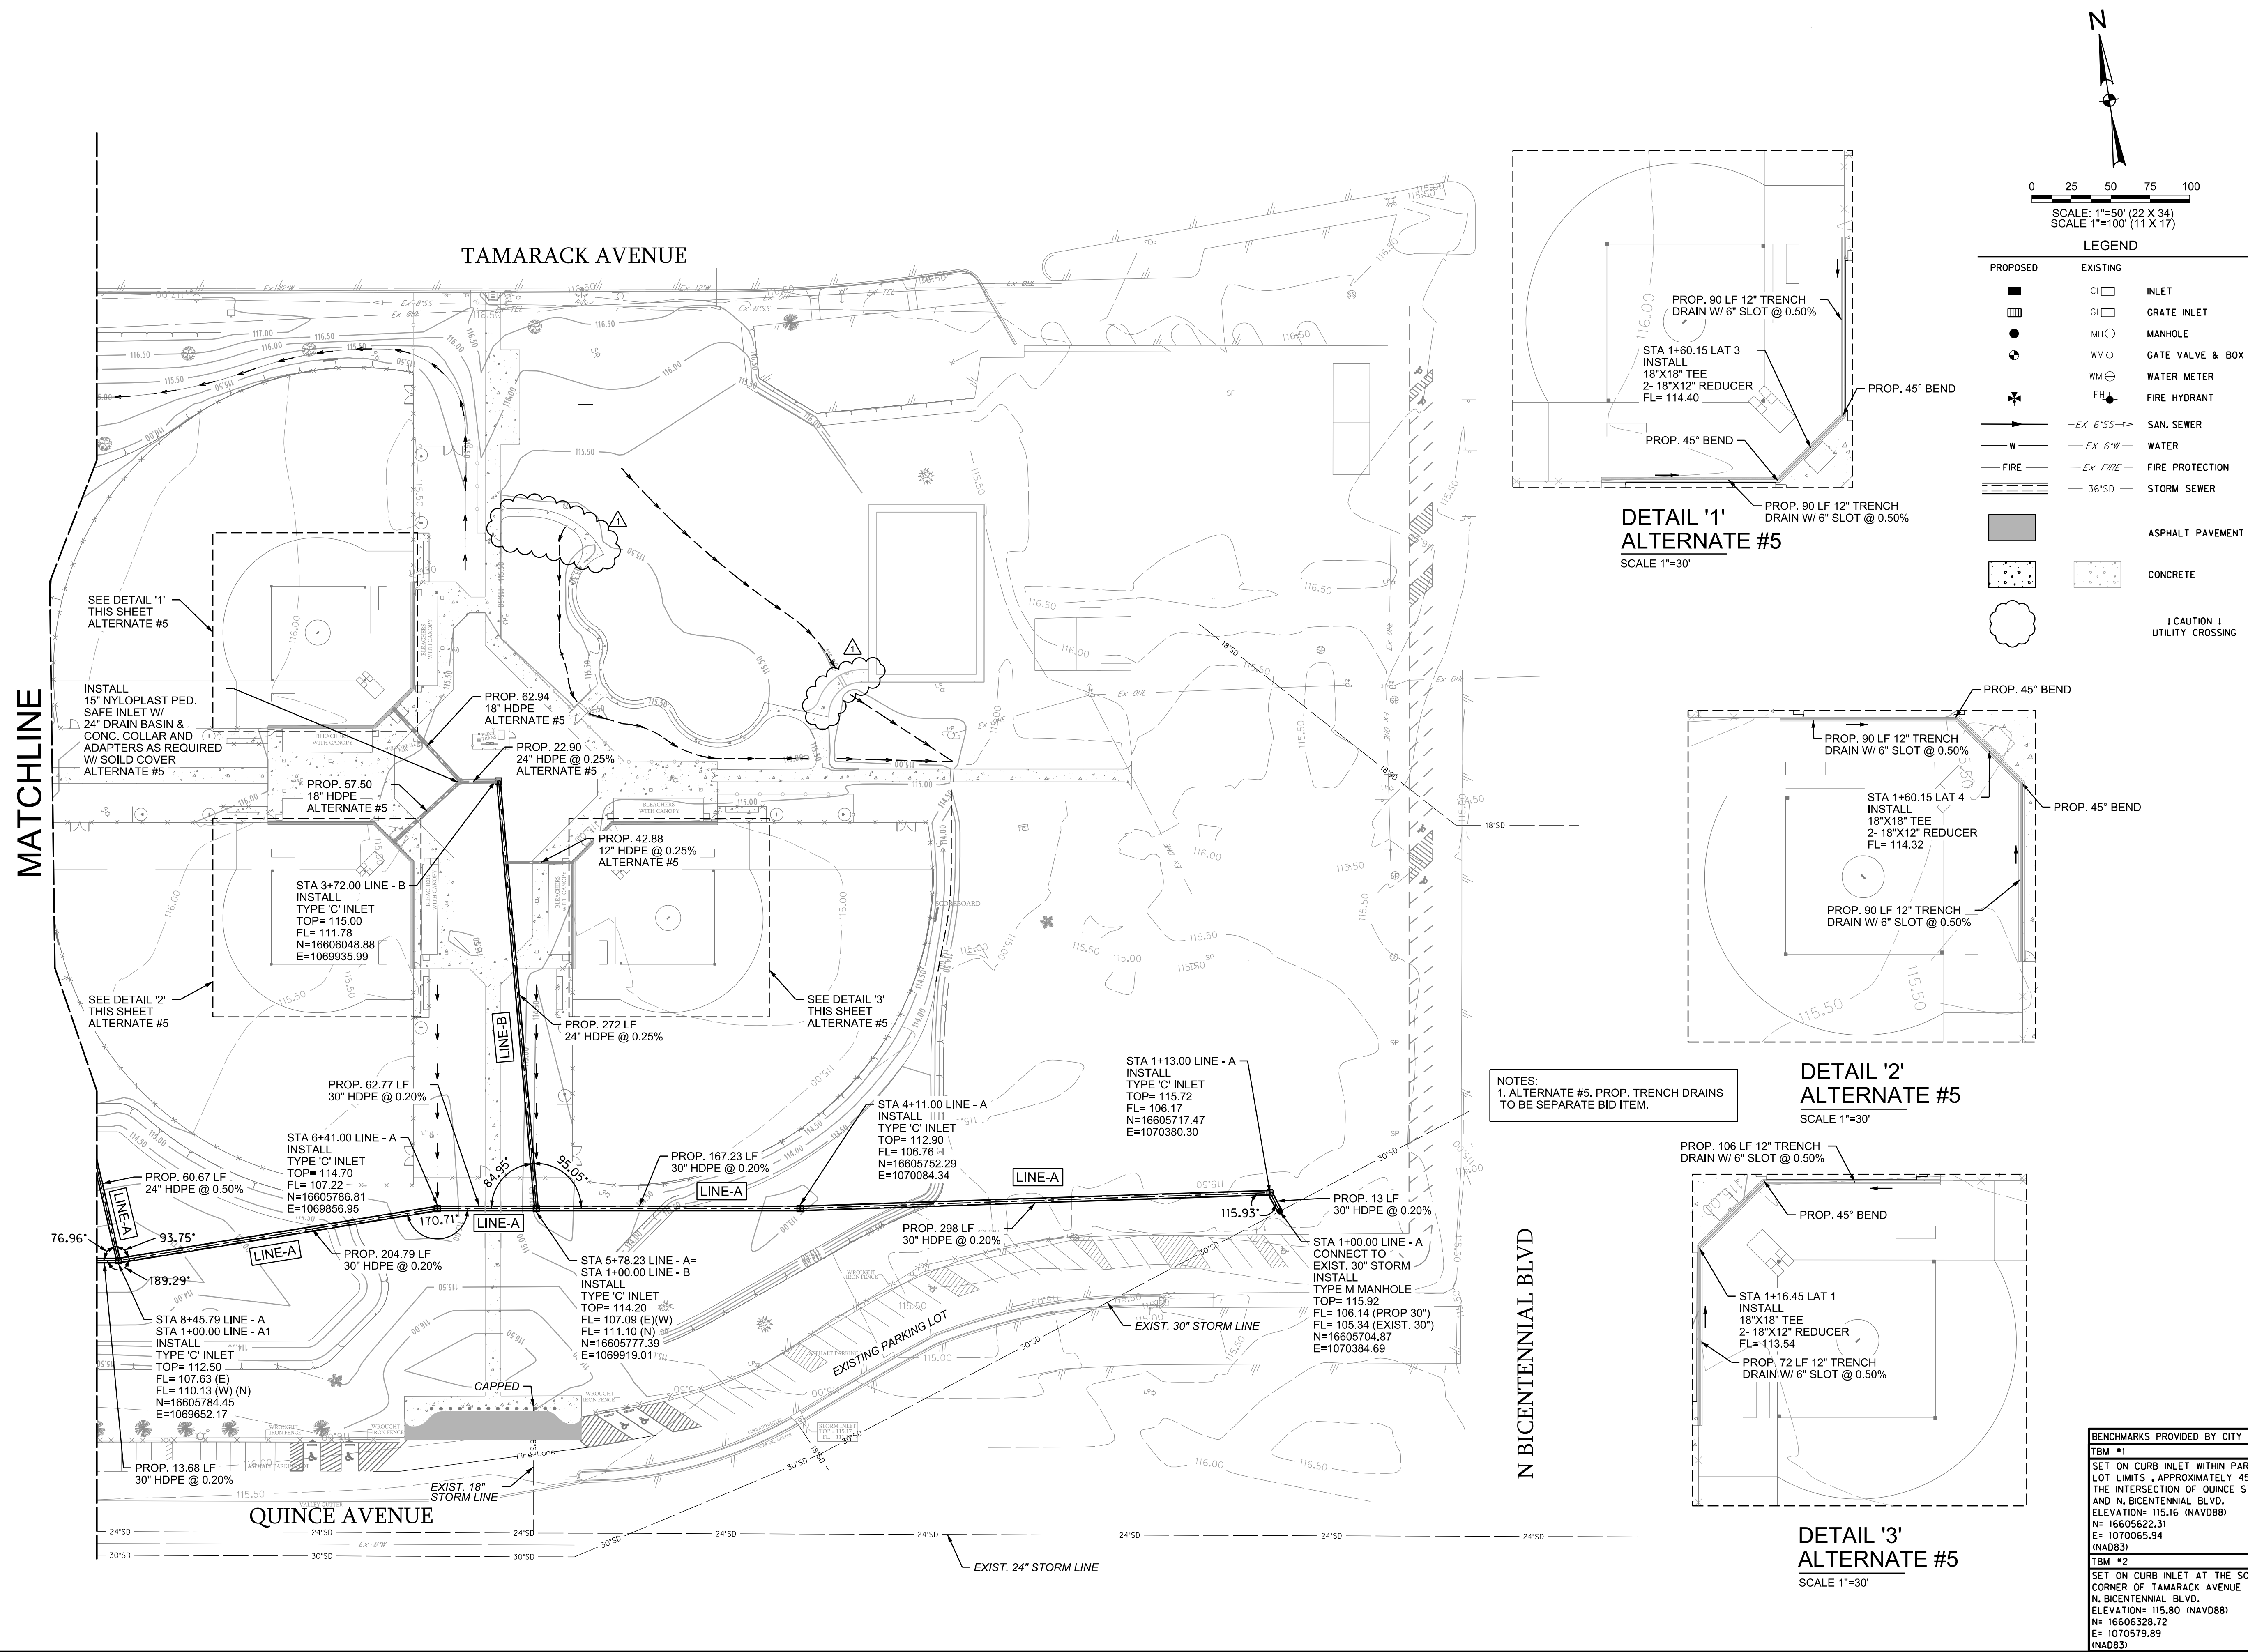

Sheet Number

SYMBOLS LEGEND			
X	X-XX"	X	X
X - DENOTES CEILING TYPE			EXHAUST AIR GRILLE
X-XX" - DENOTES CEILING HEIGHT			EXHAUST FAN, REF. MEP DRWGS
1 X 4 SURFACE MOUNTED LIGHT FIXTURE, REF. ELECTRICAL			EXIT SIGN
O			RECESSED CAN LIGHT, REF. ELECTRICAL

CEILING TYPE	
A	1/4" HARDIE SOFFIT PANEL CEILING, PAINTED
B	PRE-FINISHED METAL SOFFIT PANEL ON 1/2" DENS-GLASS SHEATHING BD.
C	OPEN TO STRUCTURE


ROOM FINISH SCHEDULE										
ROOM NO.	ROOM NAME	FLOOR	BASE	WALLS				CEILING FINISH	NOTES	ROOM NO.
				NORTH	EAST	WEST	SOUTH			
101	CONCESSION	CONC	NONE	PTD	PTD	PTD	PTD	PTD		101
102	UMPIRES	CONC	NONE	PTD	PTD	PTD	PTD	PTD		102
103	ALCOVE	CONC	NONE	PTD	PTD	PTD	PTD	PTD		103
104	MEN	CONC	NONE	PTD	PTD	PTD	PTD	PTD		104
105	JANITOR	CONC	NONE	PTD	PTD	PTD	PTD	PTD		105
106	ALCOVE	CONC	NONE	PTD	PTD	PTD	PTD	PTD		106
107	WOMEN	CONC	NONE	PTD	PTD	PTD	PTD	PTD		107
108	ALCOVE	CONC	NONE	PTD	PTD	PTD	PTD	PTD		108
109	STORAGE	CONC	NONE	PTD	PTD	PTD	PTD	PTD		109
110	FAMILY TOILET	CONC	NONE	PTD	PTD	PTD	PTD	PTD		110
111	FAMILY TOILET	CONC	NONE	PTD	PTD	PTD	PTD	PTD		111
112	MECH. / ELEC.	CONC	NONE	PTD	PTD	PTD	PTD	PTD		112

DOOR & FRAME TYPE			
1	EXTERIOR HOLLOW METAL INSULATED, PAINTED	2	EXTERIOR HOLLOW METAL INSULATED, PAINTED
A	EXTERIOR HOLLOW METAL FRAME, PAINTED	B	EXTERIOR HOLLOW METAL FRAME, PAINTED

ROOM FINISH NOTES	

DOOR SCHEDULE													
DOOR NO.	ROOM NAME	DOOR					FRAME					HRDWR SET	KEYED NOTES
101	CONCESSION	1	SINGLE	3'-0"	7'-0"	HM	PTD	A	3'-4"	7'-4"	HM	PTD	
102	UMPIRES	1	SINGLE	3'-0"	7'-0"	HM	PTD	A	3'-4"	7'-4"	HM	PTD	
103	JANITOR	1	SINGLE	3'-0"	7'-0"	HM	PTD	A	3'-4"	7'-4"	HM	PTD	
104	STORAGE	1	SINGLE	3'-0"	7'-0"	HM	PTD	A	3'-4"	7'-4"	HM	PTD	
105	FAMILY TOILET	1	SINGLE	3'-0"	7'-0"	HM	PTD	A	3'-4"	7'-4"	HM	PTD	
106	FAMILY TOILET	1	SINGLE	3'-0"	7'-0"	HM	PTD	A	3'-4"	7'-4"	HM	PTD	
107	MECH. / ELEC.	2	PAIR	3'-0"	7'-0"	HM	PTD	B	6'-4"	7'-4"	HM	PTD	


KEYED NOTES	
1	ALL HOLLOW METAL DOORS AND FRAMES TO BE WELDED AND PAINTED, REF. SPECS. GRIND ALL EXPOSED WELDS; SMOOTH PRIOR TO APPLYING FINAL FINISH.
2	FIELD VERIFY SIZE OF ALL EXISTING OPENINGS PRIOR TO ORDERING FRAMES.
3	REFER TO WALL TYPES LEGEND AND SPECIFICATIONS FOR SPECIFIC CONSTRUCTION MATERIALS USED IN WALL CONSTRUCTION
4	ROUGH OPENING OF FRAME SHALL BE 4" MIN FROM ADJACENT WALL U.N.O.

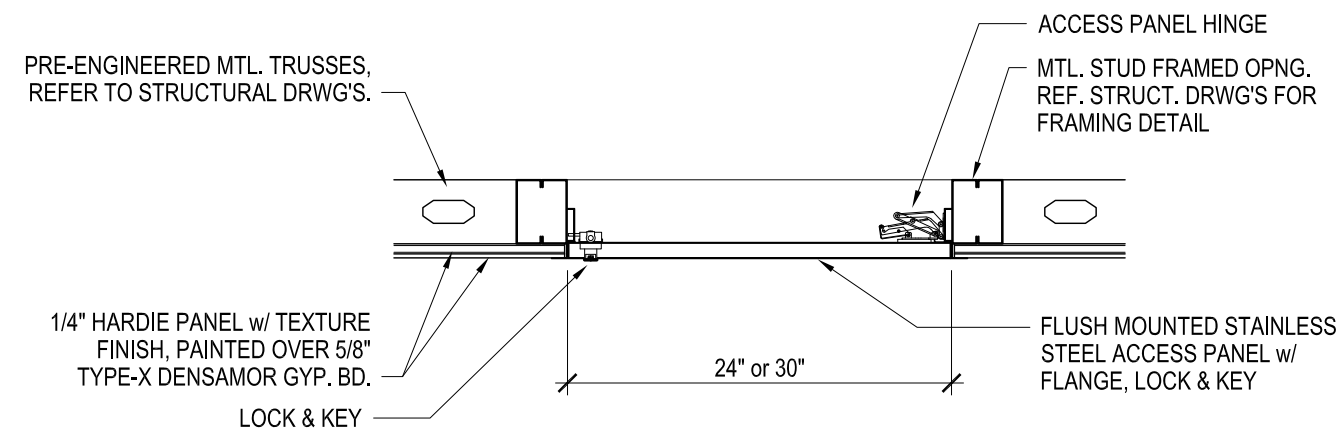


ATTIC ACCESS PANEL - SECTION 3
SCALE: 1" = 1'-0"

FLOOR PLAN WALL LEGEND	
	REINFORCED CMU - SEE STRUCTURAL - FINISHED AS SCHEDULED - BULLNOSE AT ALL OUTSIDE CORNERS
8	8" CMU - CAST STONE WAINSCOT w/ CAST STONE CAP & 8" CMU SPLIT-FACE ABOVE ON EXTERIOR FACE. SEALED & PAINTED ON INTERIOR FACE.
8A	8" CMU - CAST STONE WAINSCOT w/ CAST STONE CAP & 8" CMU SPLIT-FACE ABOVE ON EXTERIOR FACE.
8B	8" CMU - SEALED & PAINTED ON BOTH SIDES
8C	8" CMU - SEALED & PAINTED ONE SIDE ONLY
8D	8" CMU - CAST STONE WAINSCOT w/ CAST STONE CAP & 8" CMU SPLIT-FACE ABOVE ON EXTERIOR FACE. 5/8" DENSARMOR GYP. BD. (T.F.T. & PTD.) ON Z-FURRING STRIPS & 1 1/2" THERMAX SHEATHING RIGID INSULATION BD. ON INTERIOR FACE, REF. WALL SECTION: 3 / A4.3 SIM.
8E	8" CMU - 5/8" DENSARMOR GYP. BD. (T.F.T. & PTD.) ON Z-FURRING STRIPS & 1 1/2" THERMAX SHEATHING RIGID INSULATION BD. SEALED & PAINTED OTHER SIDE, REF. WALL SECTION: 3 / A4.3
	RANDOM PATTERN ASHLAR CAST STONE WAINSCOT

REFLECTED CEILING PLAN KEY NOTES	
1	30" x 30" S.S. ACCESS PANEL w/ FLANGE & LOCK, REF. SECTION: 3 / A2.1
2	24" x 24" S.S. ACCESS PANEL w/ FLANGE & LOCK, REF. SECTION: 3 / A2.1
3	EXHAUST FAN IN ATTIC SPACE, REF. MEP DRWGS
4	SUPPLY FAN IN ATTIC SPACE, REF. MEP DRWGS
5	SOFFIT MOUNTED AIR INTAKE GRILLE, REF. MEP DRWGS
6	SURFACE MOUNTED SUPPLY AIR DIFFUSER, REF. MEP DRWGS
7	OUTLINE CUPOLA WALL ABOVE, REF. EXTERIOR ELEVATIONS
8	EXHAUST DUCT UP TOWARDS CUPOLA ABOVE, REF. MEP DRWGS
9	SURFACE MOUNTED RETURN GRILLE, REF. MEP DRWGS
10	EXHAUST DUCT ROUTE IN ATTIC, REF. MEP DRWGS
11	A/C CONDENSING UNIT WALL MOUNTED BELOW SOFFIT, REF. MEP DRWGS
12	A/C SPLIT-SYSTEM UNIT WALL MOUNTED BELOW CEILING, REF. MEP DRWGS
13	CMU HEADER AT OPENING, PAINTED
14	PRE-FINISHED METAL GUTTER, REF. WALL SECTIONS
15	SURFACE MOUNTED LIGHT FIXTURE, REF. ELECTRICAL LIGHTING PLAN
16	RECESS CAN LIGHT FIXTURE, REF. ELECTRICAL LIGHTING PLAN

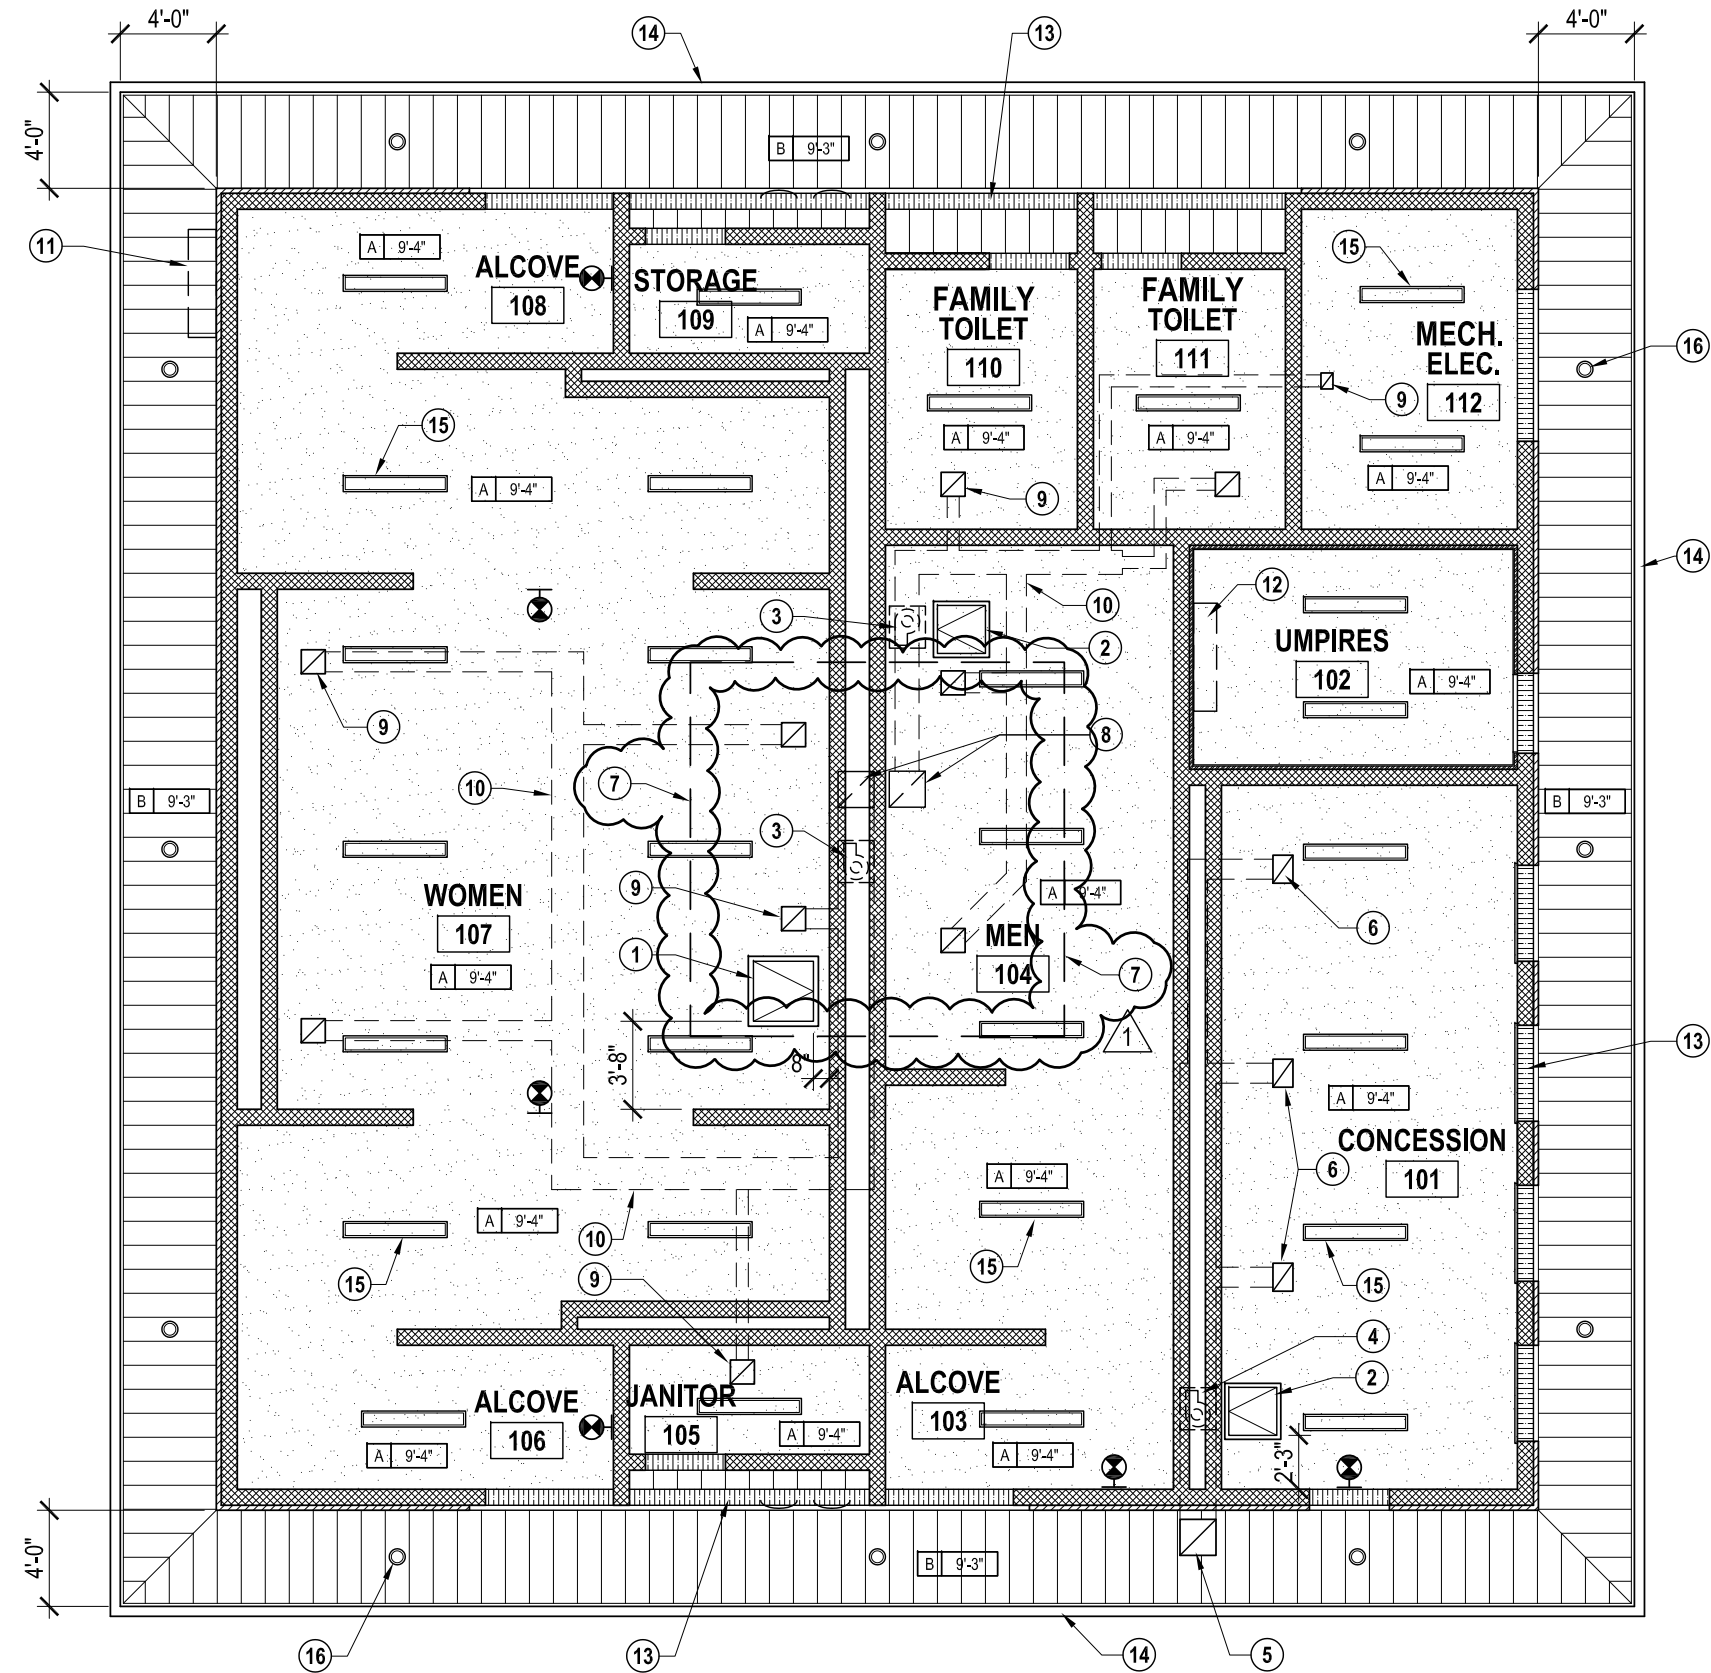

REFLECTED CEILING PLAN 2
SCALE: 1/8" = 1'-0"

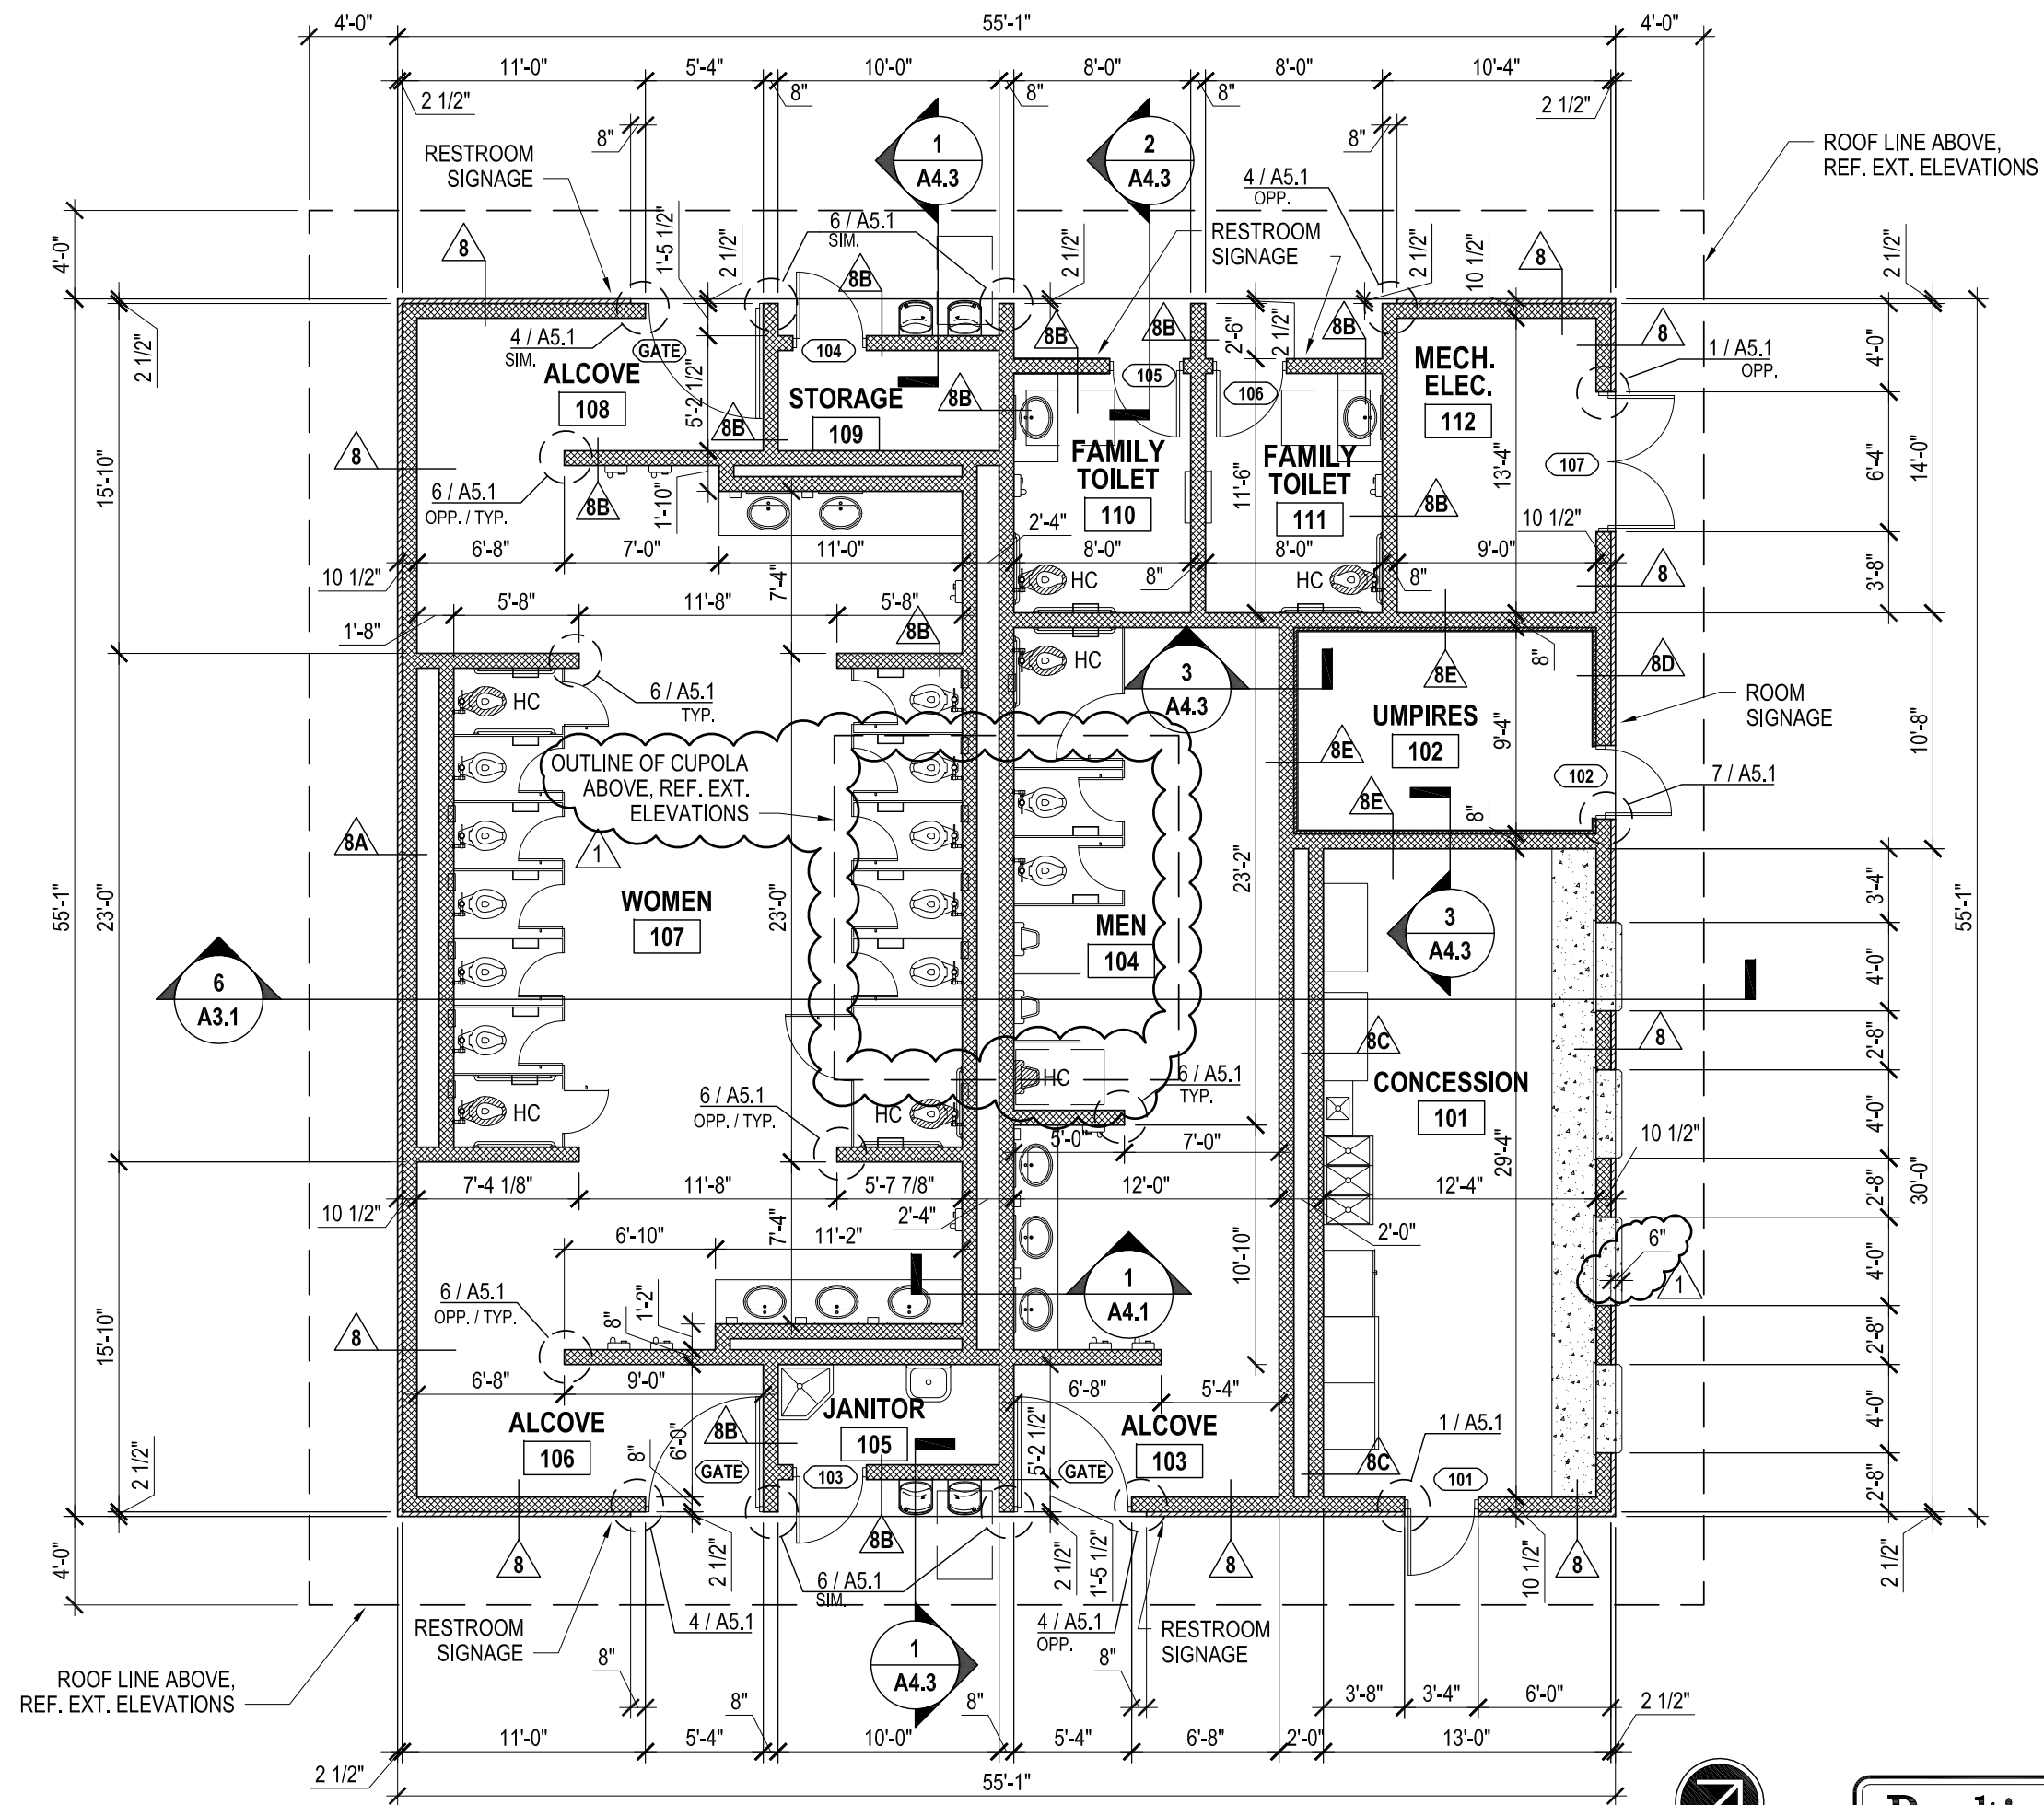

FLOOR PLAN 1
SCALE: 1/8" = 1'-0"



CITY OF McALLEN
SOFTBALL FIELD FACILITIES
MUNICIPAL PARK
McALLEN, TEXAS


McALLEN Parks & Recreation

HALFF
5000 WEST MILITARY HWY, SUITE 100
MCALLEN, TEXAS 78501
TEL (956) 664-0286
FAX (956) 664-0282
TDC FIRM # 512

Revision	No.	Date	Description
	1	7-26-18	ADDED CUPOLA ABOVE


100%
CONSTRUCTION
DOCUMENTS

Project No.:	33348.001
Issued:	07/11/2018
Drawn By:	G.Q.
Checked By:	B.S.
Scale:	AS SHOWN
Sheet Title	FLOOR PLAN & REFLECTED CLG. PLAN
Sheet Number	A2.1

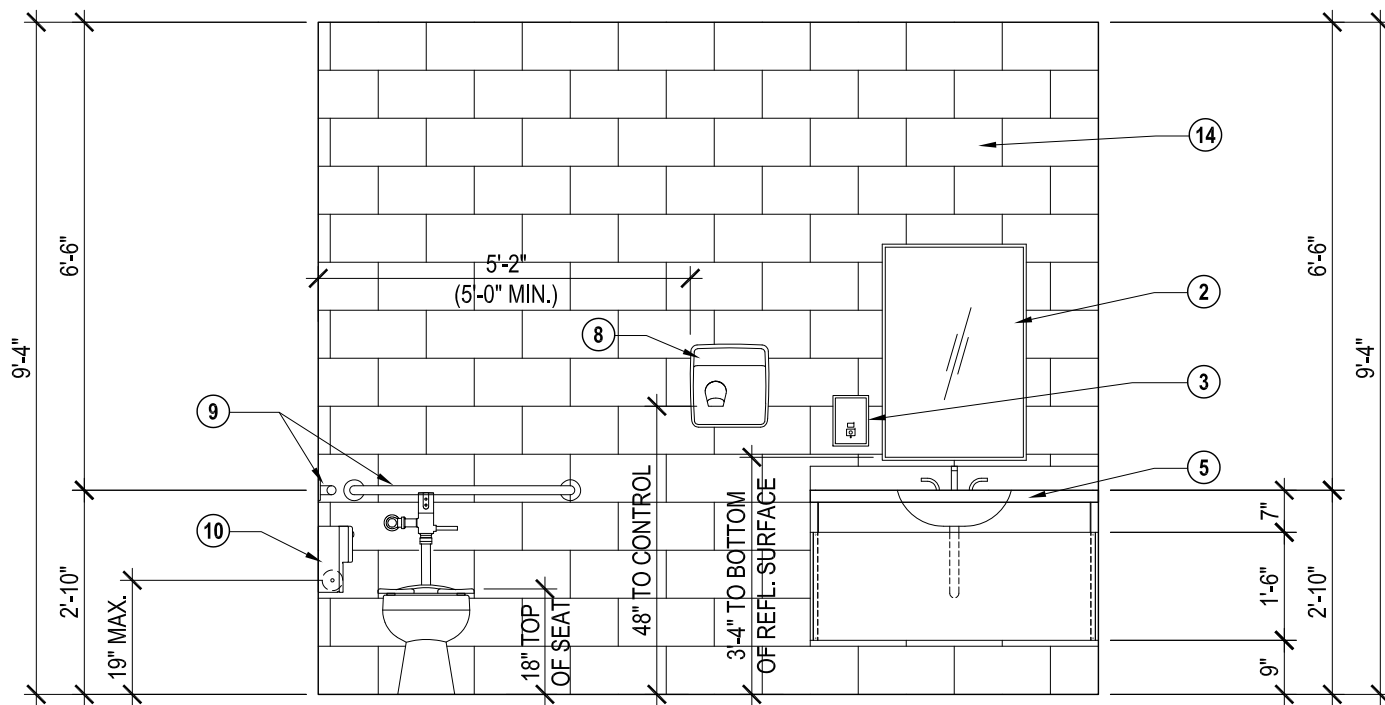


FAMILY TOILETS - 110 & 111 (OPP.)
INTERIOR ELEVATION
SCALE: 3/8" = 1'-0"

4

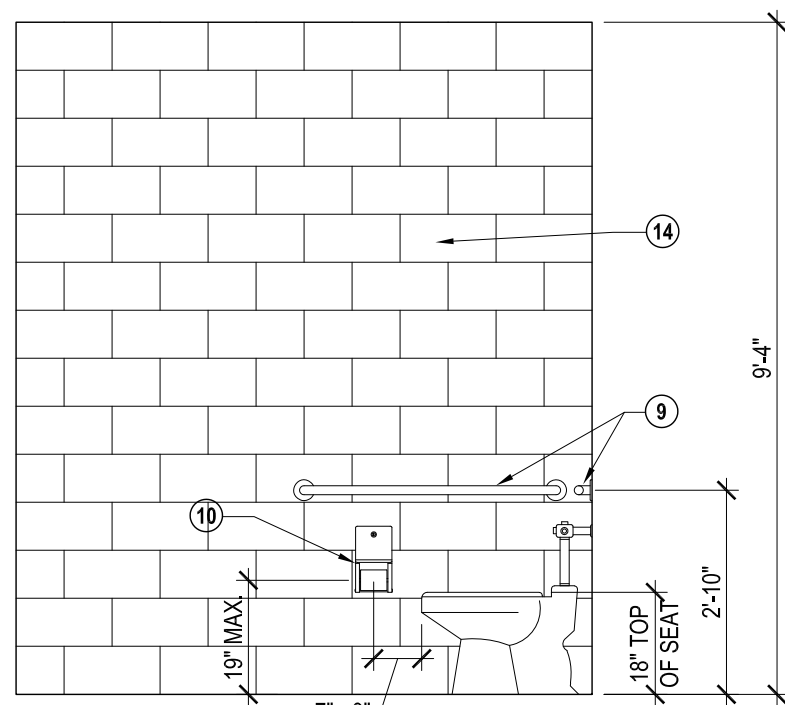


FAMILY TOILETS - 110 & 111 (OPP.)
INTERIOR ELEVATION
SCALE: 3/8" = 1'-0"

3

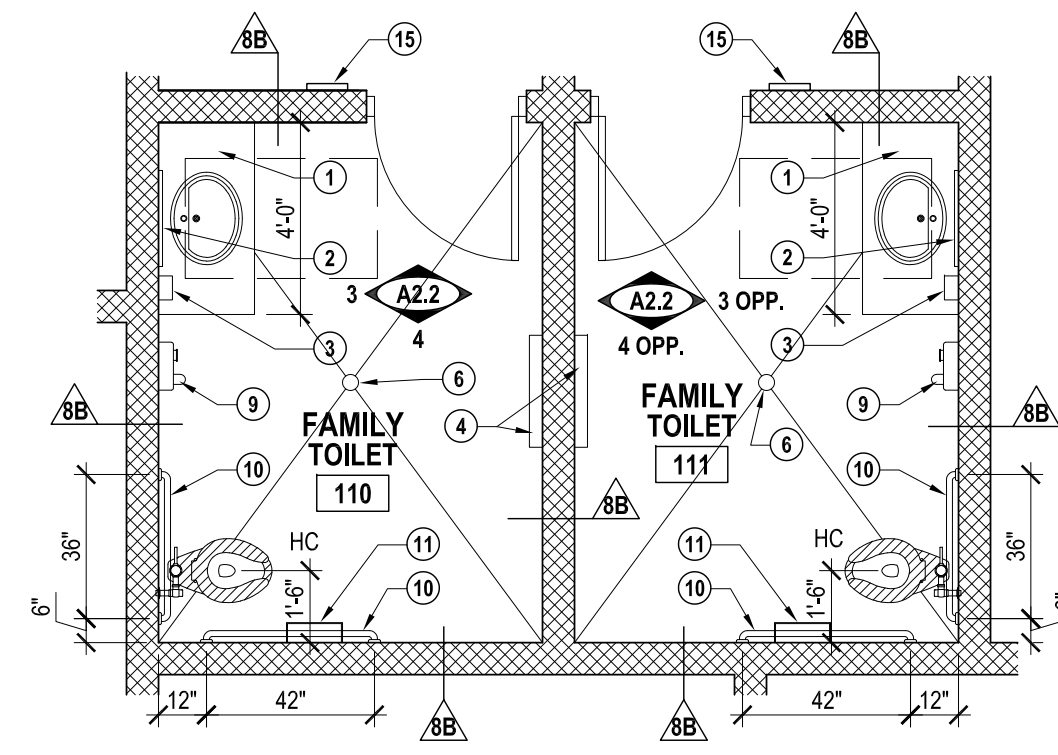


ENLARGED FAMILY TOILET PLAN
SCALE: 1/4" = 1'-0"

2

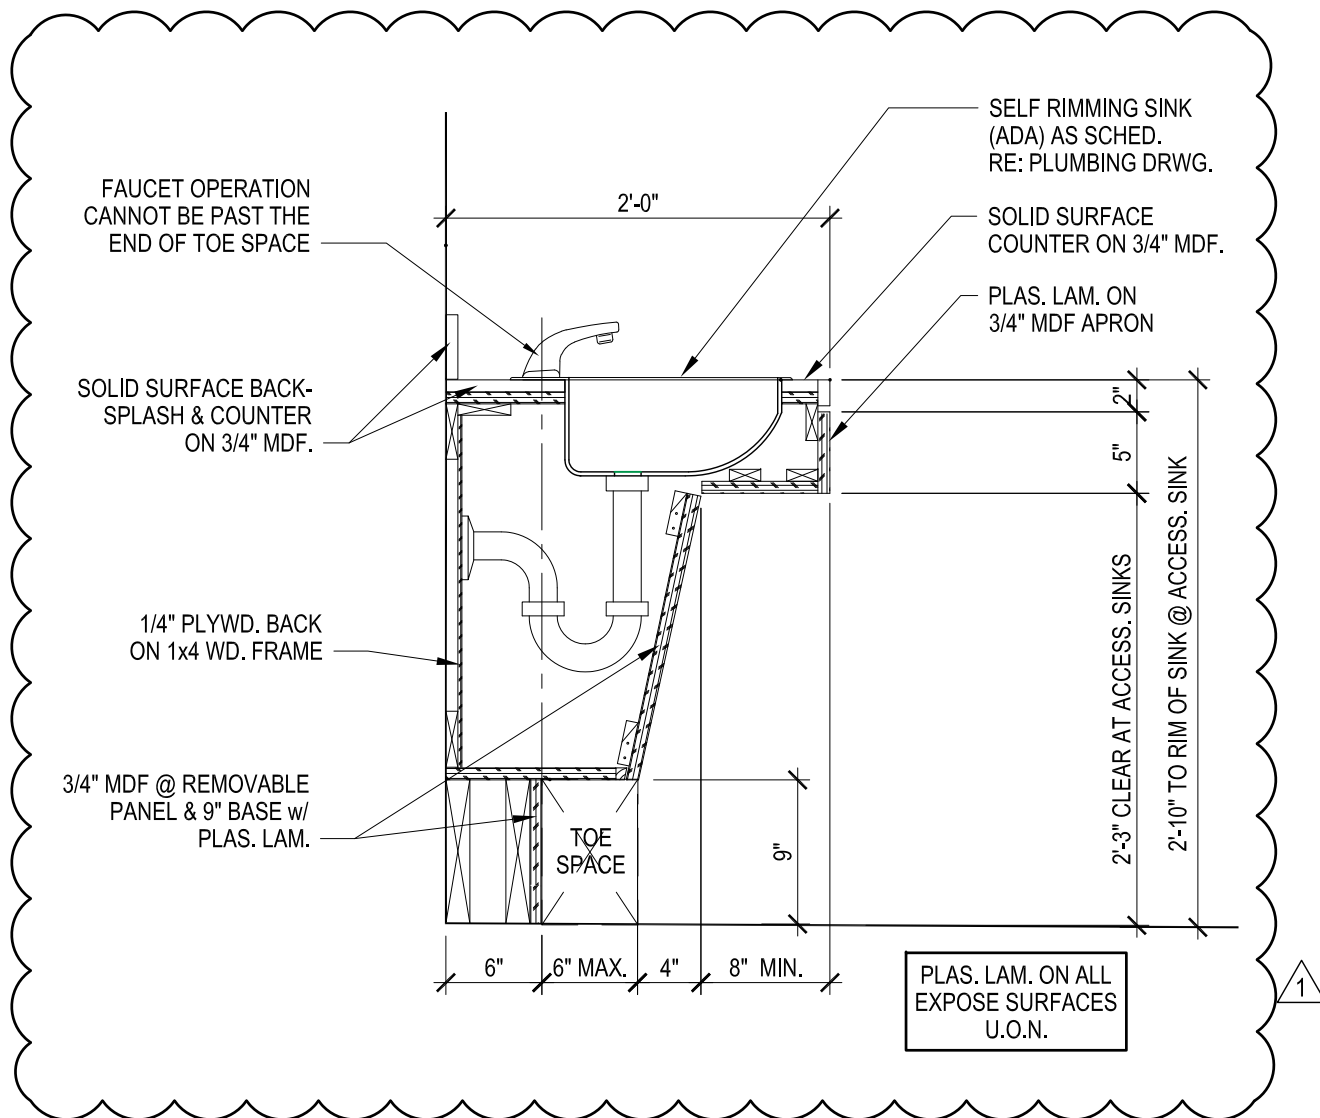

TYP. MILLWORK COUNTER @ RESTROOMS
SCALE: 1" = 1'-0"

5

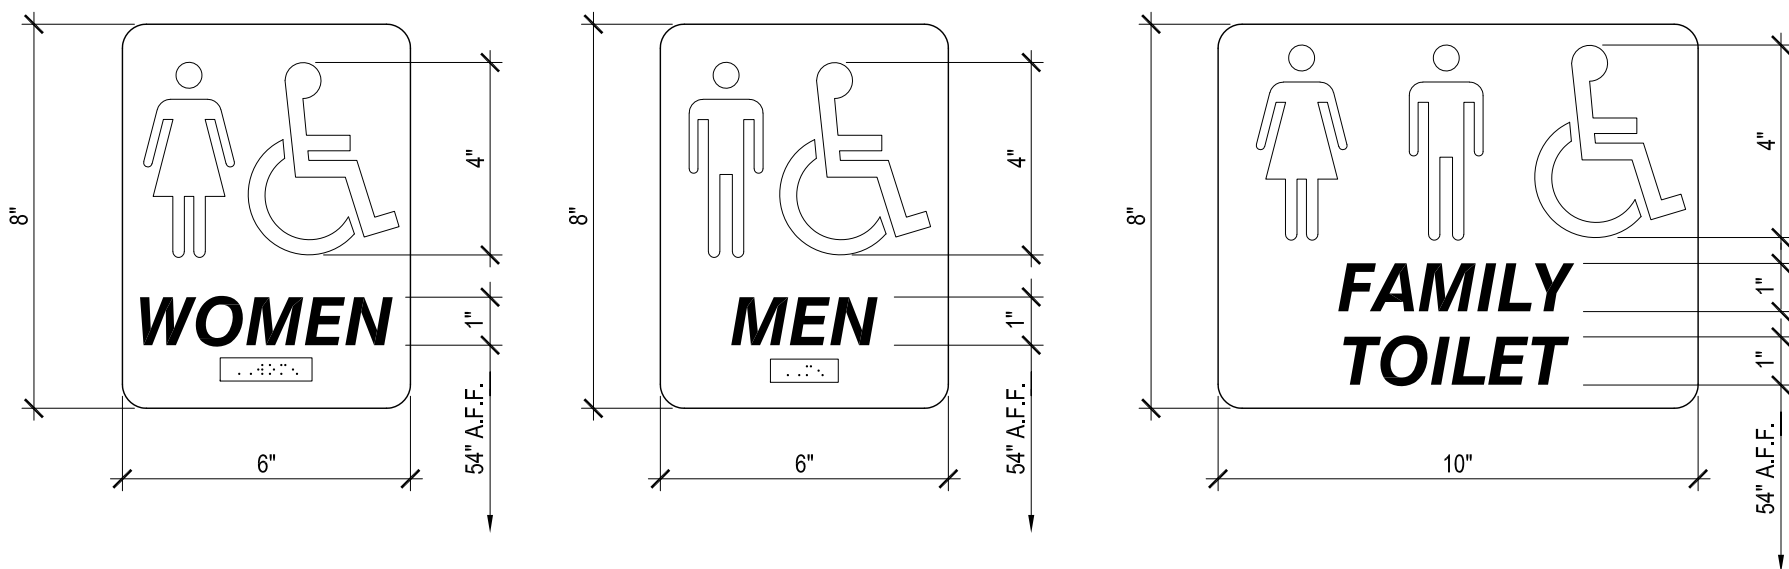


ADA COMPLIANCE RESTROOM SIGNAGE
NO SCALE:

6

- FLOOR PLAN KEY NOTES**
- SOLID SURFACE COUNTERTOP, NOSING & 4" BACK-SPLASH AS SPECIFIED REF. TYP. MILLWORK SECTION: 5 / A2.2
 - WALL-MOUNTED MIRROR - BOBRICK B-165 2436 OR EQUAL - PROVIDE BOBRICK B-293 2436 AT HC DESIGNATED LAVATORY
 - WALL-MOUNTED SOAP DISPENSER - BOBRICK B-40 OR EQUAL
 - WALL-MOUNTED BABY CHANGING STATION - KOALA KARE KB101-01 OR EQUAL
 - SELF RIMMING HAND SINK, REFER TO MEP
 - FLOOR DRAIN, REFER TO MEP
 - OVERHEAD BRACED SOLID PLASTIC TOILET PARTITIONS - BOBRICK SIERRA SERIES OR EQUAL
 - WALL HUNG SOLID PLASTIC URINAL SCREEN - BOBRICK SIERRA SERIES OR EQUAL
 - ADA COMPLIANT WALL-MOUNTED HAND DRYER - BOBRICK B-7128 OR EQUAL
 - ADA COMPLIANT GRAB BARS - BOBRICK B-8806 x 36 OR EQUAL BOBRICK B-8806 x 42 OR EQUAL
 - TOILET PAPER DISPENSER - BOBRICK B-2888 OR EQUAL
 - RECESSED SANITARY NAPKIN DISPOSAL - BOBRICK B-353 OR EQUAL
 - HAT AND COAT HOOK - BOBRICK B-682 OR EQUAL - MOUNT AT 48" A.F.F. MAX
 - ALL INTERIOR SMOOTH-FACED CMU WALLS TO BE SEALED & PAINTED
 - ADA COMPLIANCE RESTROOM SIGNAGE
 - 30" x 30" STAINLESS STEEL ATTIC ACCESS PANEL w/ FLANGE & LOCK, REF. SECTION: 3 / A2.1
 - 24" x 24" STAINLESS STEEL ATTIC ACCESS PANEL w/ FLANGE & LOCK, REF. SECTION: 3 / A2.1

- FLOOR PLAN WALL LEGEND**
- REINFORCED CMU - SEE STRUCTURAL - FINISHED AS SCHEDULED - BULLNOSE AT ALL OUTSIDE CORNERS
 - 8" CMU - CAST STONE WAINSCOT w/ CAST STONE CAP & 8" CMU SPLIT-FACE ABOVE ON EXTERIOR FACE. SEALED & PAINTED ON INTERIOR FACE.
 - 8" CMU - CAST STONE WAINSCOT w/ CAST STONE CAP & 8" CMU SPLIT-FACE ABOVE ON EXTERIOR FACE.
 - 8" CMU - SEALED & PAINTED ON BOTH SIDES
 - 8" CMU - SEALED & PAINTED ONE SIDE ONLY
 - 8" CMU - CAST STONE WAINSCOT w/ CAST STONE CAP & 8" CMU SPLIT-FACE ABOVE ON EXTERIOR FACE. 5/8" DENSARMOR GYP. BD. (T.F.T. & PTD.) ON Z-FURRING STRIPS & 1 1/2" THERMAX SHEATHING RIGID INSULATION BD. ON INTERIOR FACE. REF. WALL SECTION: 3 / A4.3 SIM.
 - 8" CMU - 5/8" DENSARMOR GYP. BD. (T.F.T. & PTD.) ON Z-FURRING STRIPS & 1 1/2" THERMAX SHEATHING RIGID INSULATION BD. SEALED & PAINTED OTHER SIDE. REF. WALL SECTION: 3 / A4.3
 - RANDOM PATTERN ASHLAR CAST STONE WAINSCOT

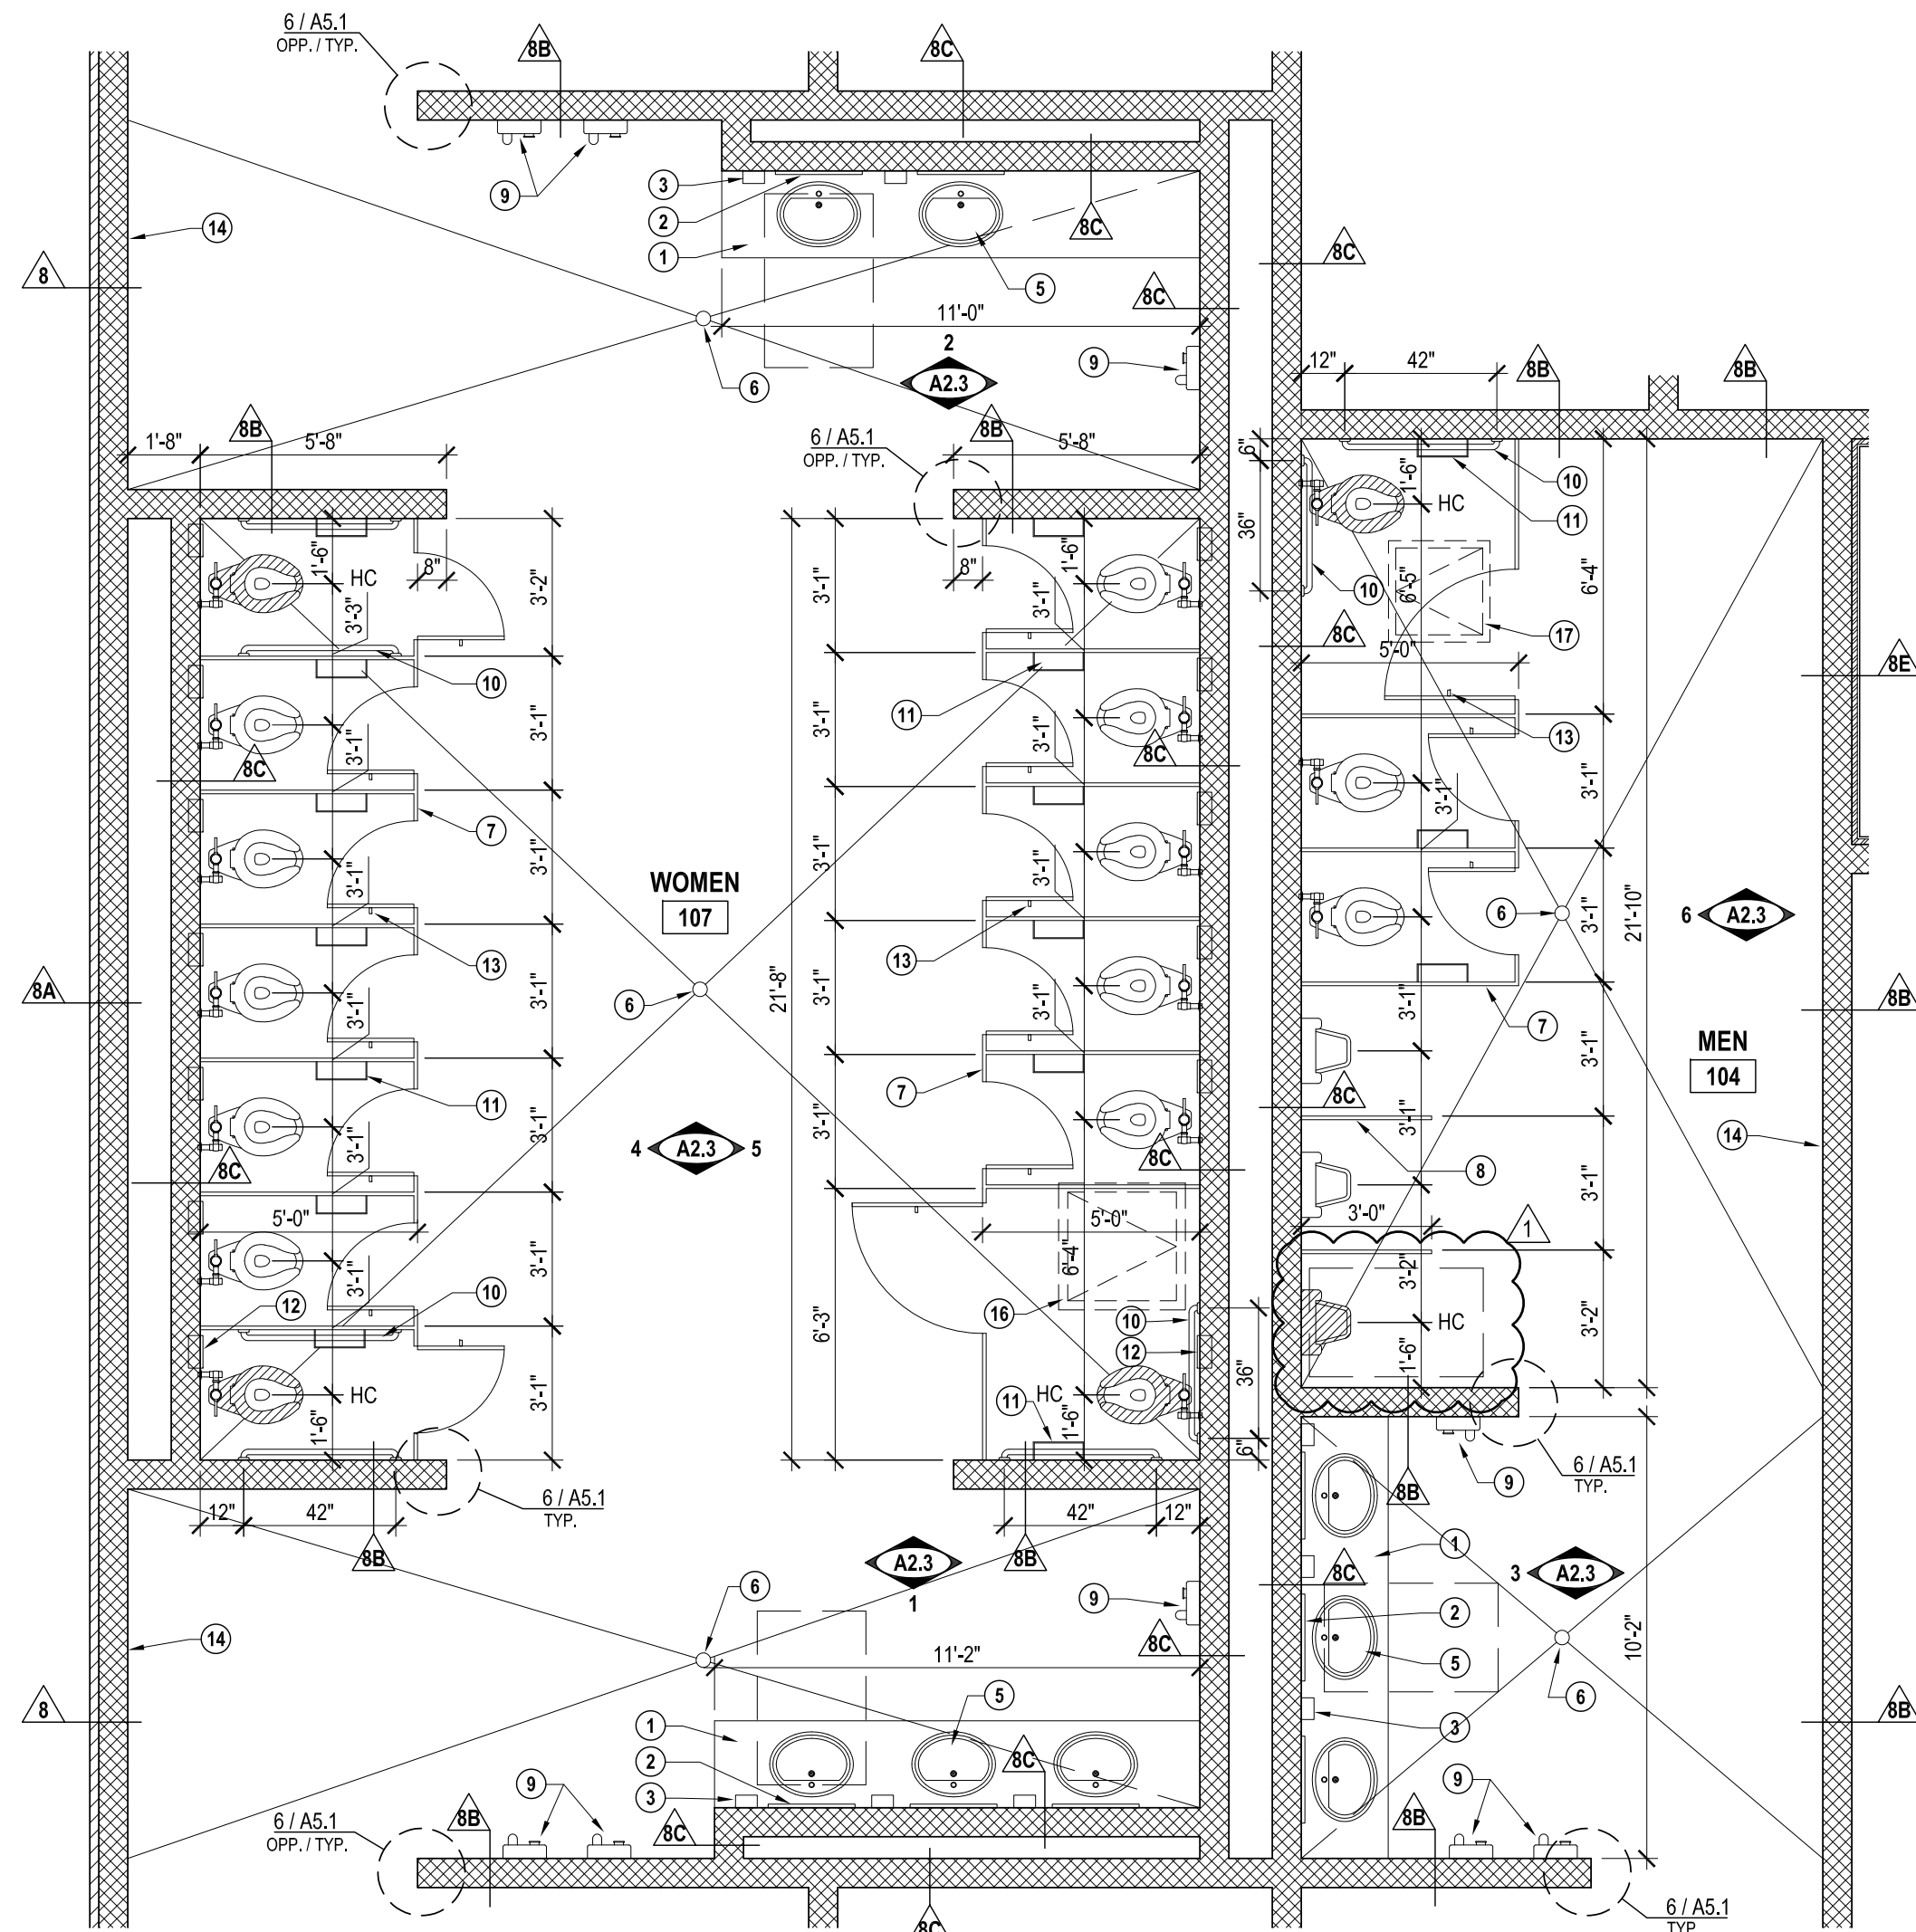

ENLARGED RESTROOM PLAN
SCALE: 1/4" = 1'-0"


1



CITY OF McALLEN
SOFTBALL FIELD FACILITIES
MUNICIPAL PARK
McALLEN, TEXAS



Revision	No.	Date	Description
	1	7-26-18	ADDED ADA NOTES & DIMENSIONS

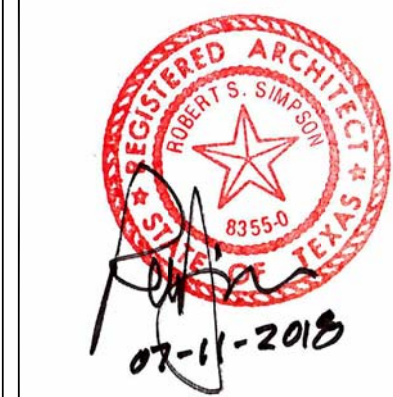


100%
CONSTRUCTION
DOCUMENTS

Project No.:	33348.001
Issued:	07/11/2018
Drawn By:	G.Q.
Checked By:	B.S.
Scale:	AS SHOWN
Sheet Title	


ENLARGED PLANS

A2.2
Sheet Number

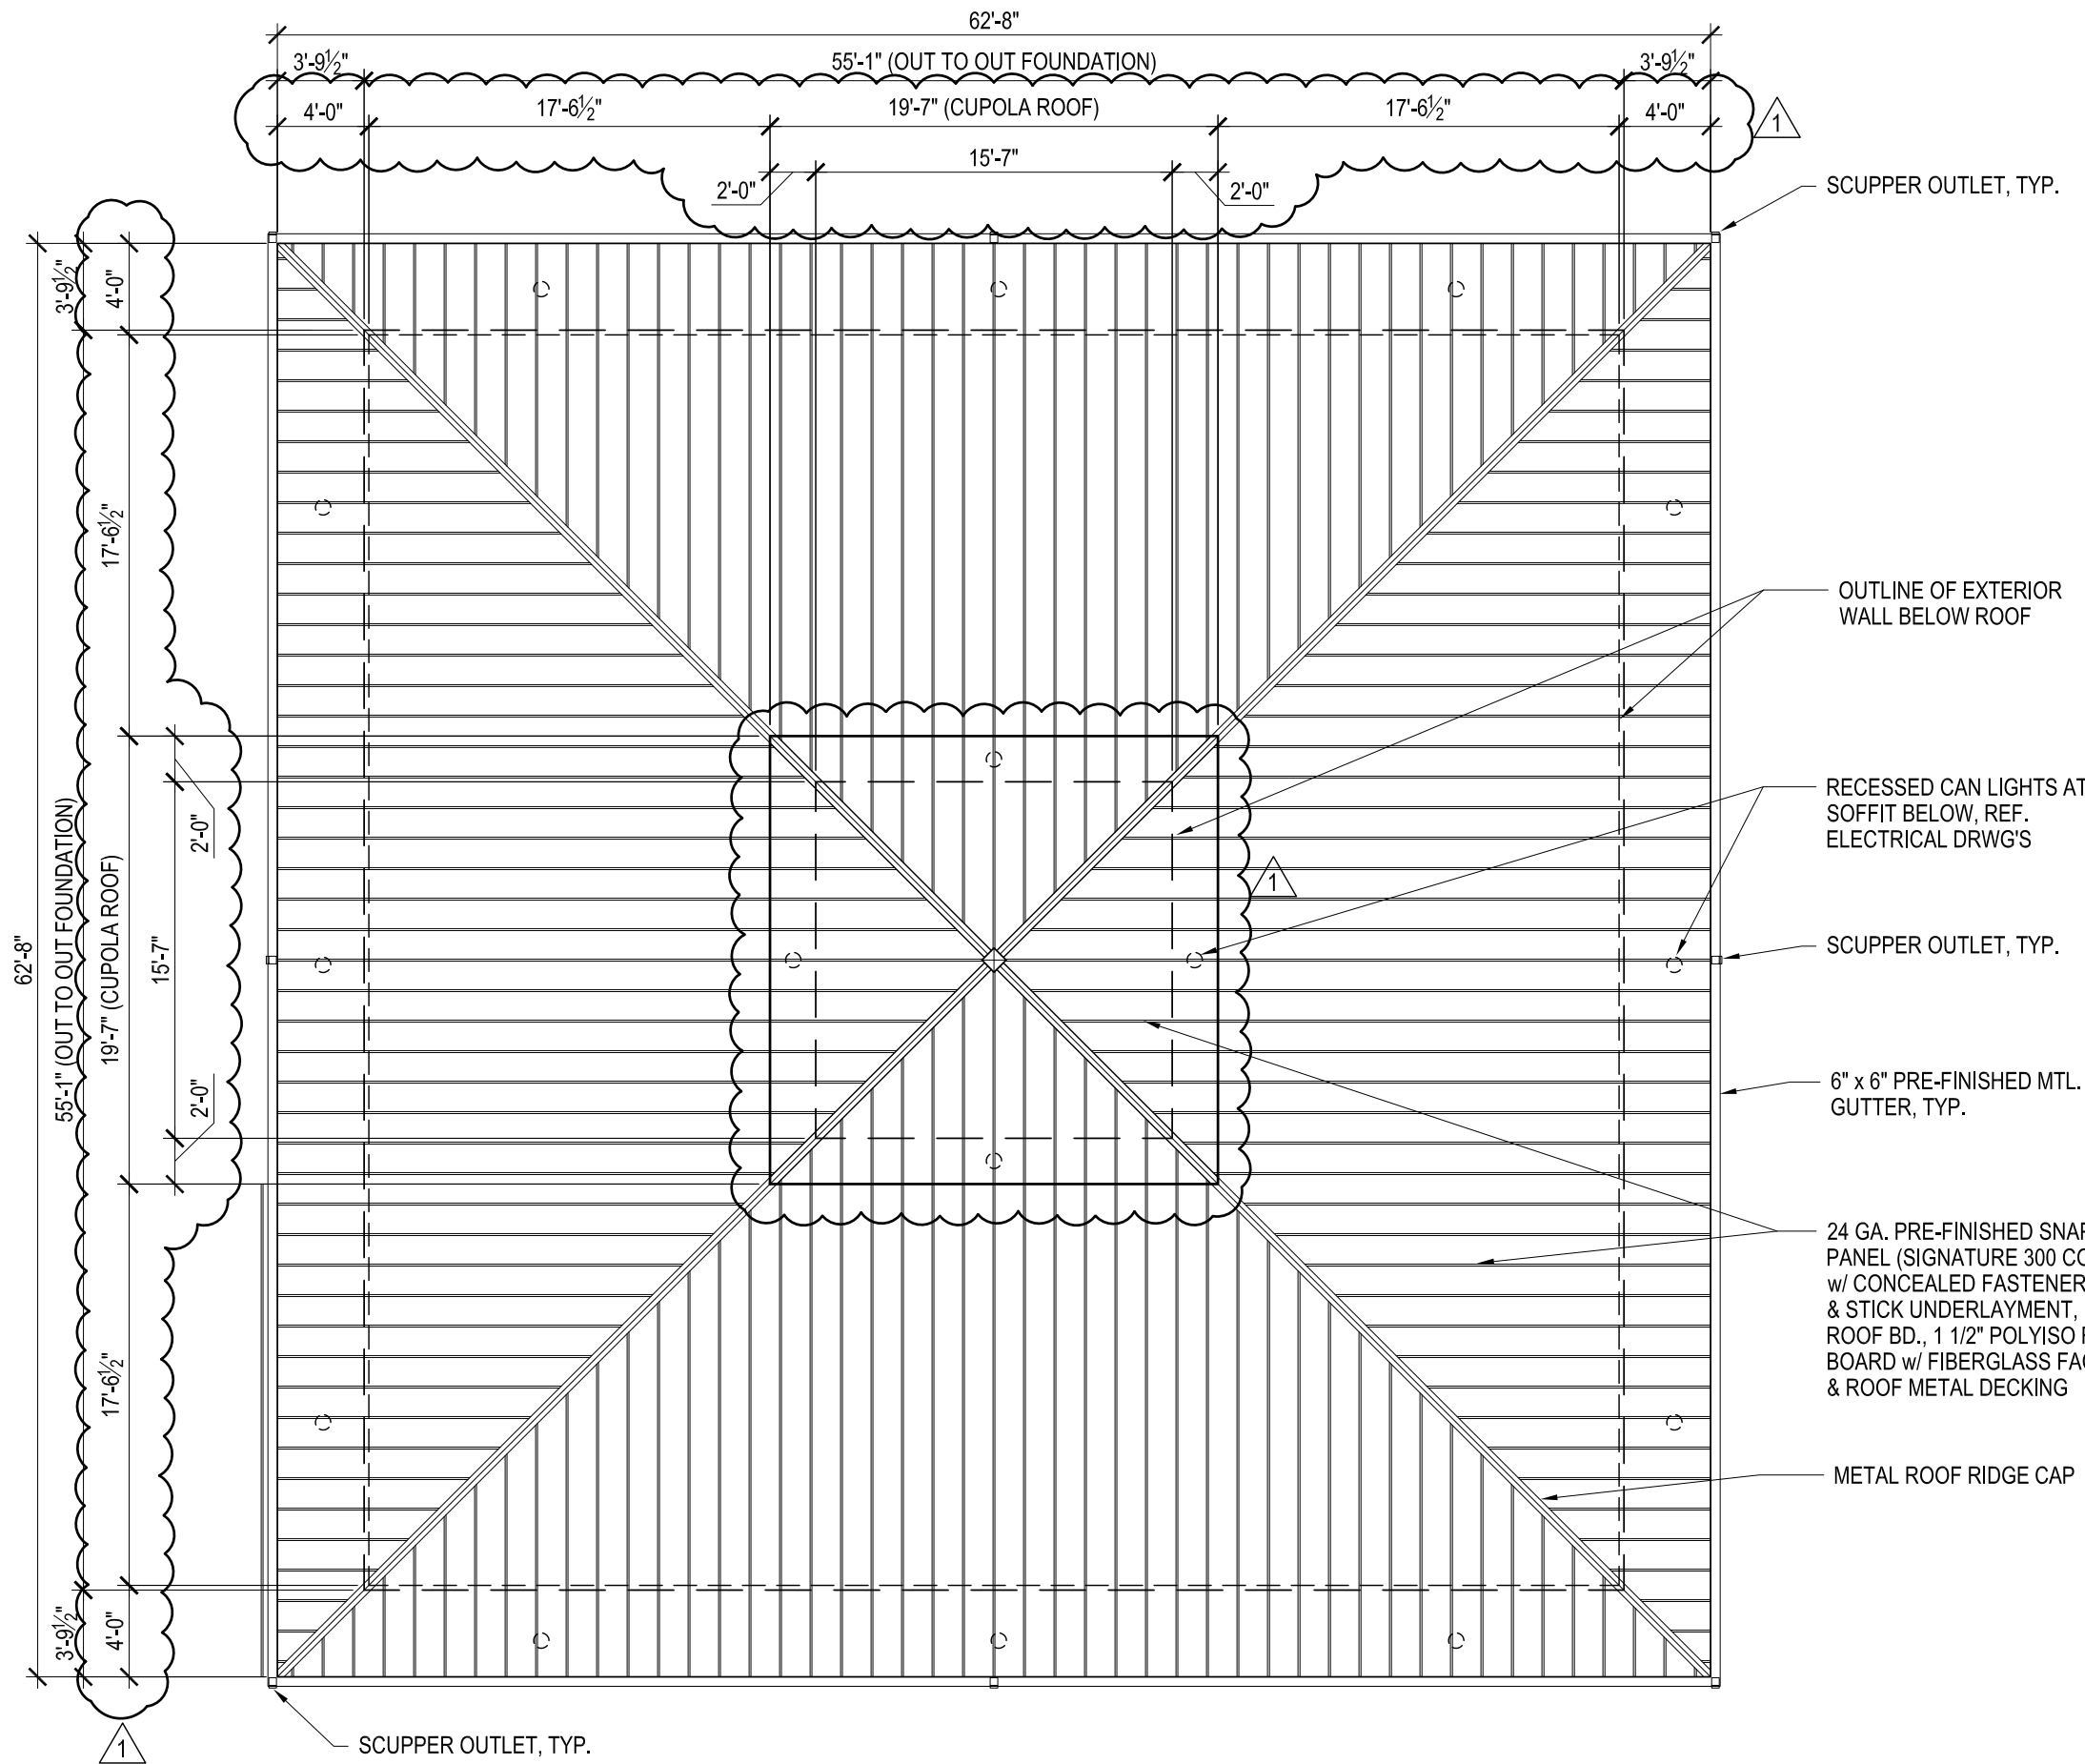


ROOF PLAN
SCALE: 1/8" = 1'-0"

5

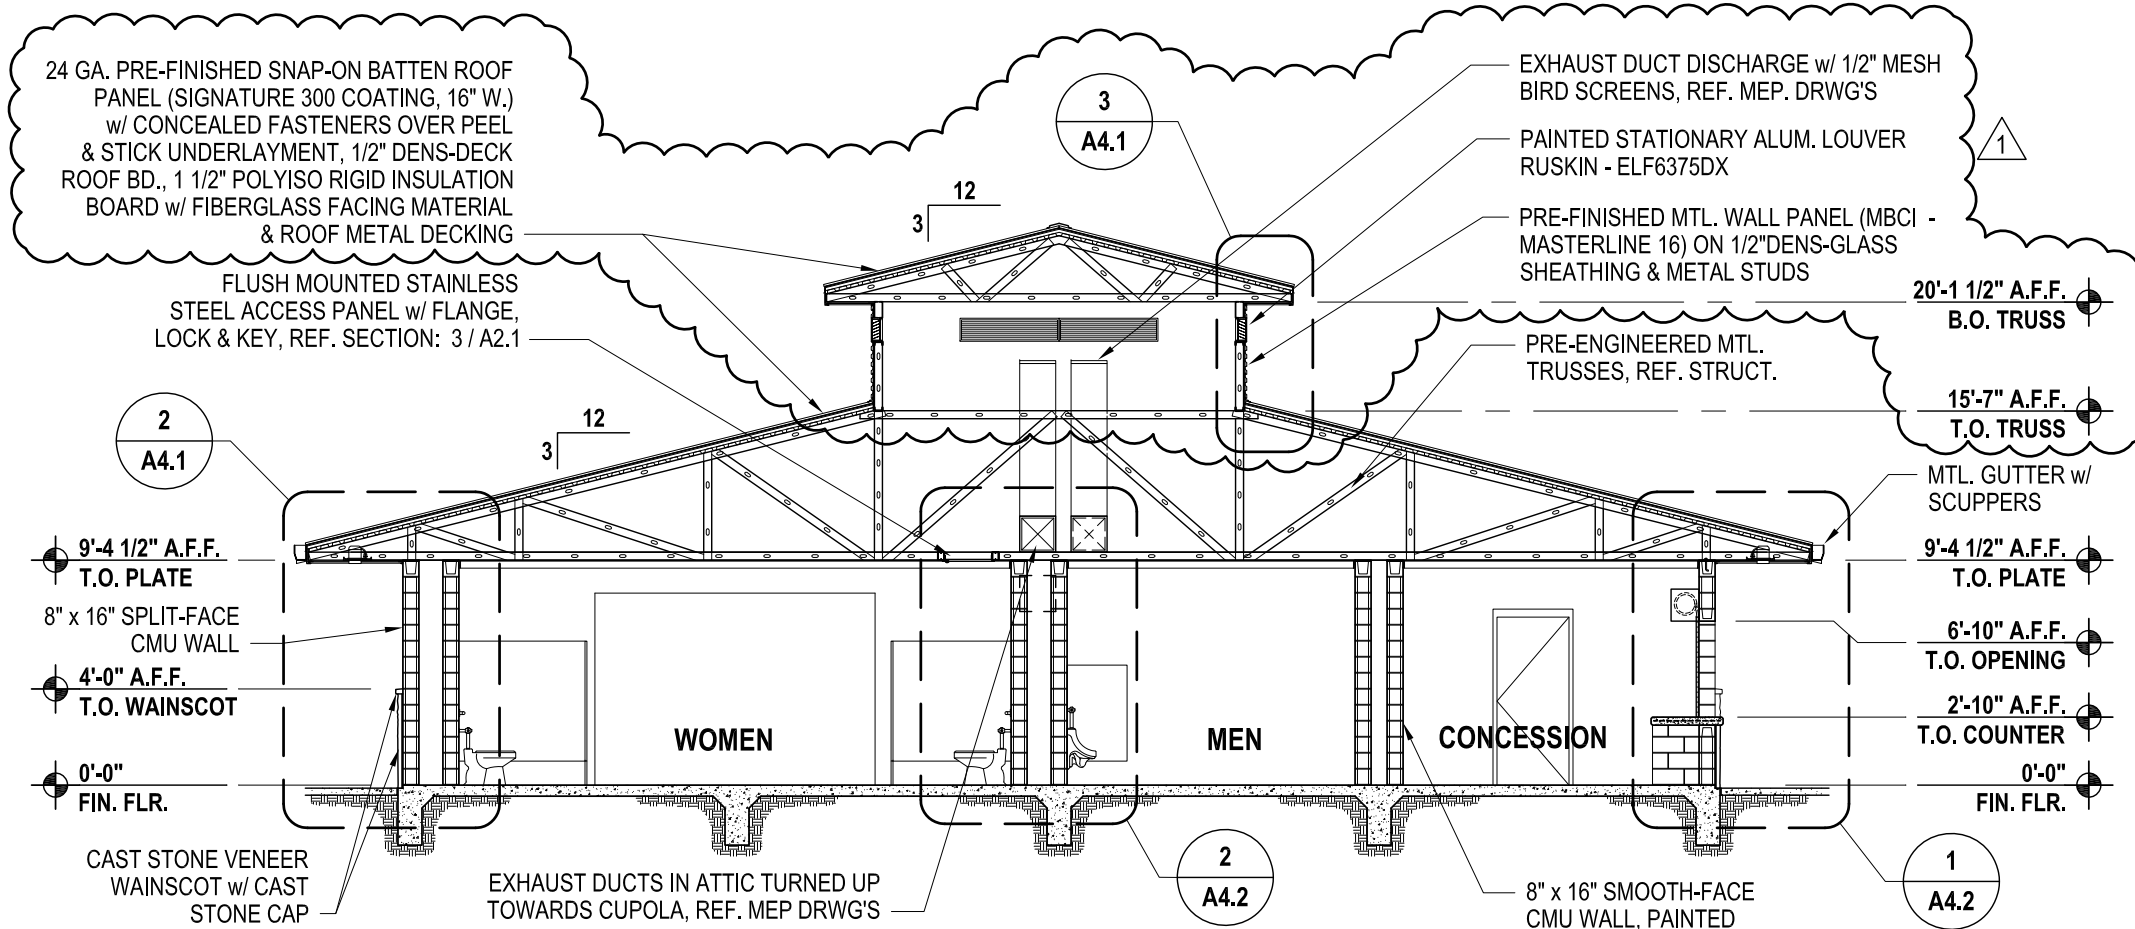


BUILDING SECTION
SCALE: 1/8" = 1'-0"

6

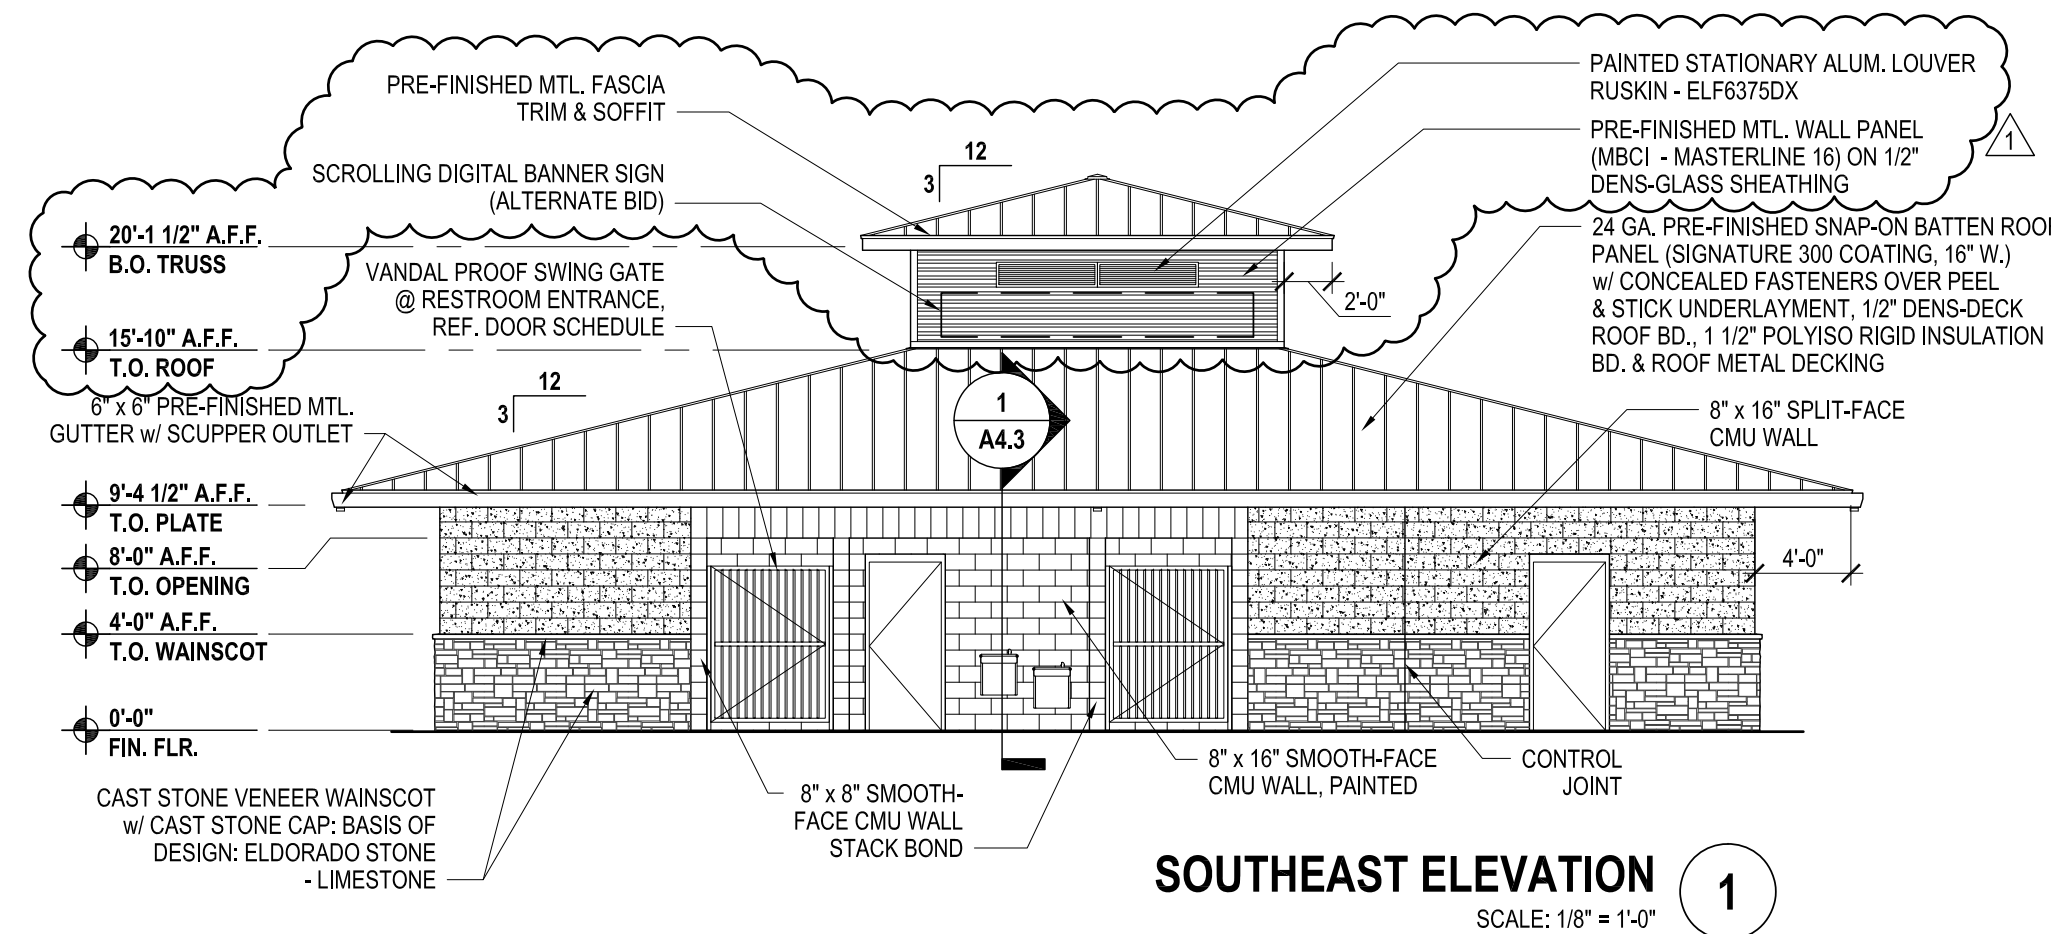


SOUTHEAST ELEVATION
SCALE: 1/8" = 1'-0"

1

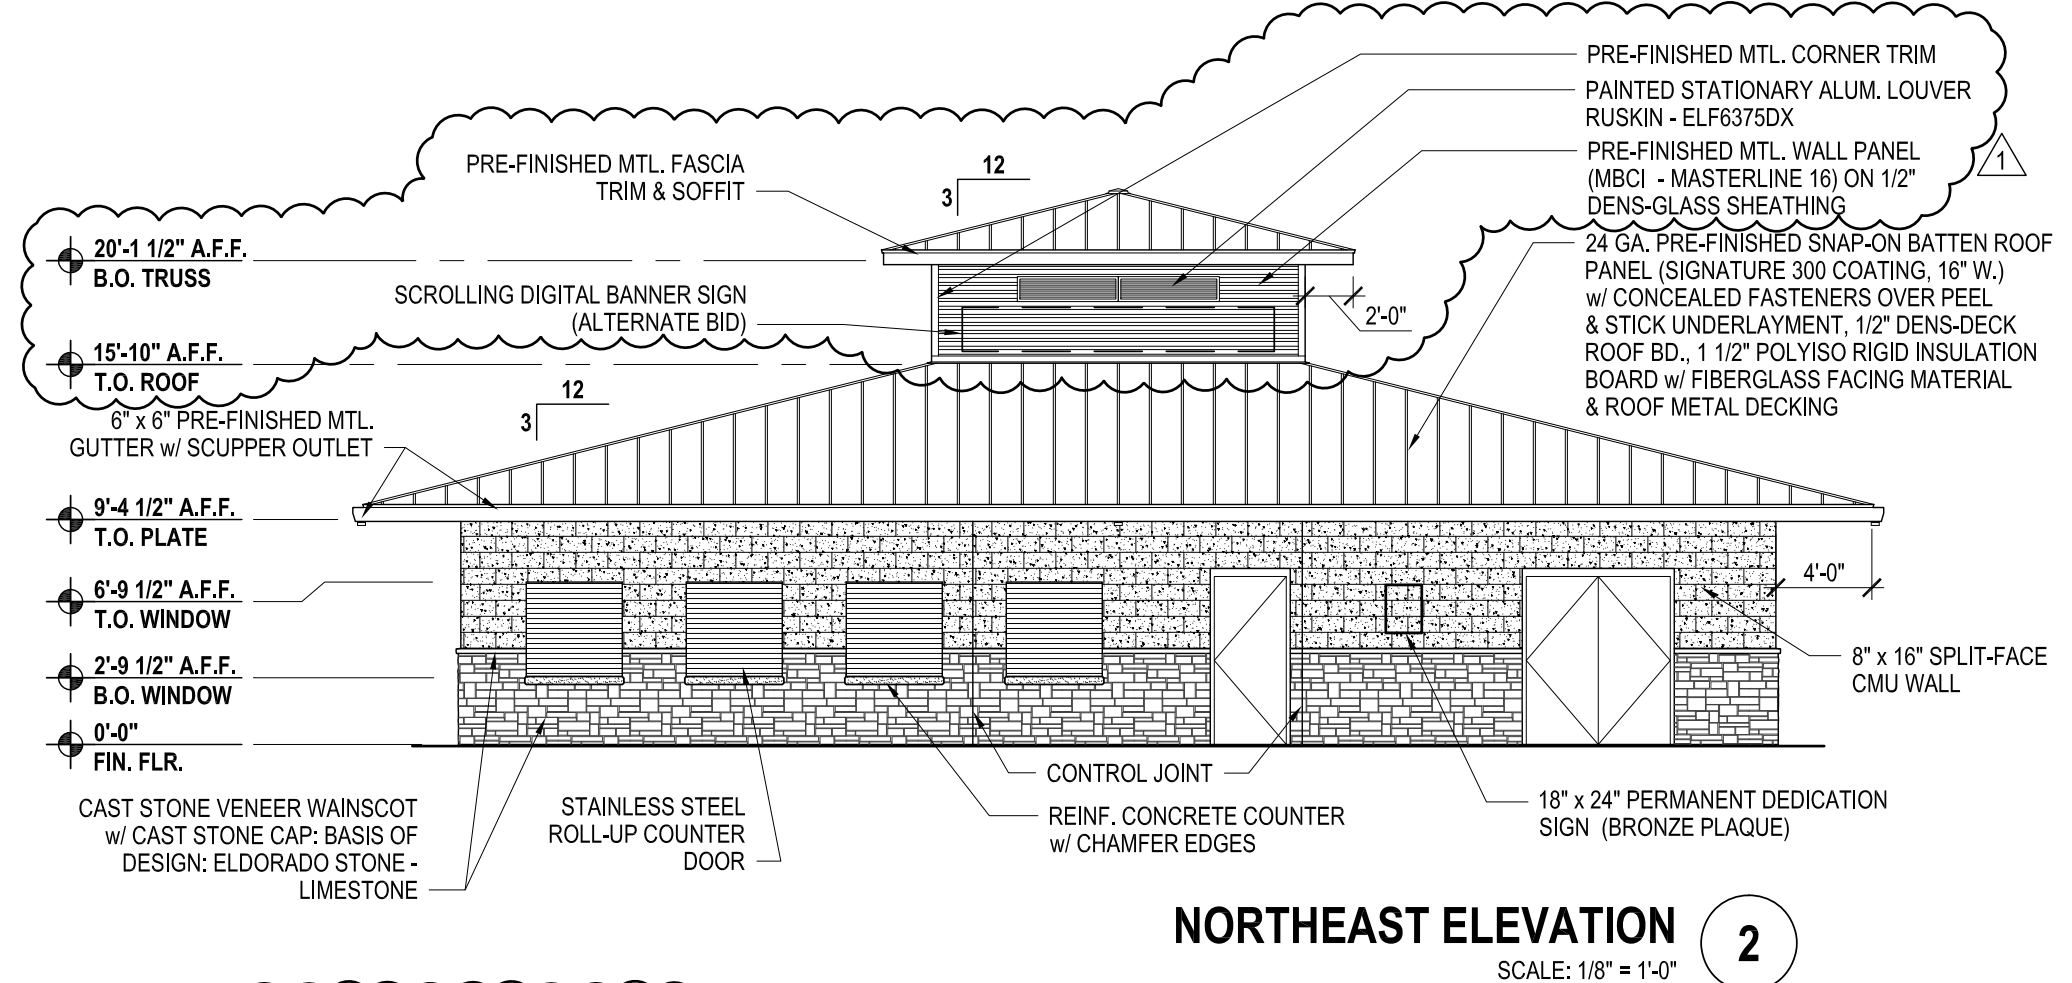


NORTHEAST ELEVATION
SCALE: 1/8" = 1'-0"

2

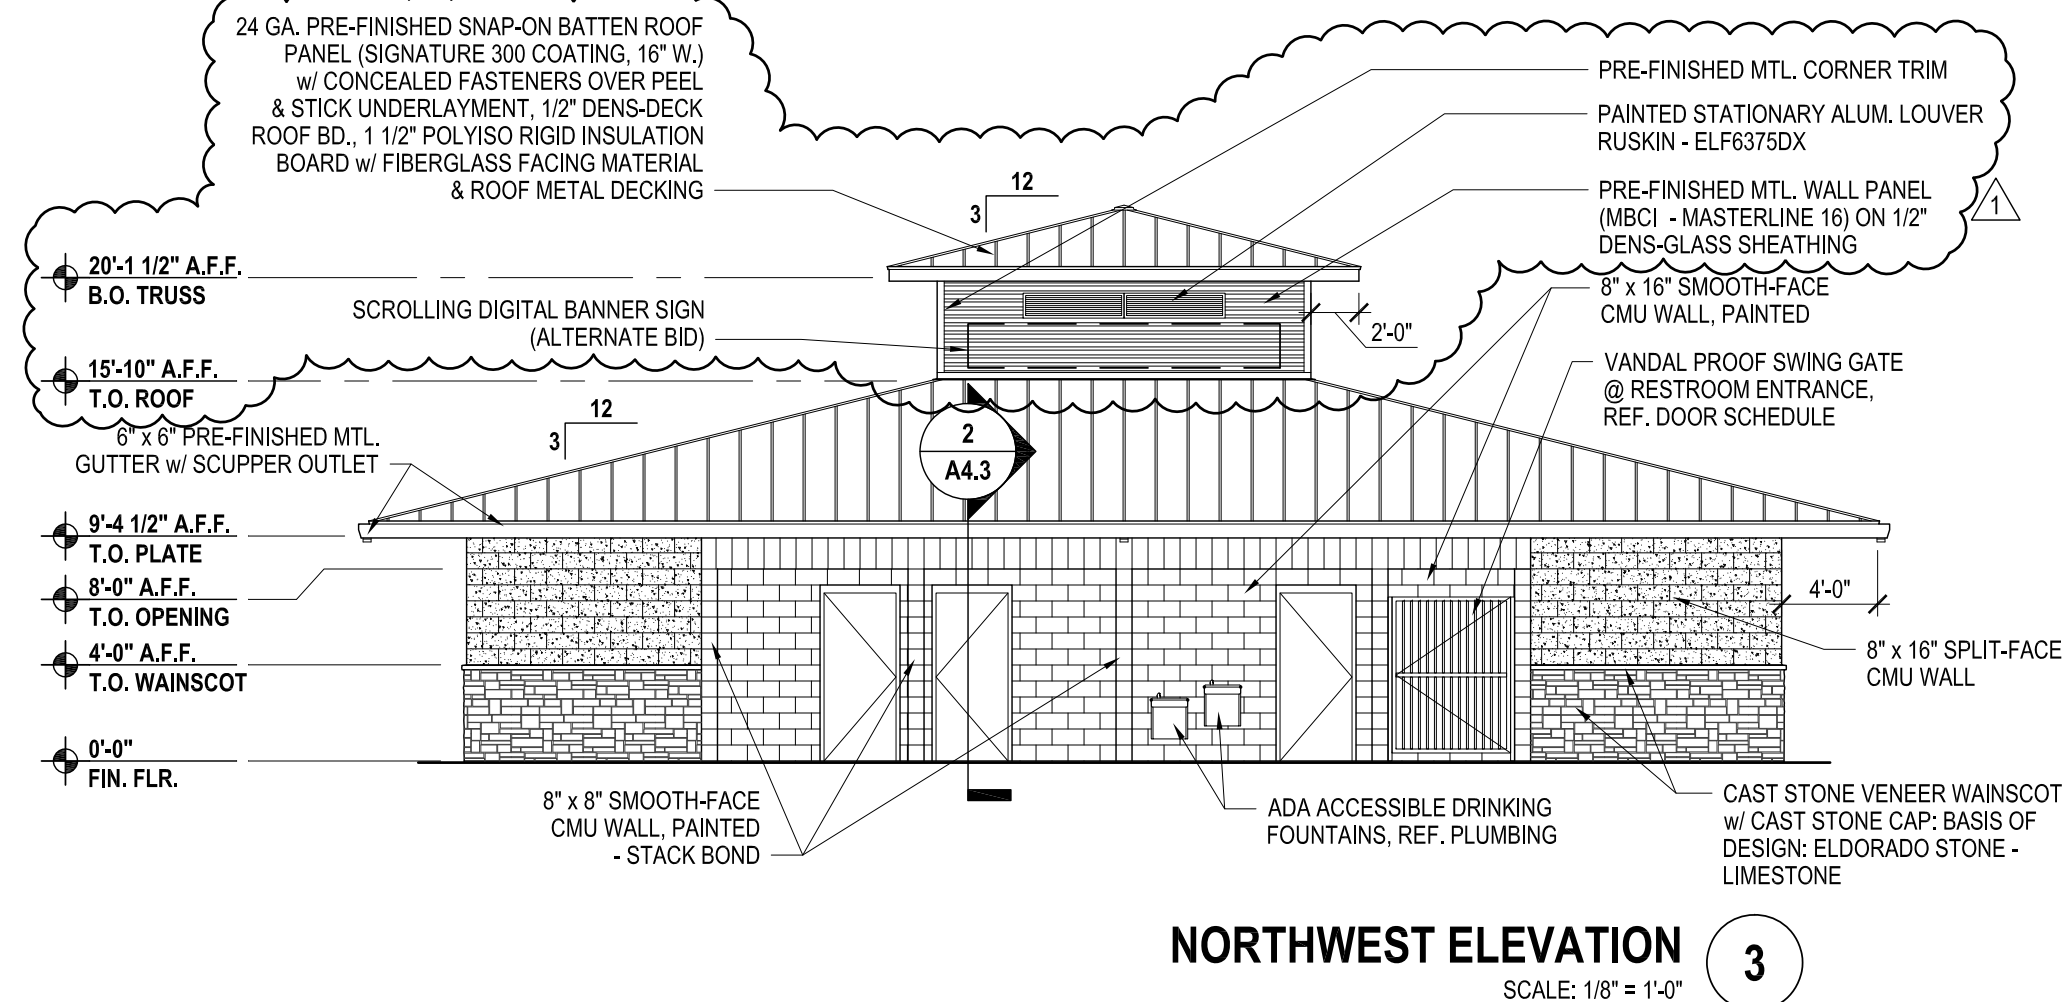

NORTHWEST ELEVATION
SCALE: 1/8" = 1'-0"

3

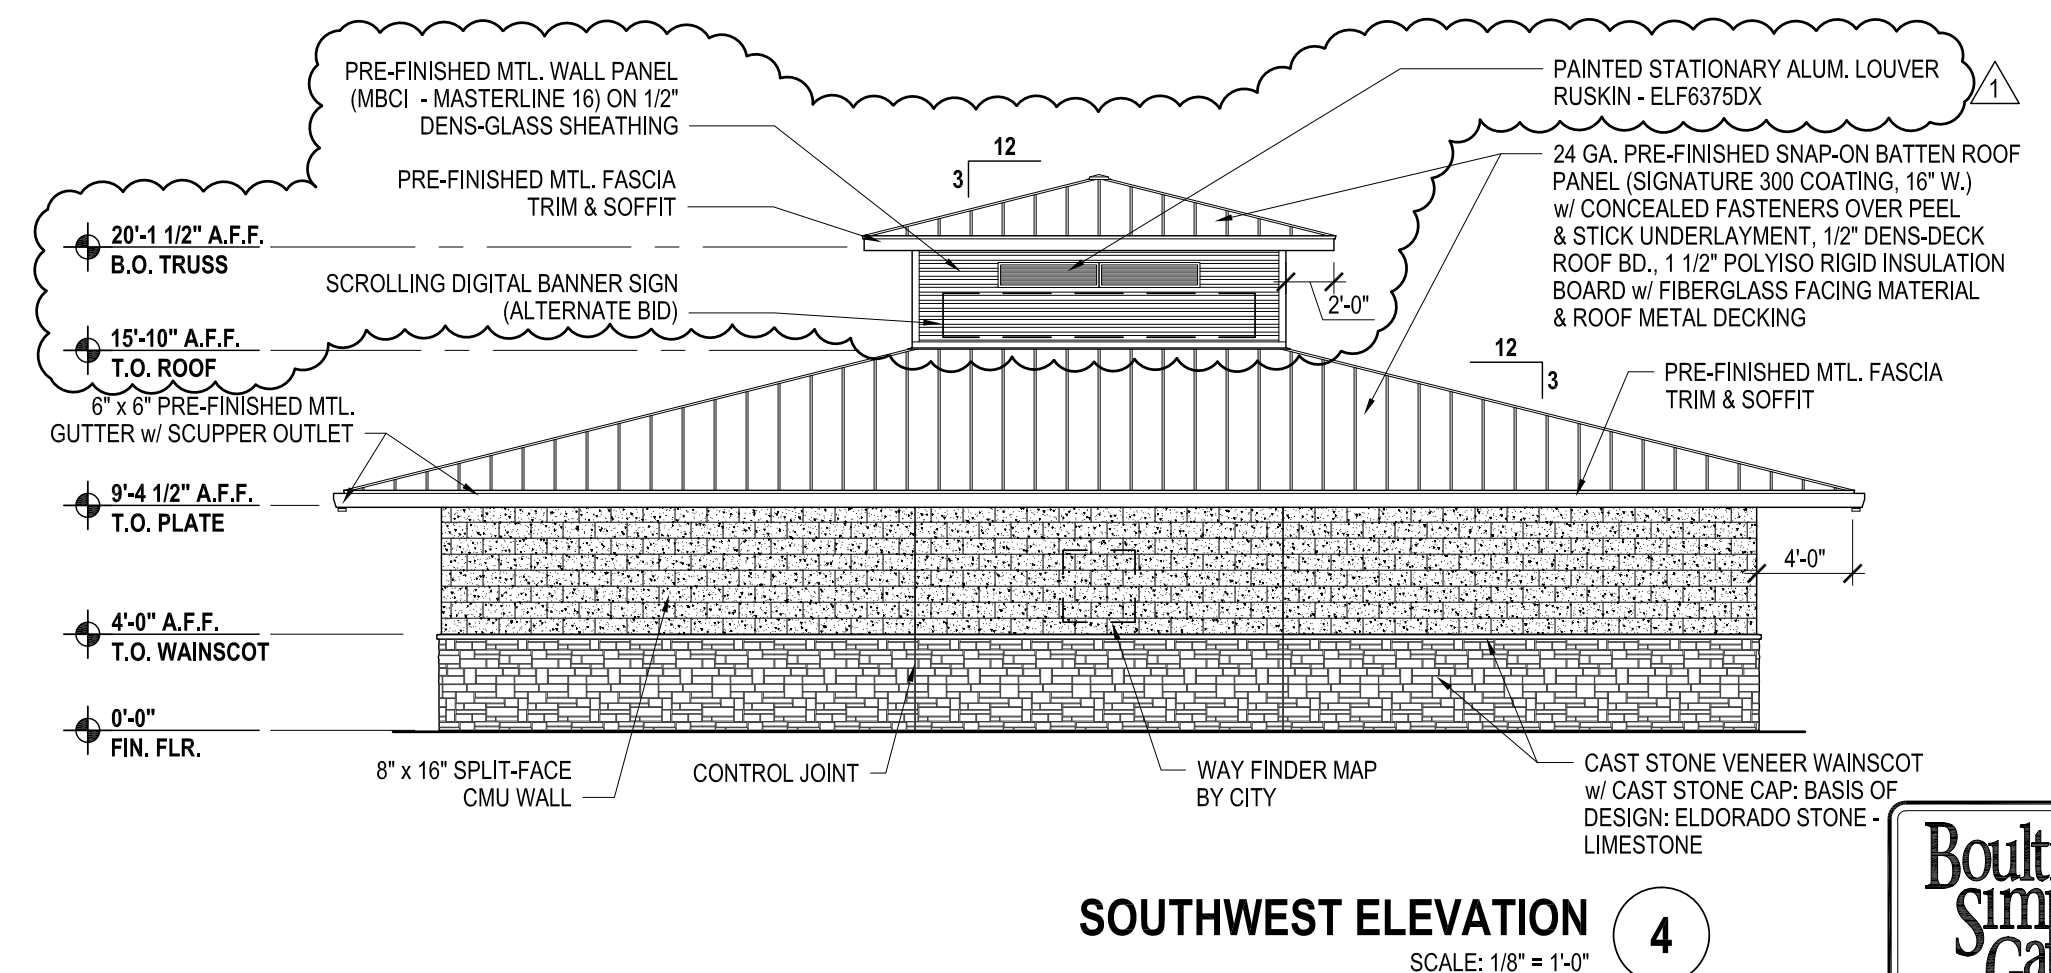

SOUTHWEST ELEVATION
SCALE: 1/8" = 1'-0"

4

CITY OF McALLEN
SOFTBALL FIELD FACILITIES
MUNICIPAL PARK
McALLEN, TEXAS



HALFF
5000 WEST MILITARY HWY. SUITE 100
MCALLEN, TEXAS 78103
TEL (956) 664-0286
FAX (956) 664-0282
TDD (956) 664-0282

Revision	No.	Date	Description
	1	7-26-18	ADDED CUPOLA & MATERIAL CALL OUT



100%
CONSTRUCTION
DOCUMENTS

Project No.:	33348.001
Issued:	07/11/2018
Drawn By:	G.Q.
Checked By:	B.S.
Scale:	AS SHOWN
Sheet Title	EXT. ELEVATIONS & ROOF PLAN

A3.1

Sheet Number







5000 WEST MILITARY HWY, SUITE 100
MCALLEN, TEXAS 78103
TEL (956) 664-4286
FAX (956) 664-4282
TDE FILE #R-512

Revision No.	Date	Description
1	7-26-18	ADDED WALL SECTION @ CIPOLA
2		ADDED ADA NOTES & DIMENSIONS
3		
4		
5		
6		
7		
8		
9		
10		




100%
CONSTRUCTION
DOCUMENTS

Project No.:	33348.001
Issued:	07/11/2018
Drawn By:	G.Q.
Checked By:	B.S.
Scale:	AS SHOWN
Sheet Title	WALL SECTIONS
Sheet Number	A4.1

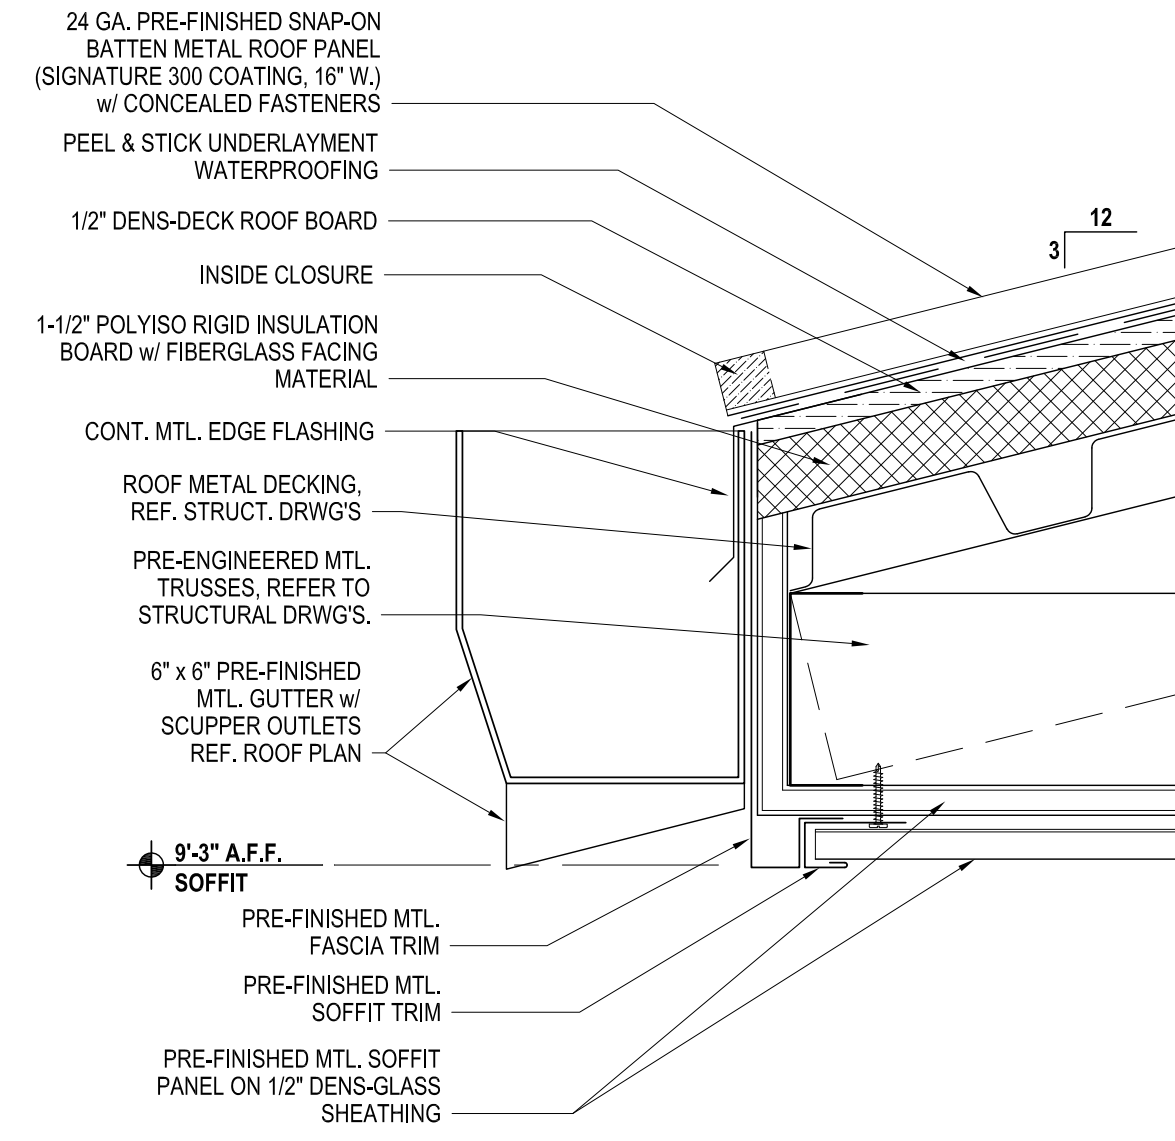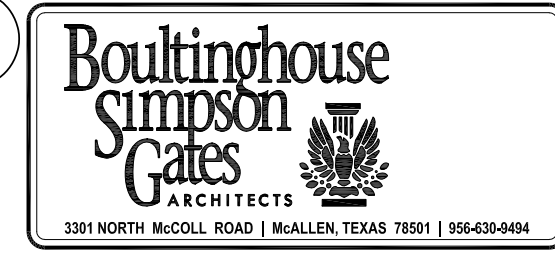


GUTTER DETAIL
SCALE: 3" = 1'-0"

5

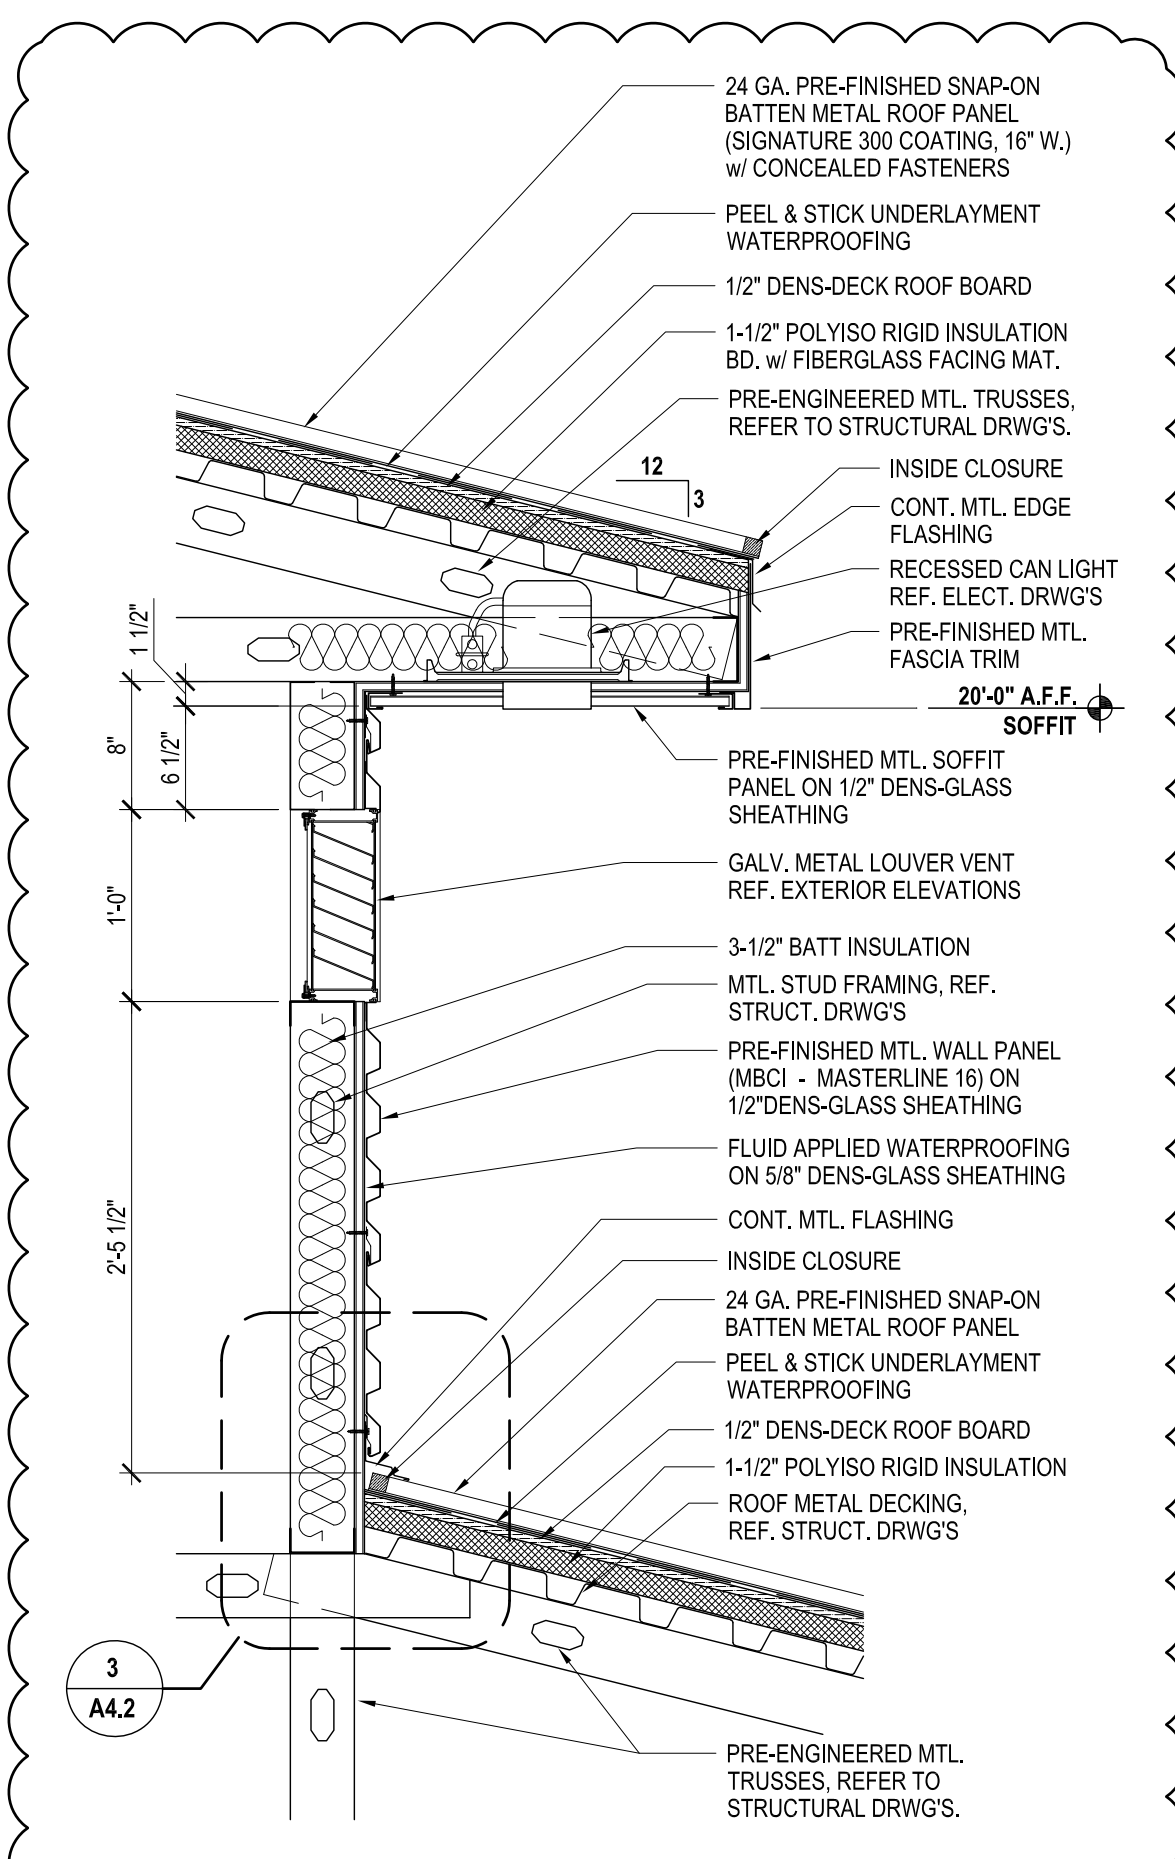


WALL SECTION
SCALE: 1" = 1'-0"

3

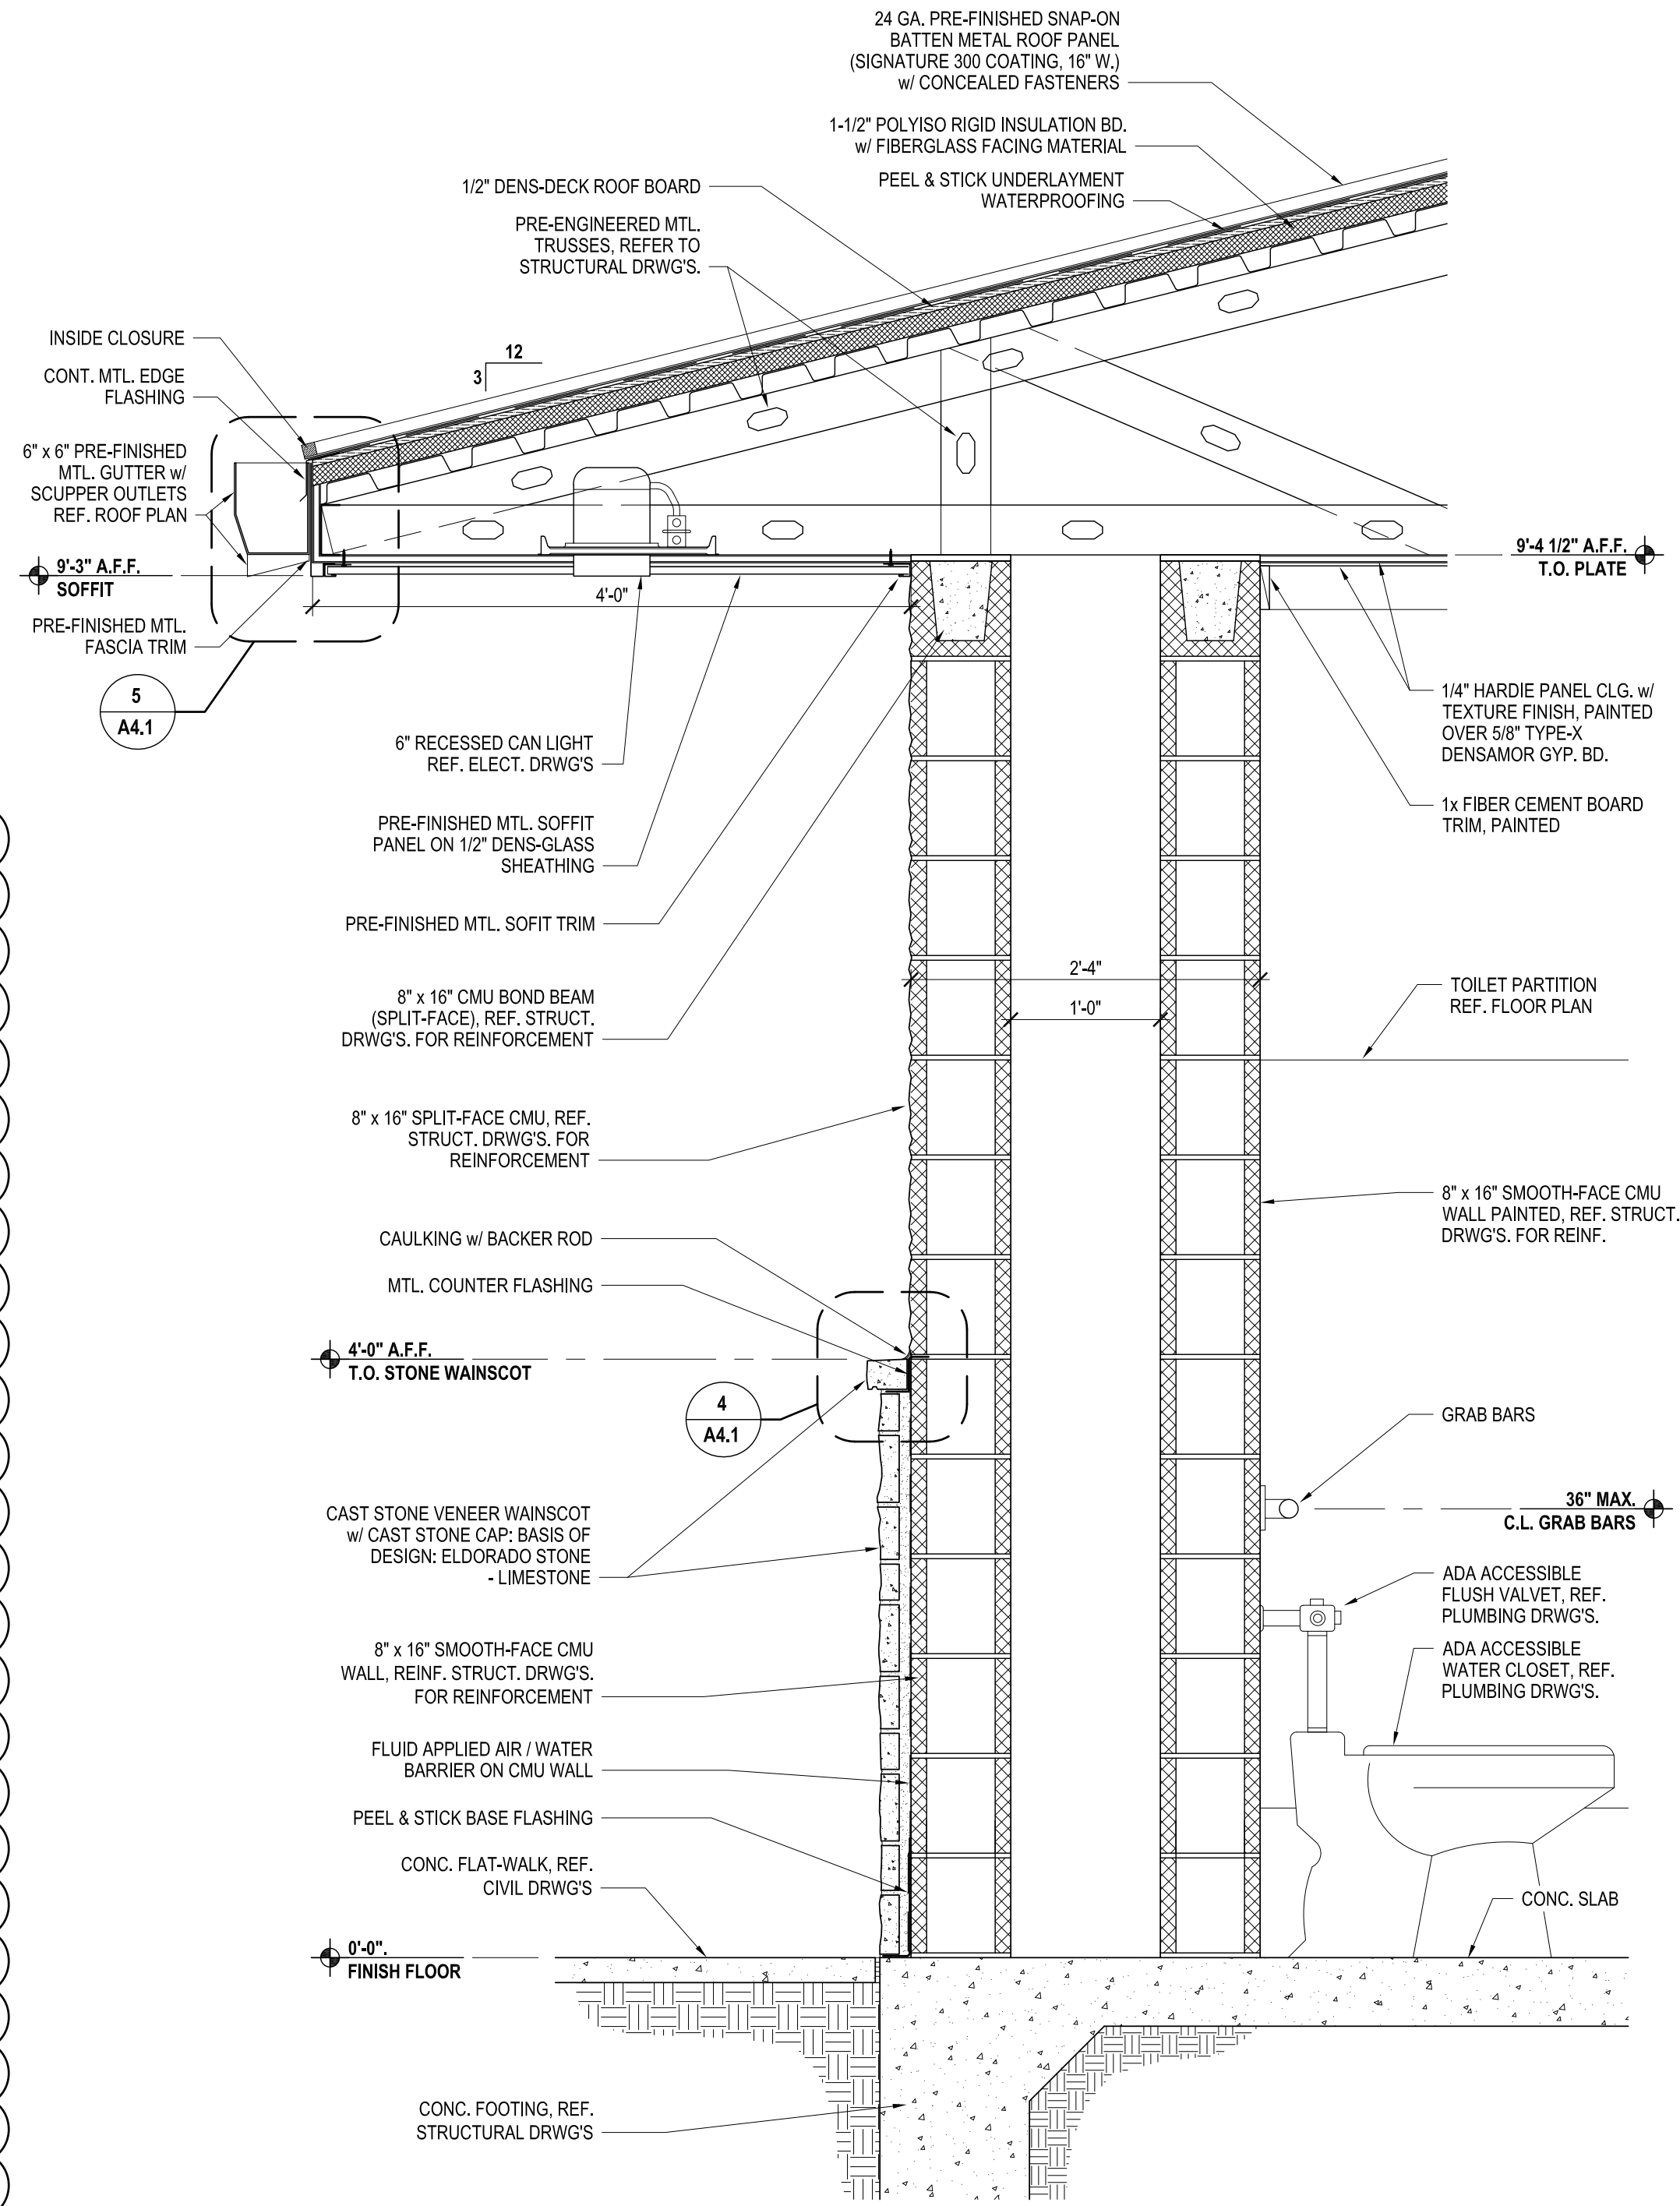


WALL SECTION
SCALE: 1" = 1'-0"

2

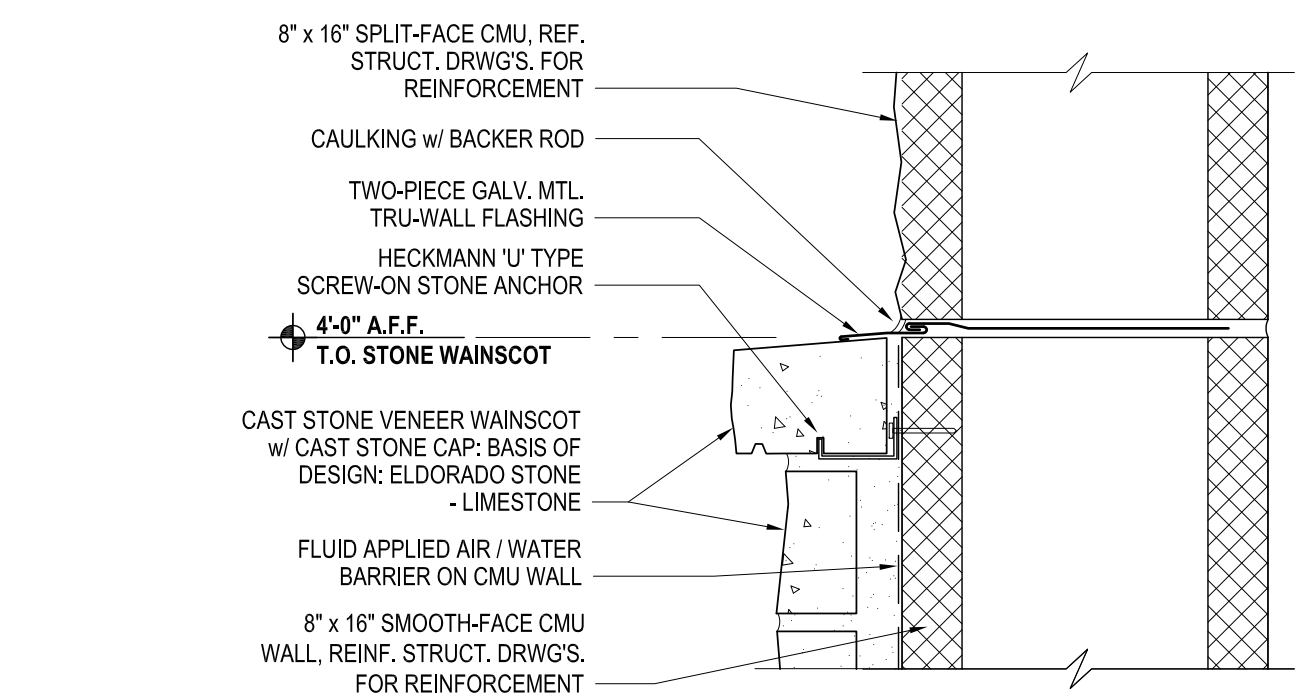


WALL DETAIL
SCALE: 3" = 1'-0"

4

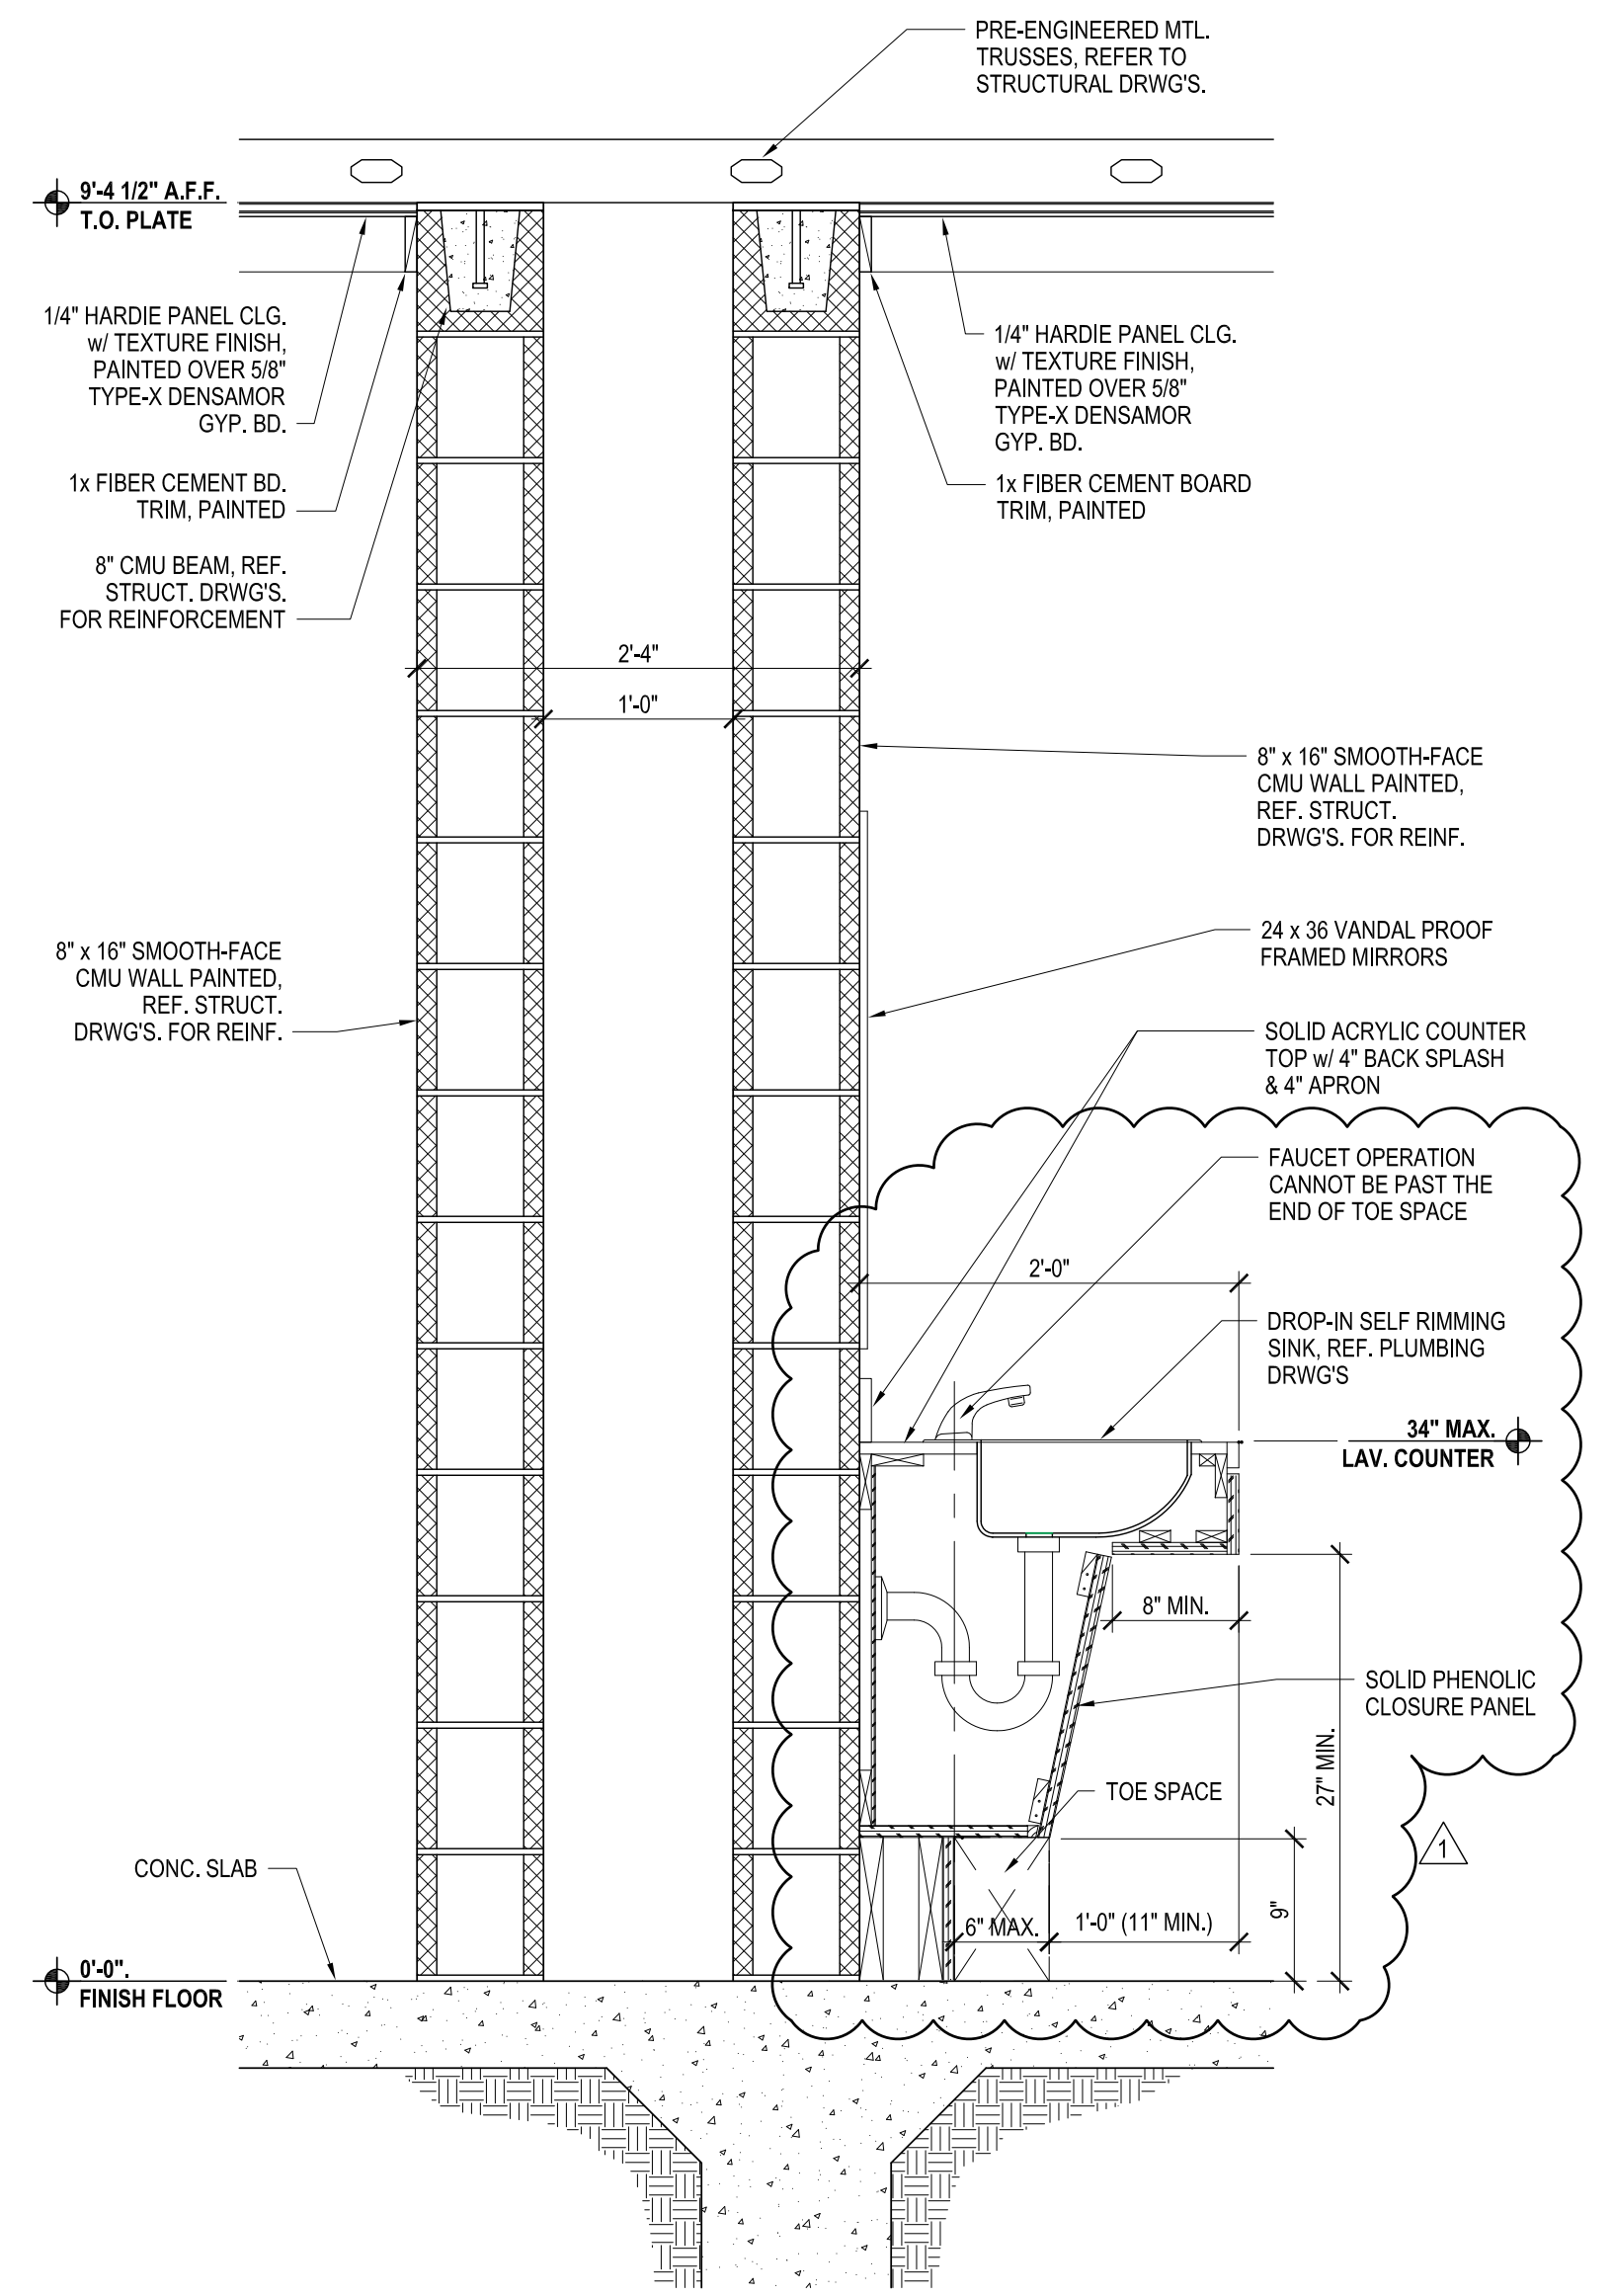


WALL SECTION
SCALE: 1" = 1'-0"


1

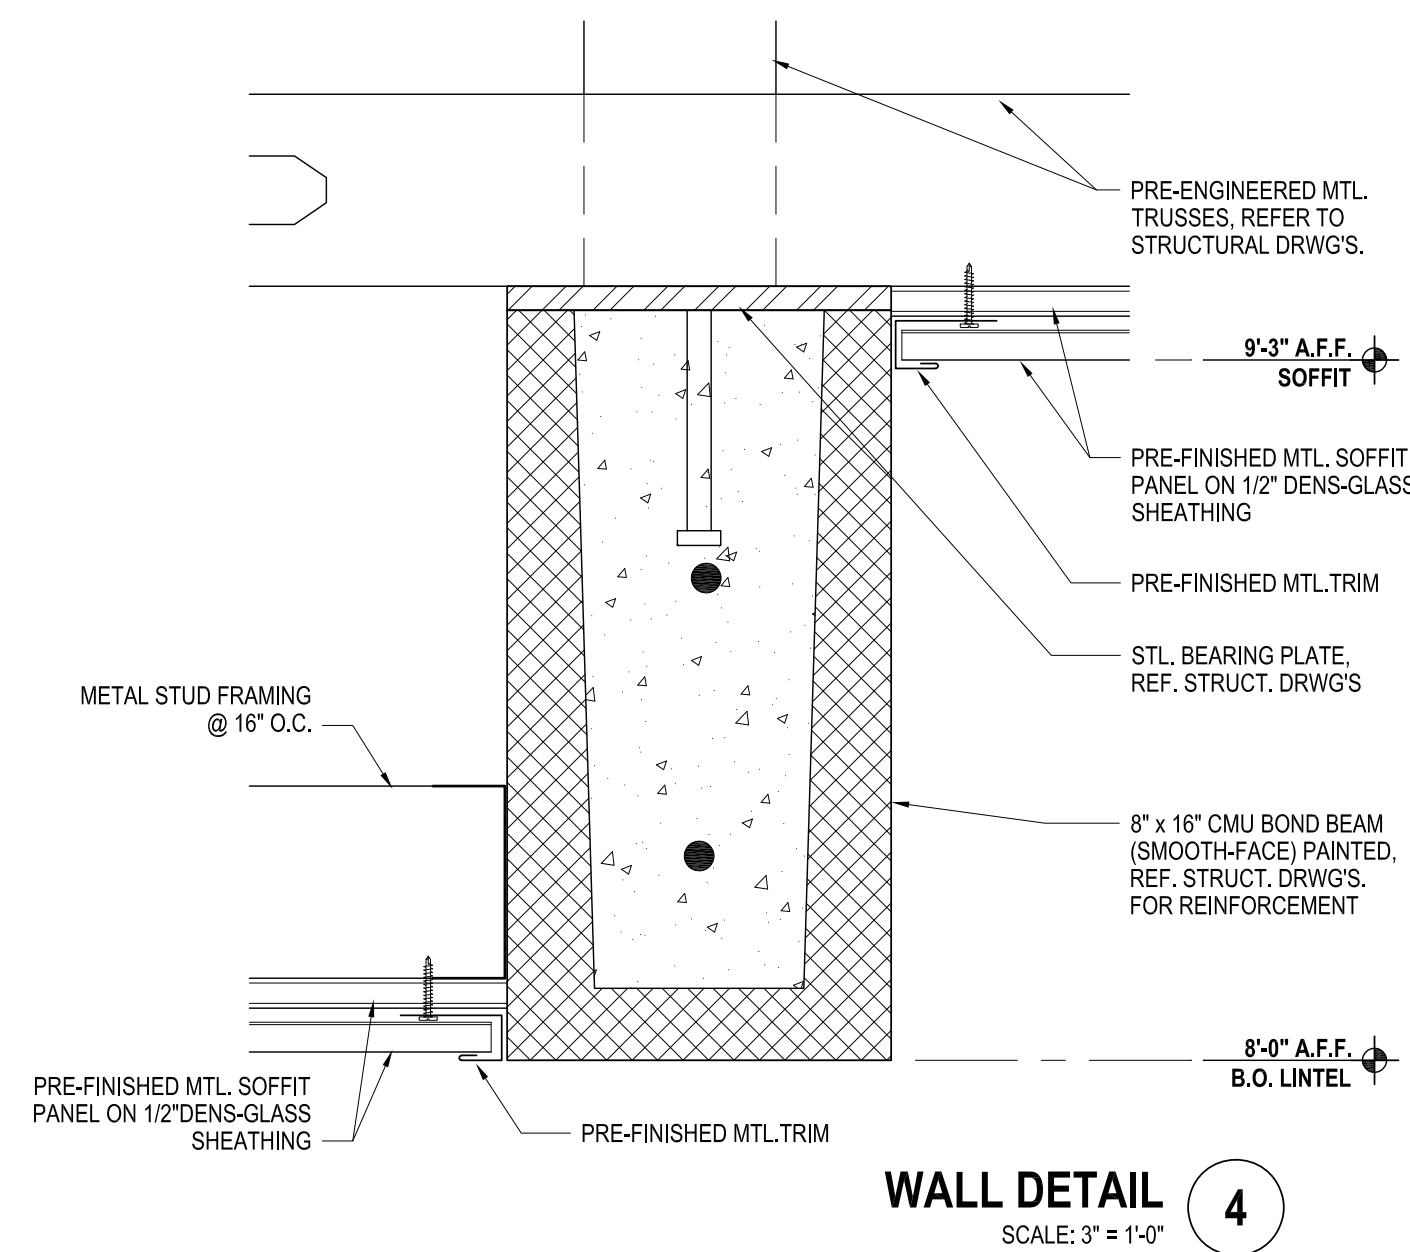


WALL DETAIL 4
SCALE: 3" = 1'-0"

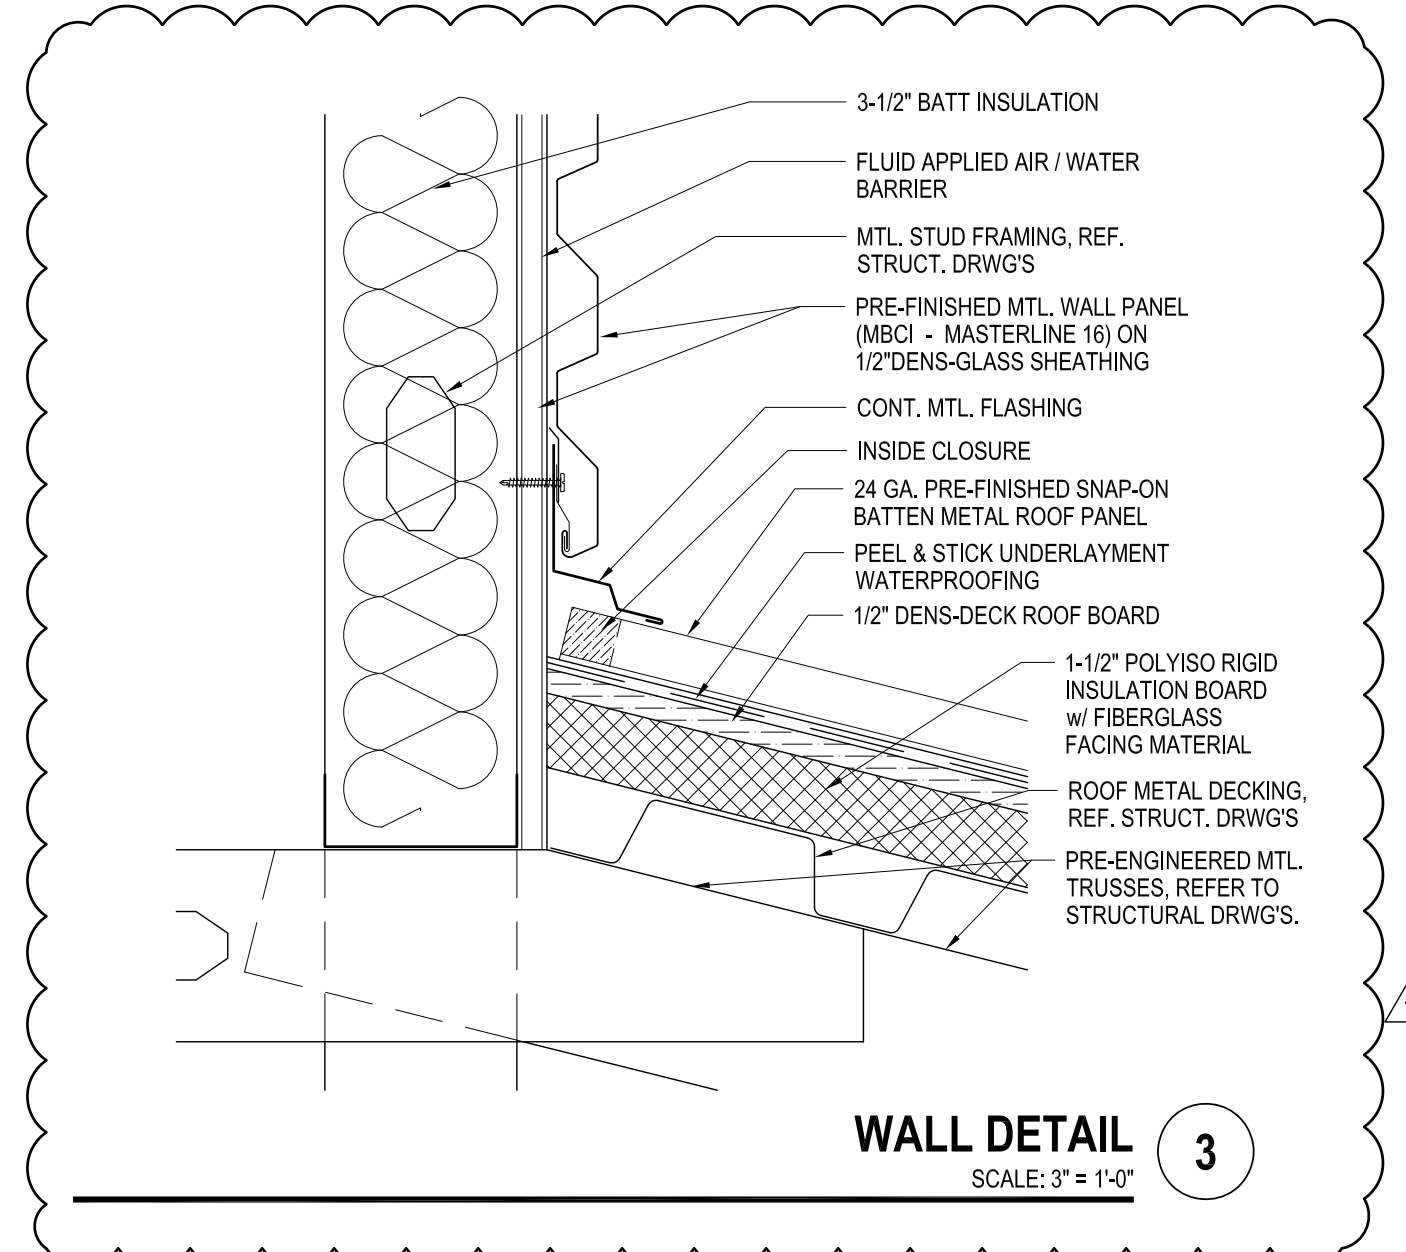


WALL DETAIL 3
SCALE: 3" = 1'-0"

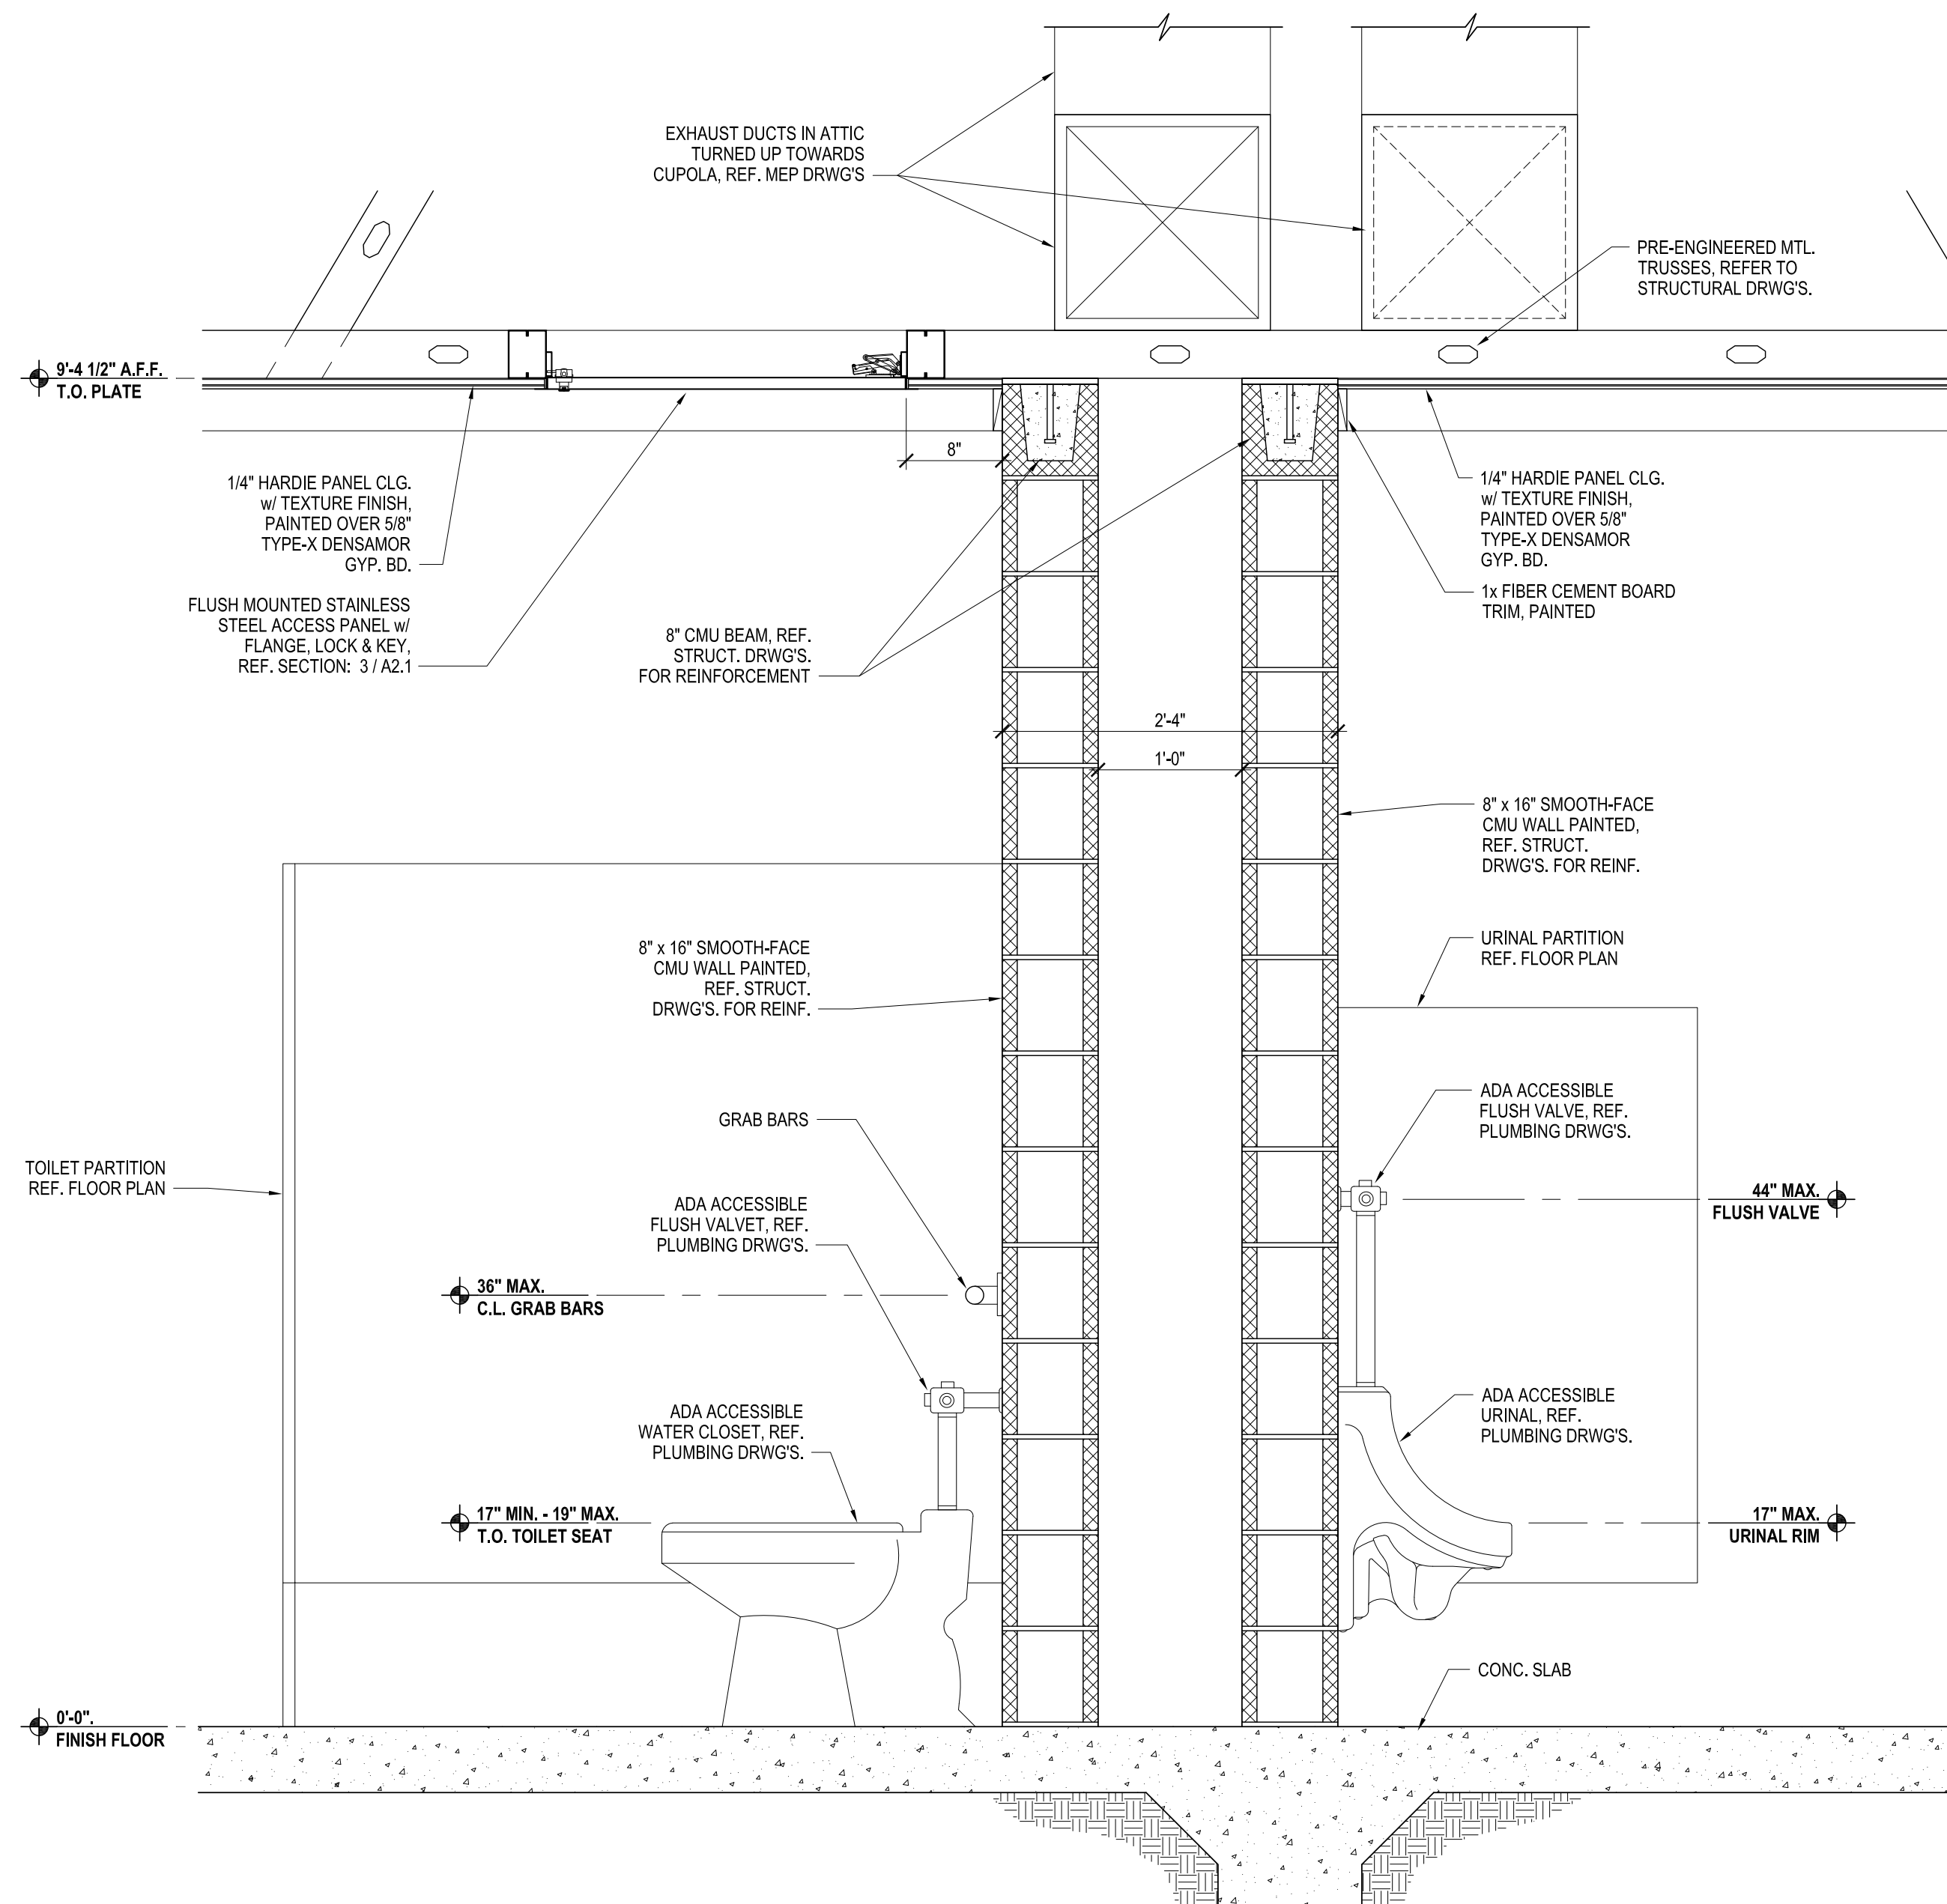

WALL SECTION 2
SCALE: 1" = 1'-0"

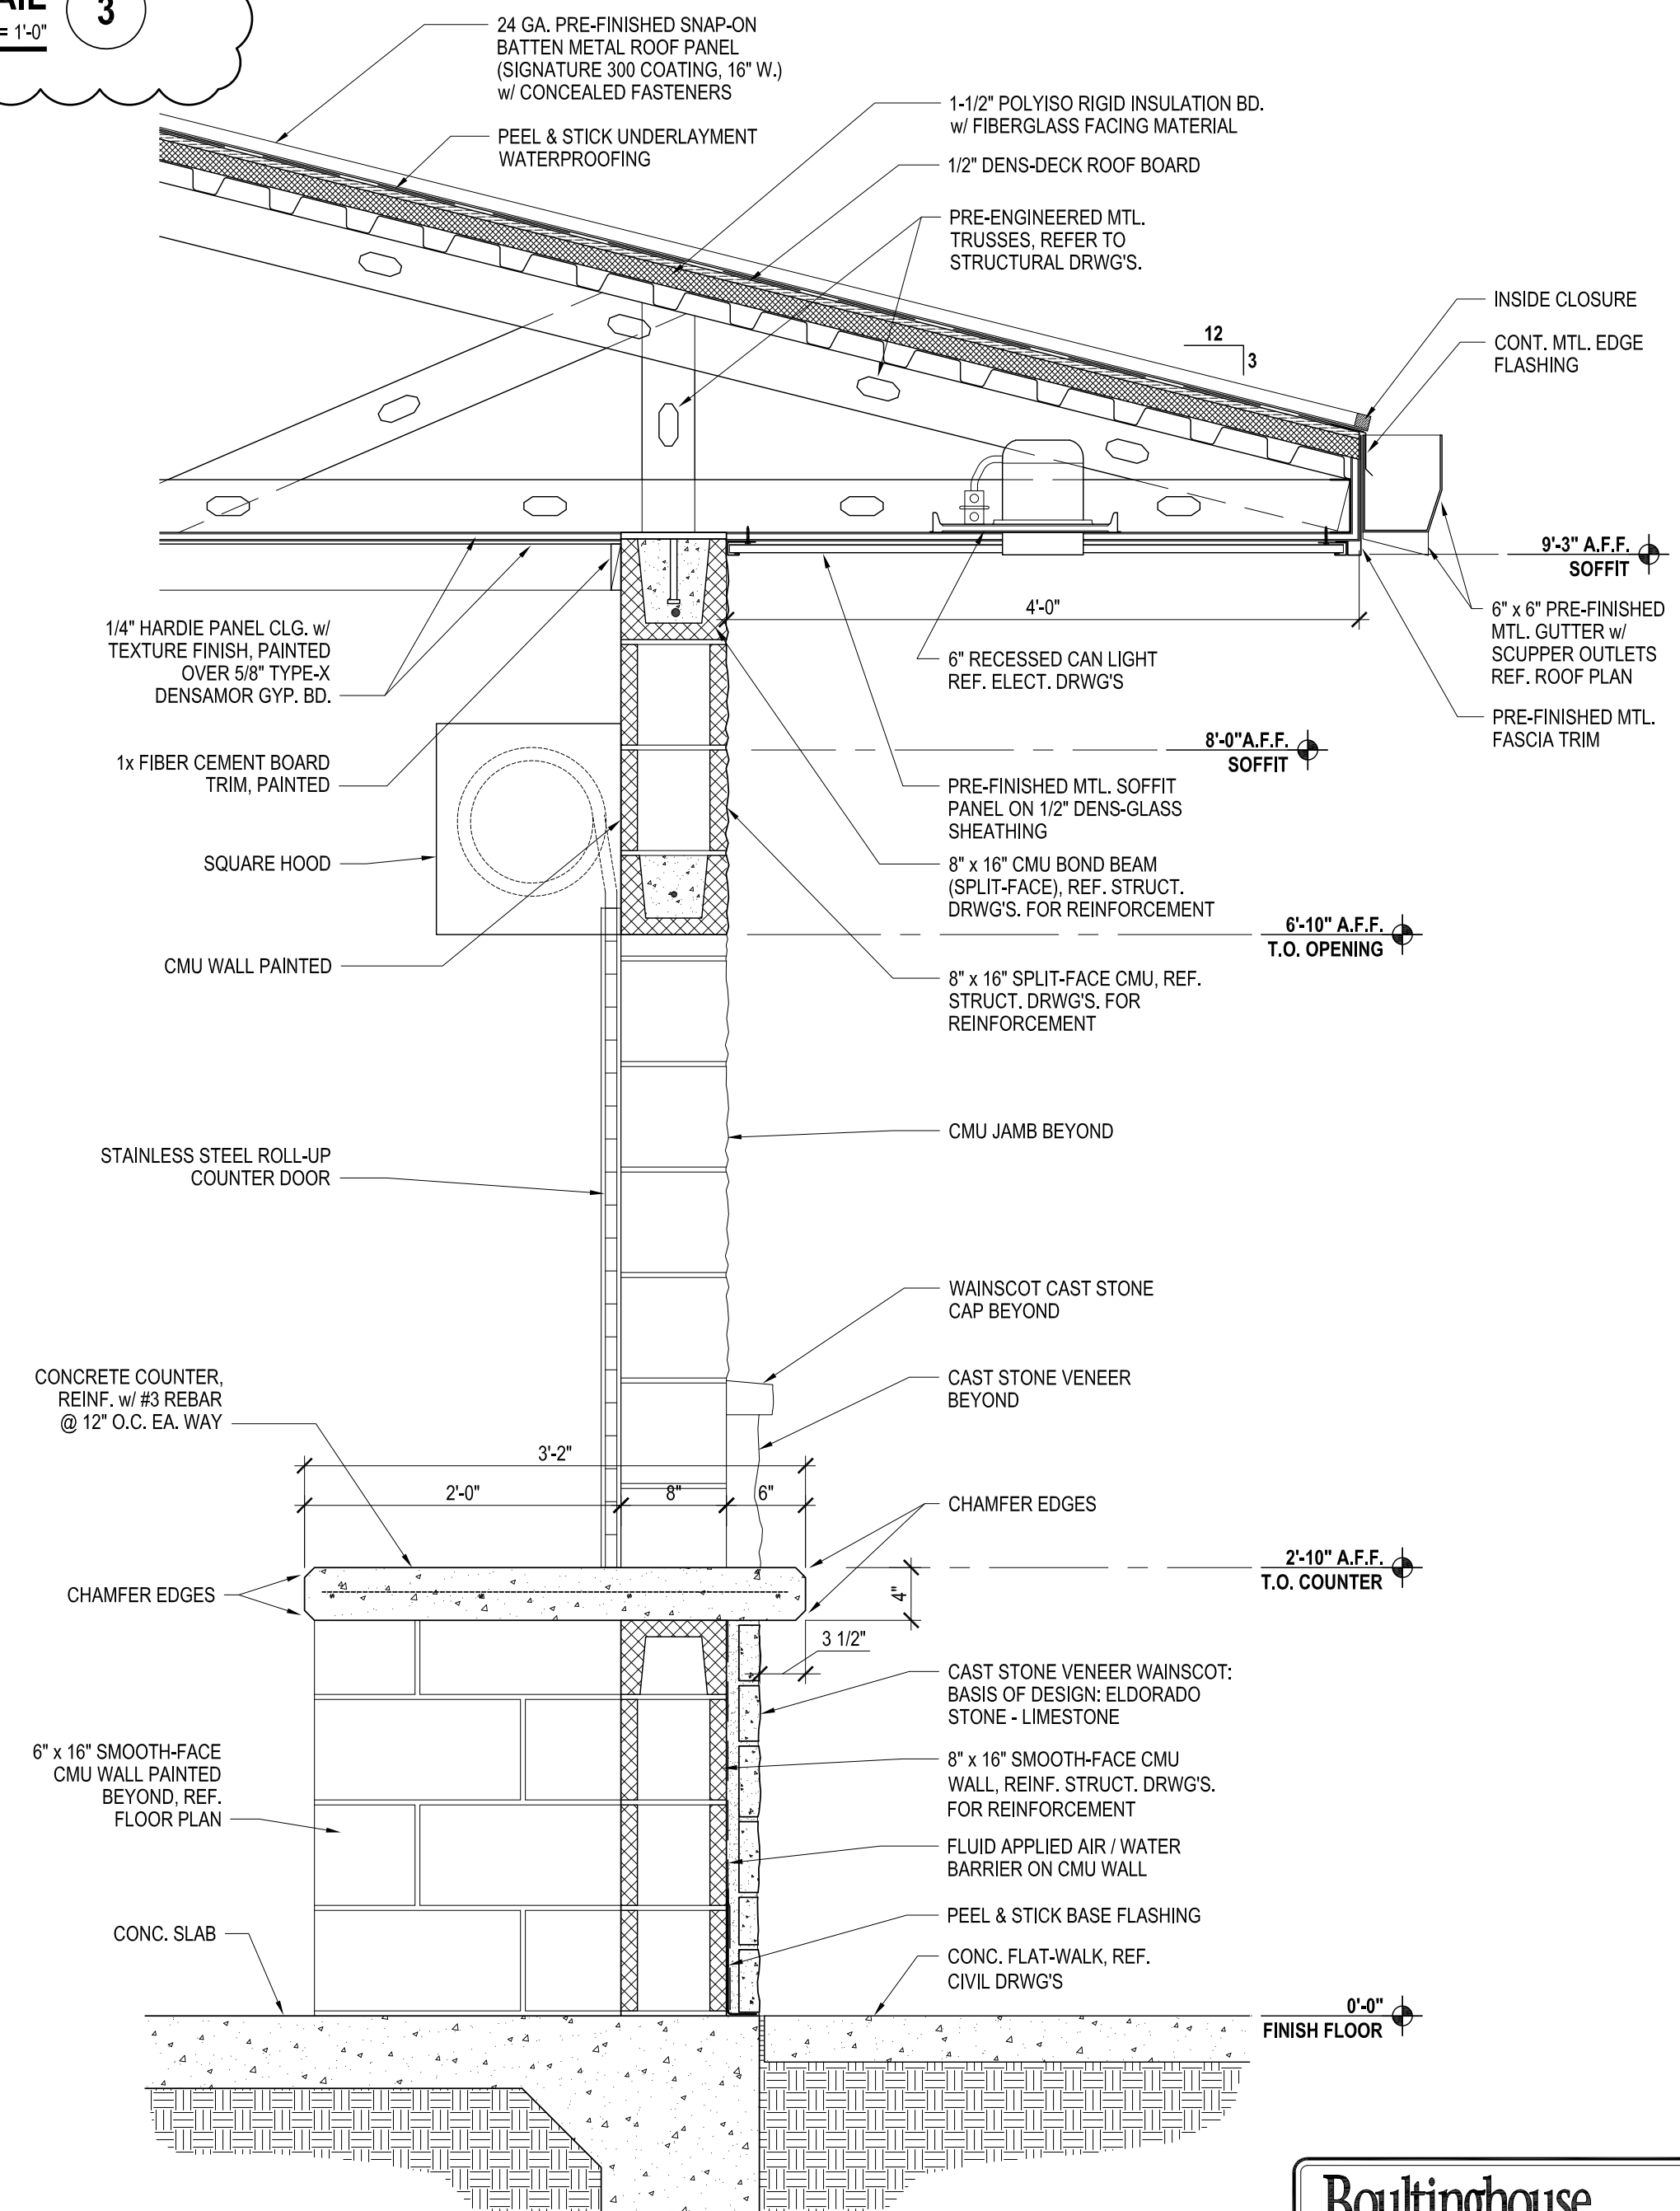

WALL SECTION 1
SCALE: 1" = 1'-0"

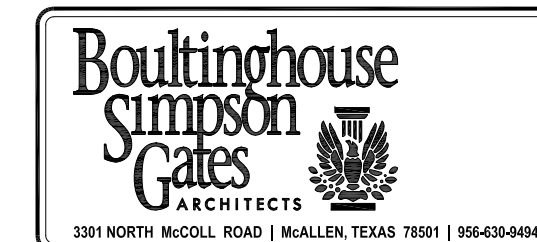

CITY OF McALLEN
SOFTBALL FIELD FACILITIES
MUNICIPAL PARK
McALLEN, TEXAS




HALFF
5000 WEST MILITARY HWY, SUITE 100
MCALLEN, TEXAS 78501
TEL (956) 664-4286
FAX (956) 664-4282
TDD: (956) 664-4282

Revision No.	Date	Description
1	7-26-18	ADDED WALL DETAIL @ CUPOLA



100% CONSTRUCTION DOCUMENTS

Project No.: 33348.001
Issued: 07/11/2018
Drawn By: G.Q.
Checked By: B.S.
Scale: AS SHOWN
Sheet Title: WALL SECTIONS
A4.2
Sheet Number

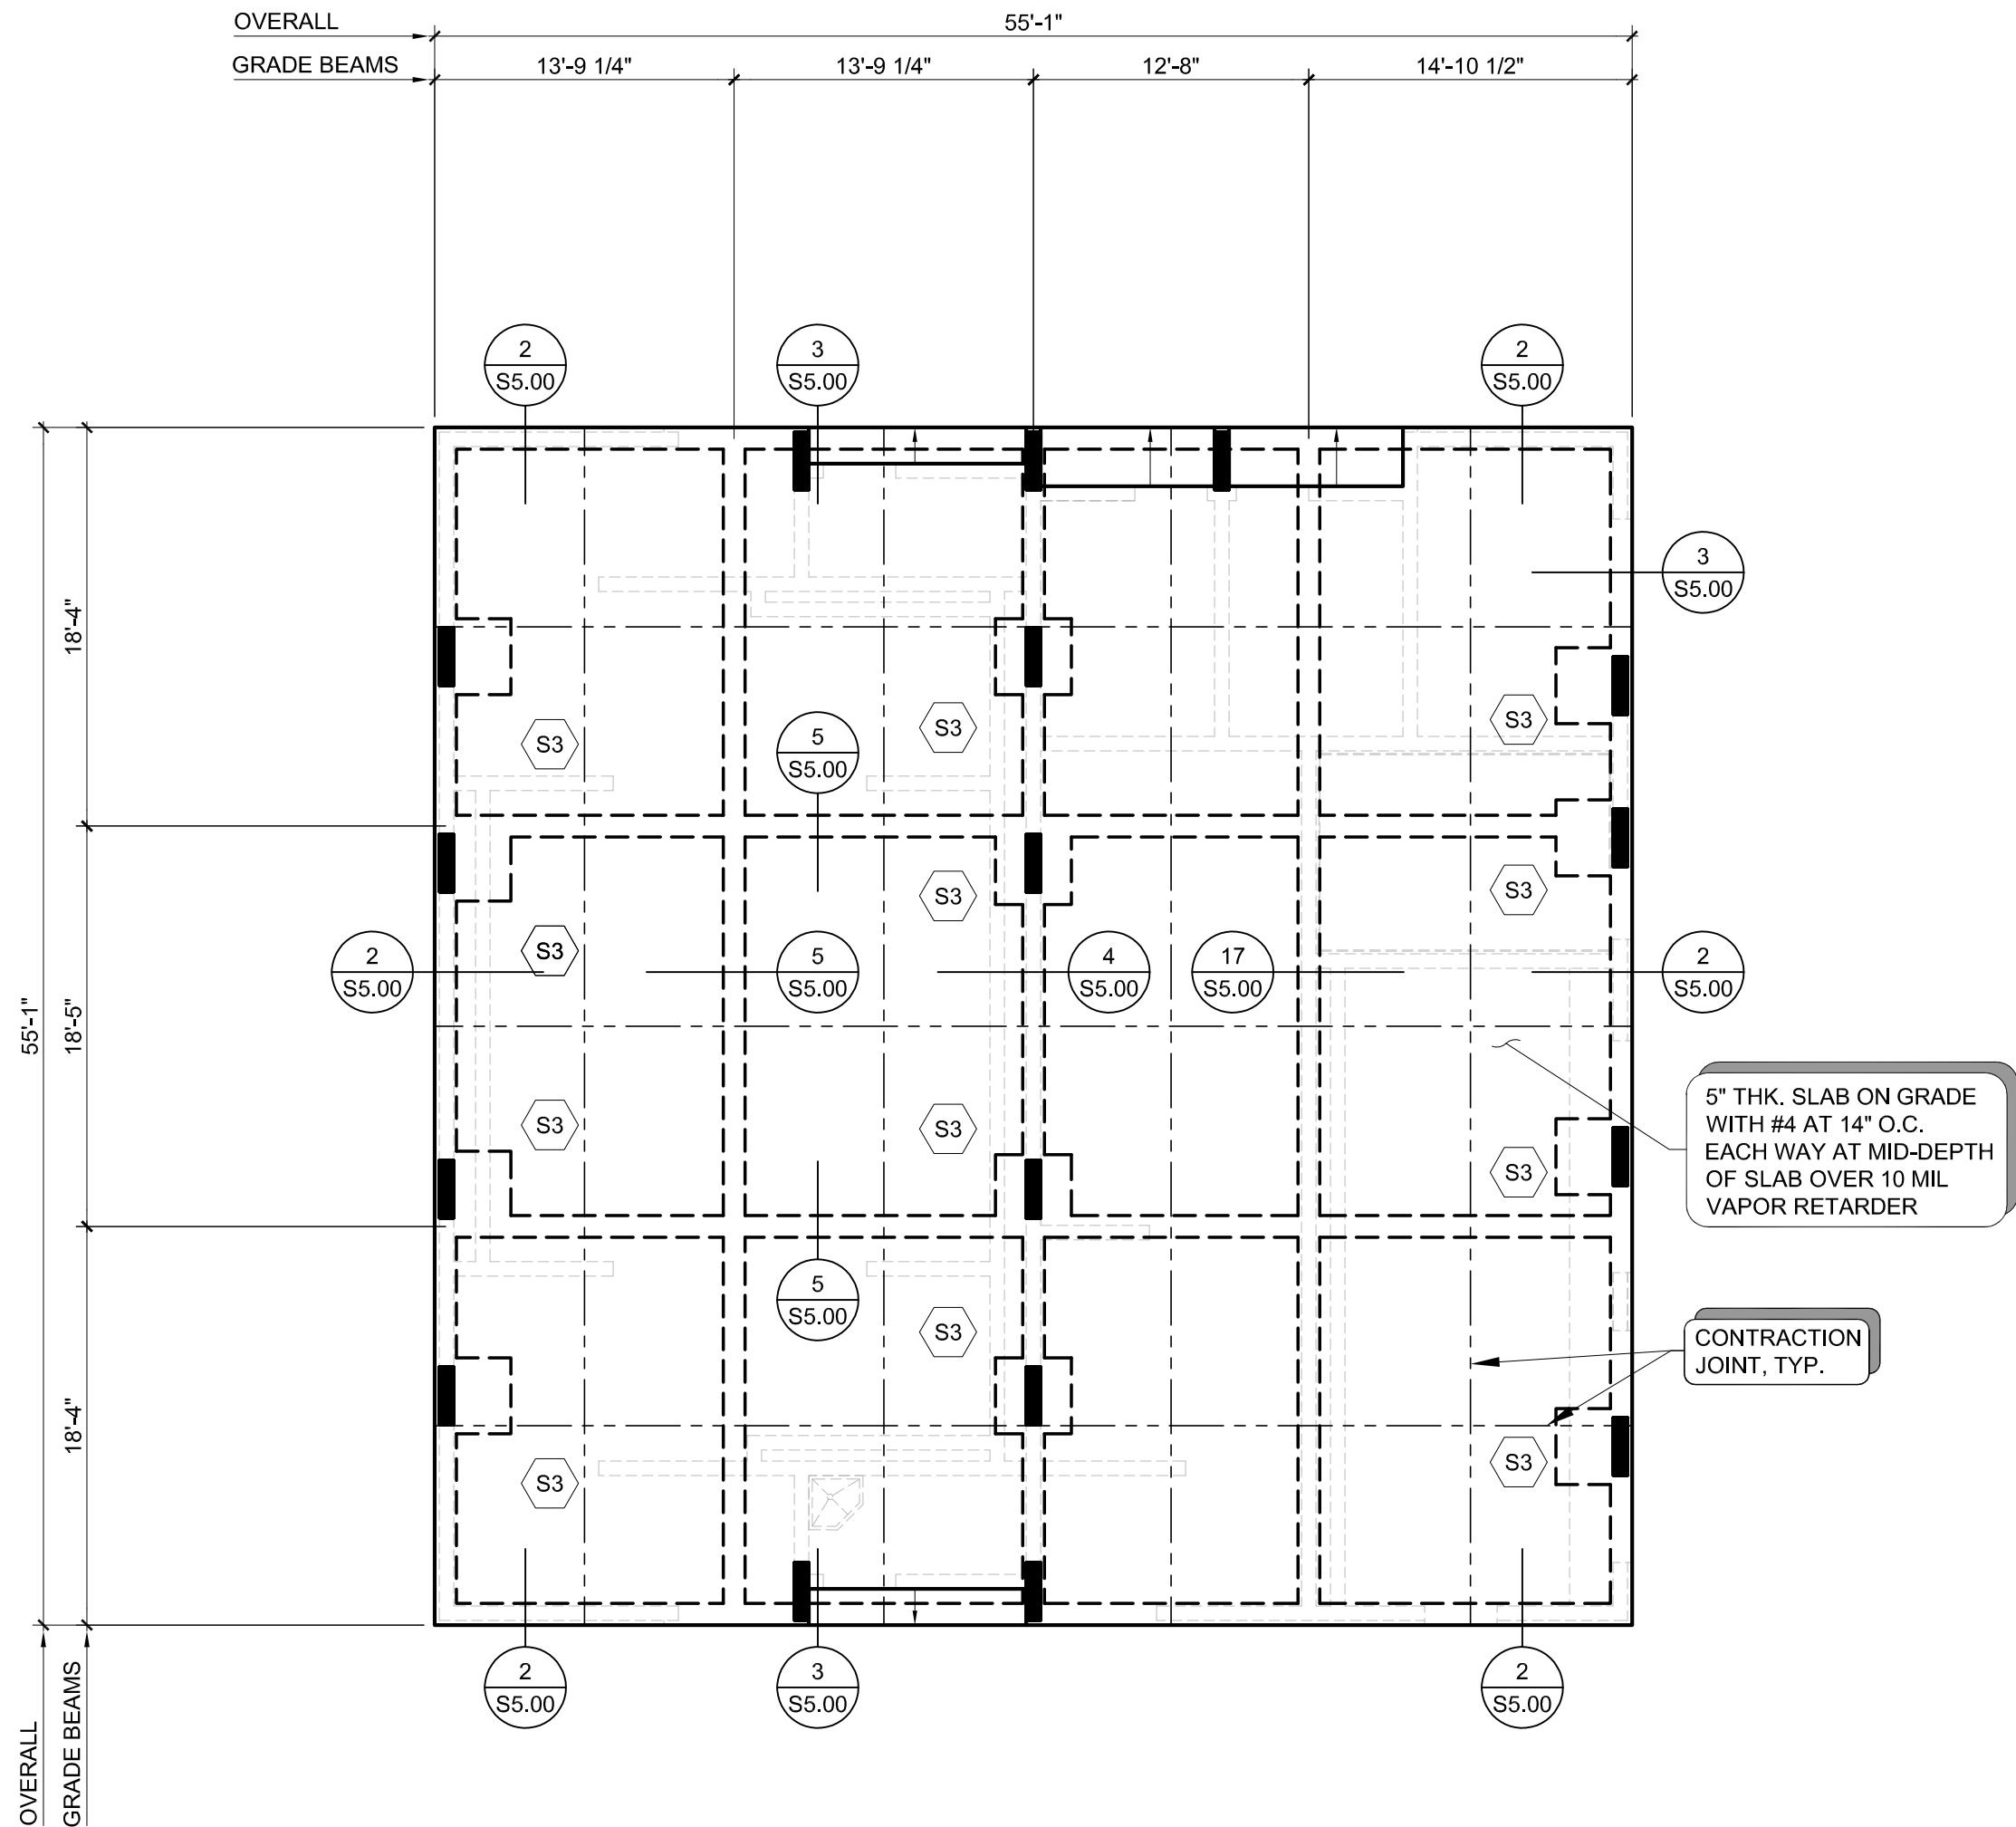


FOUNDATION NOTES:

1. CONTRACTOR TO VERIFY ALL DIMENSIONS WITH ARCHITECTURAL PLANS BEFORE COMMENCING WORK.
2. CONTRACTOR TO VERIFY LOCATION OF ANY/ALL DROPS AND DRAINS IN SLAB WITH ARCHITECTURAL DRAWINGS.
3. CONTRACTOR TO VERIFY REQUIRED F.F.E. WITH CIVIL ENGINEERING DRAWINGS.
4. REFER TO FOOTING SCHEDULE FOR FOOTING SIZE AND REINFORCEMENT, SEE DETAIL 8/S2.00.
5. FOR THICKENED SLAB UNDERNEATH ALL CMU WALLS SEE 9/S2.00.

FOUNDATION PLAN


SCALE: 1/8"=1'-0"

Revision No.	Date	Description
1	07-26-18	ADDENDUM #1

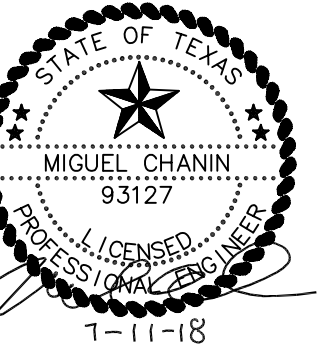

100%
CONSTRUCTION
DOCUMENTS

Project No.:	17325
Issued:	07/11/2018
Drawn By:	LR
Checked By:	MC
Scale:	AS SHOWN
Sheet Title	FOUNDATION/ CMU WALL PLANS
Sheet Number	S3.00


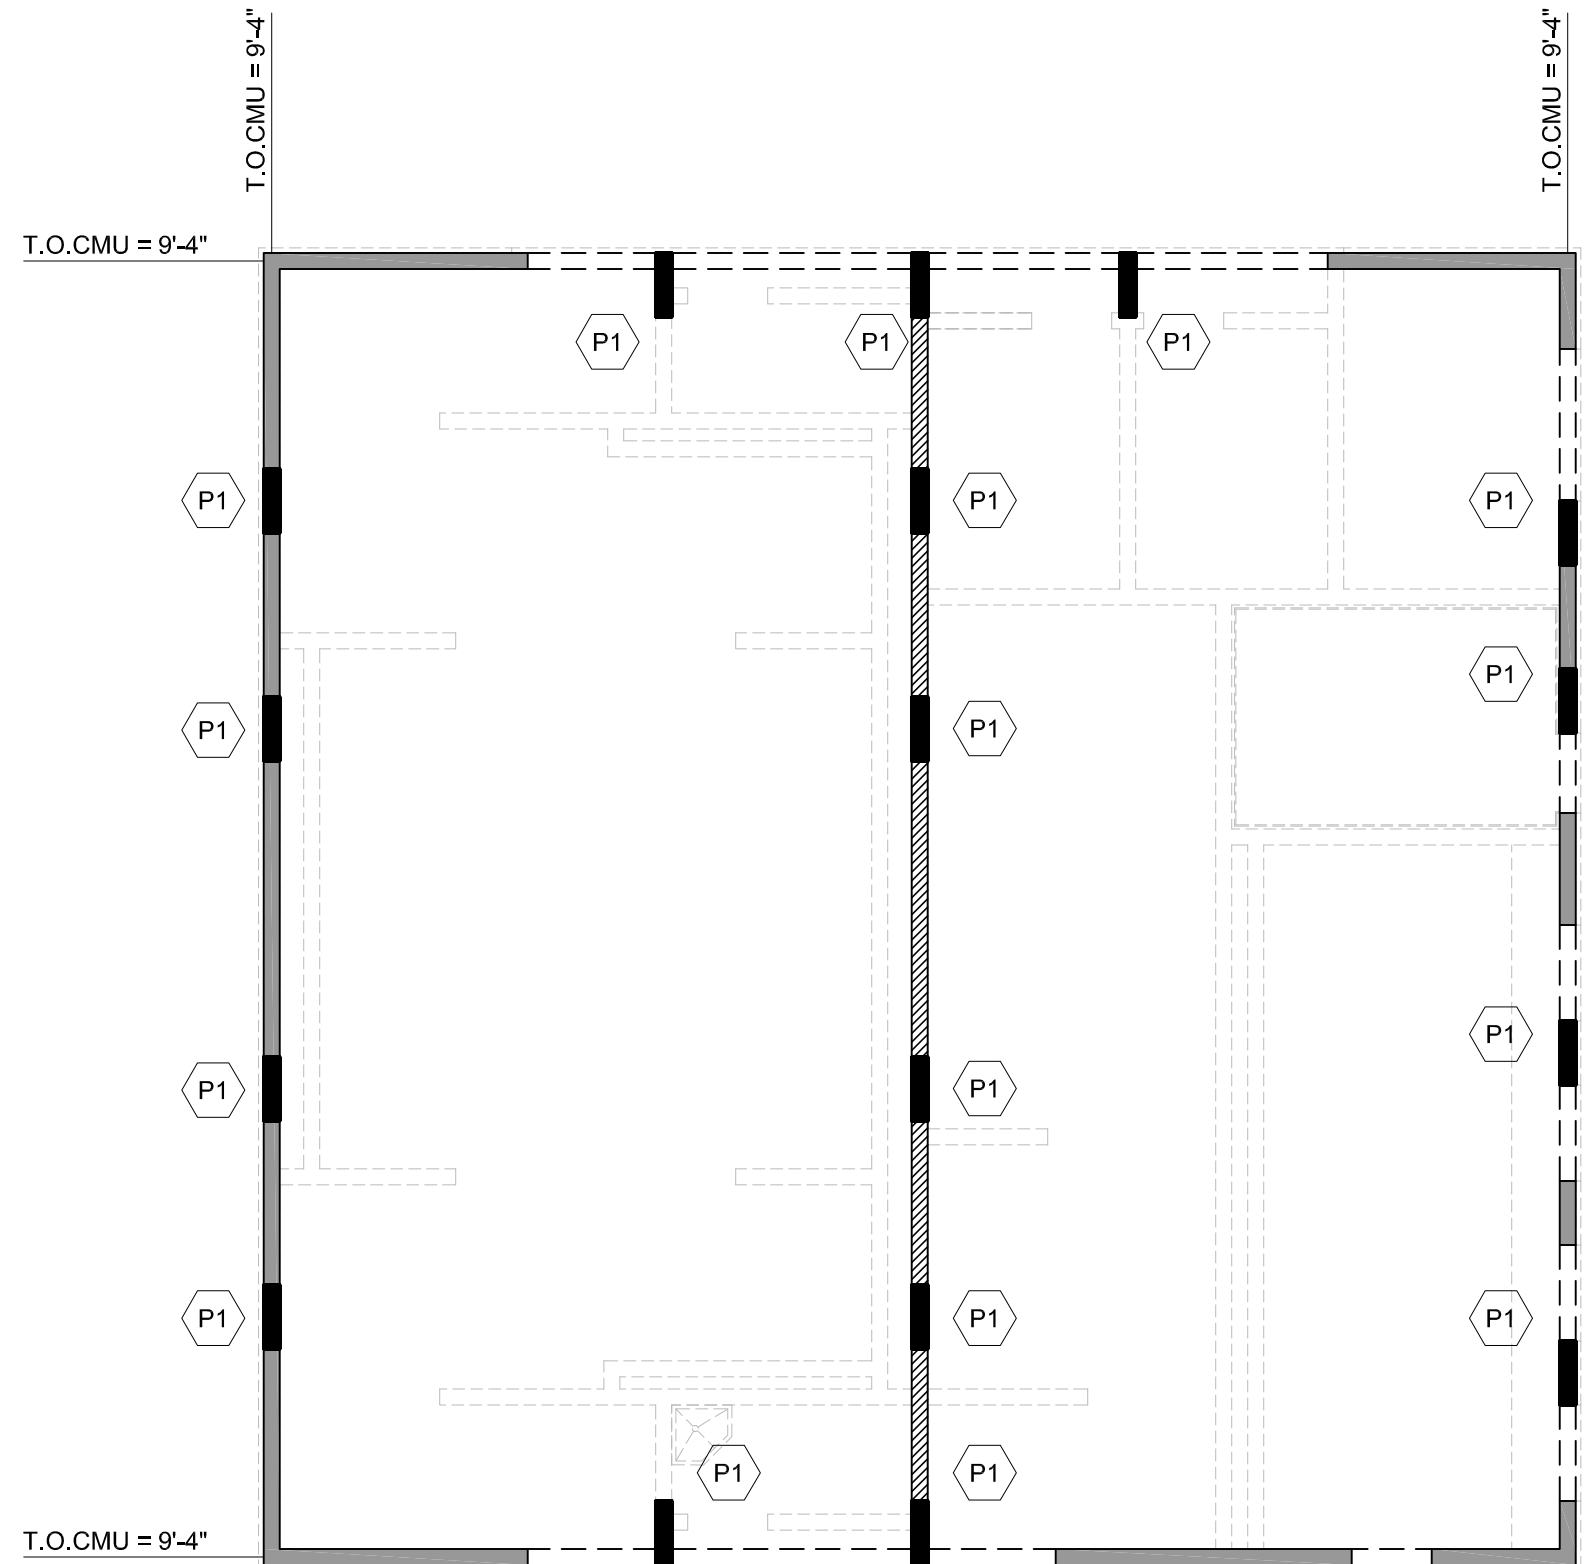


CMU WALL LAYOUT NOTES:


1. IF ANY DISCREPANCIES ARE FOUND BETWEEN THESE DRAWINGS AND THE ARCHITECTURAL DRAWINGS THE CONTRACTOR SHALL NOTIFY THE ARCHITECT AND ENGINEER BEFORE COMMENCING CONSTRUCTION.
2. FOR TYPICAL CMU WALL CONSTRUCTION SEE SHEET S2.01
3. INDICATES EXTERIOR 8" CMU WALL WITH #5 (V) AT 48" O.C. AND #5 (H) AT 8'-0" O.C., U.N.O.
4. INDICATES INTERIOR 8" CMU WALL WITH #5 (V) AT 48" O.C. AND #5 (H) AT 8'-0" O.C., U.N.O.
5. INDICATES LINTEL, SEE DETAIL 7/S2.01
6. ALL CMU WALLS ARE NOT HATCHED REFER TO GENERAL NOTES FOR REINFORCEMENT.
7. FOR SPECIAL INSPECTION REQUIREMENTS SEE GENERAL NOTES.
8. ALL TOP OF WALLS FROM FINISH FLOOR ELEVATION 0'-0".
9. SEE ARCHITECTURAL PLANS FOR EXACT LOCATION, LENGTH, AND HEIGHT OF ALL OPENINGS IN CMU WALLS.
10. FOR CONTROL JOINT LOCATIONS, SEE ARCHITECTURAL DRAWINGS.
11. PROVIDE CMU LINTEL OVER ALL MECHANICAL SYSTEM PENETRATIONS IN CMU WALL, COORDINATE WITH MEP DRAWINGS FOR ALL LOCATIONS.
12. 8" CMU WALL IS A NOMINAL DIMENSION, ACTUAL WIDTH IS 7 5/8".
13. INDICATES PILASTER P1, SEE DETAIL 10/S2.01

CMU WALL LAYOUT PLAN

SCALE: 1/8"=1'-0"

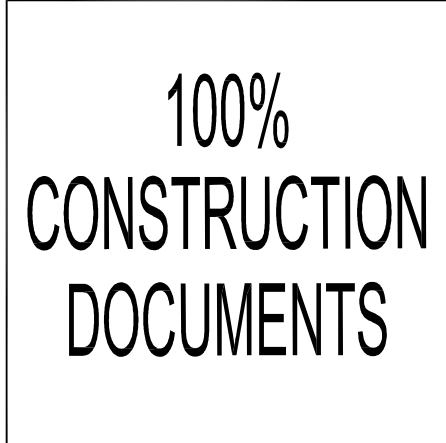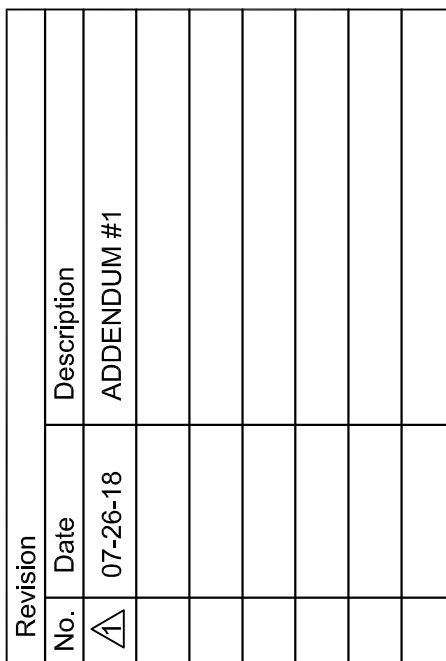

Project No.:	17325
Issued:	07/11/2018
Drawn By:	LR
Checked By:	MC
Scale:	AS SHOWN
Sheet Title	
FRAMING PLANS	
	
Sheet Number	

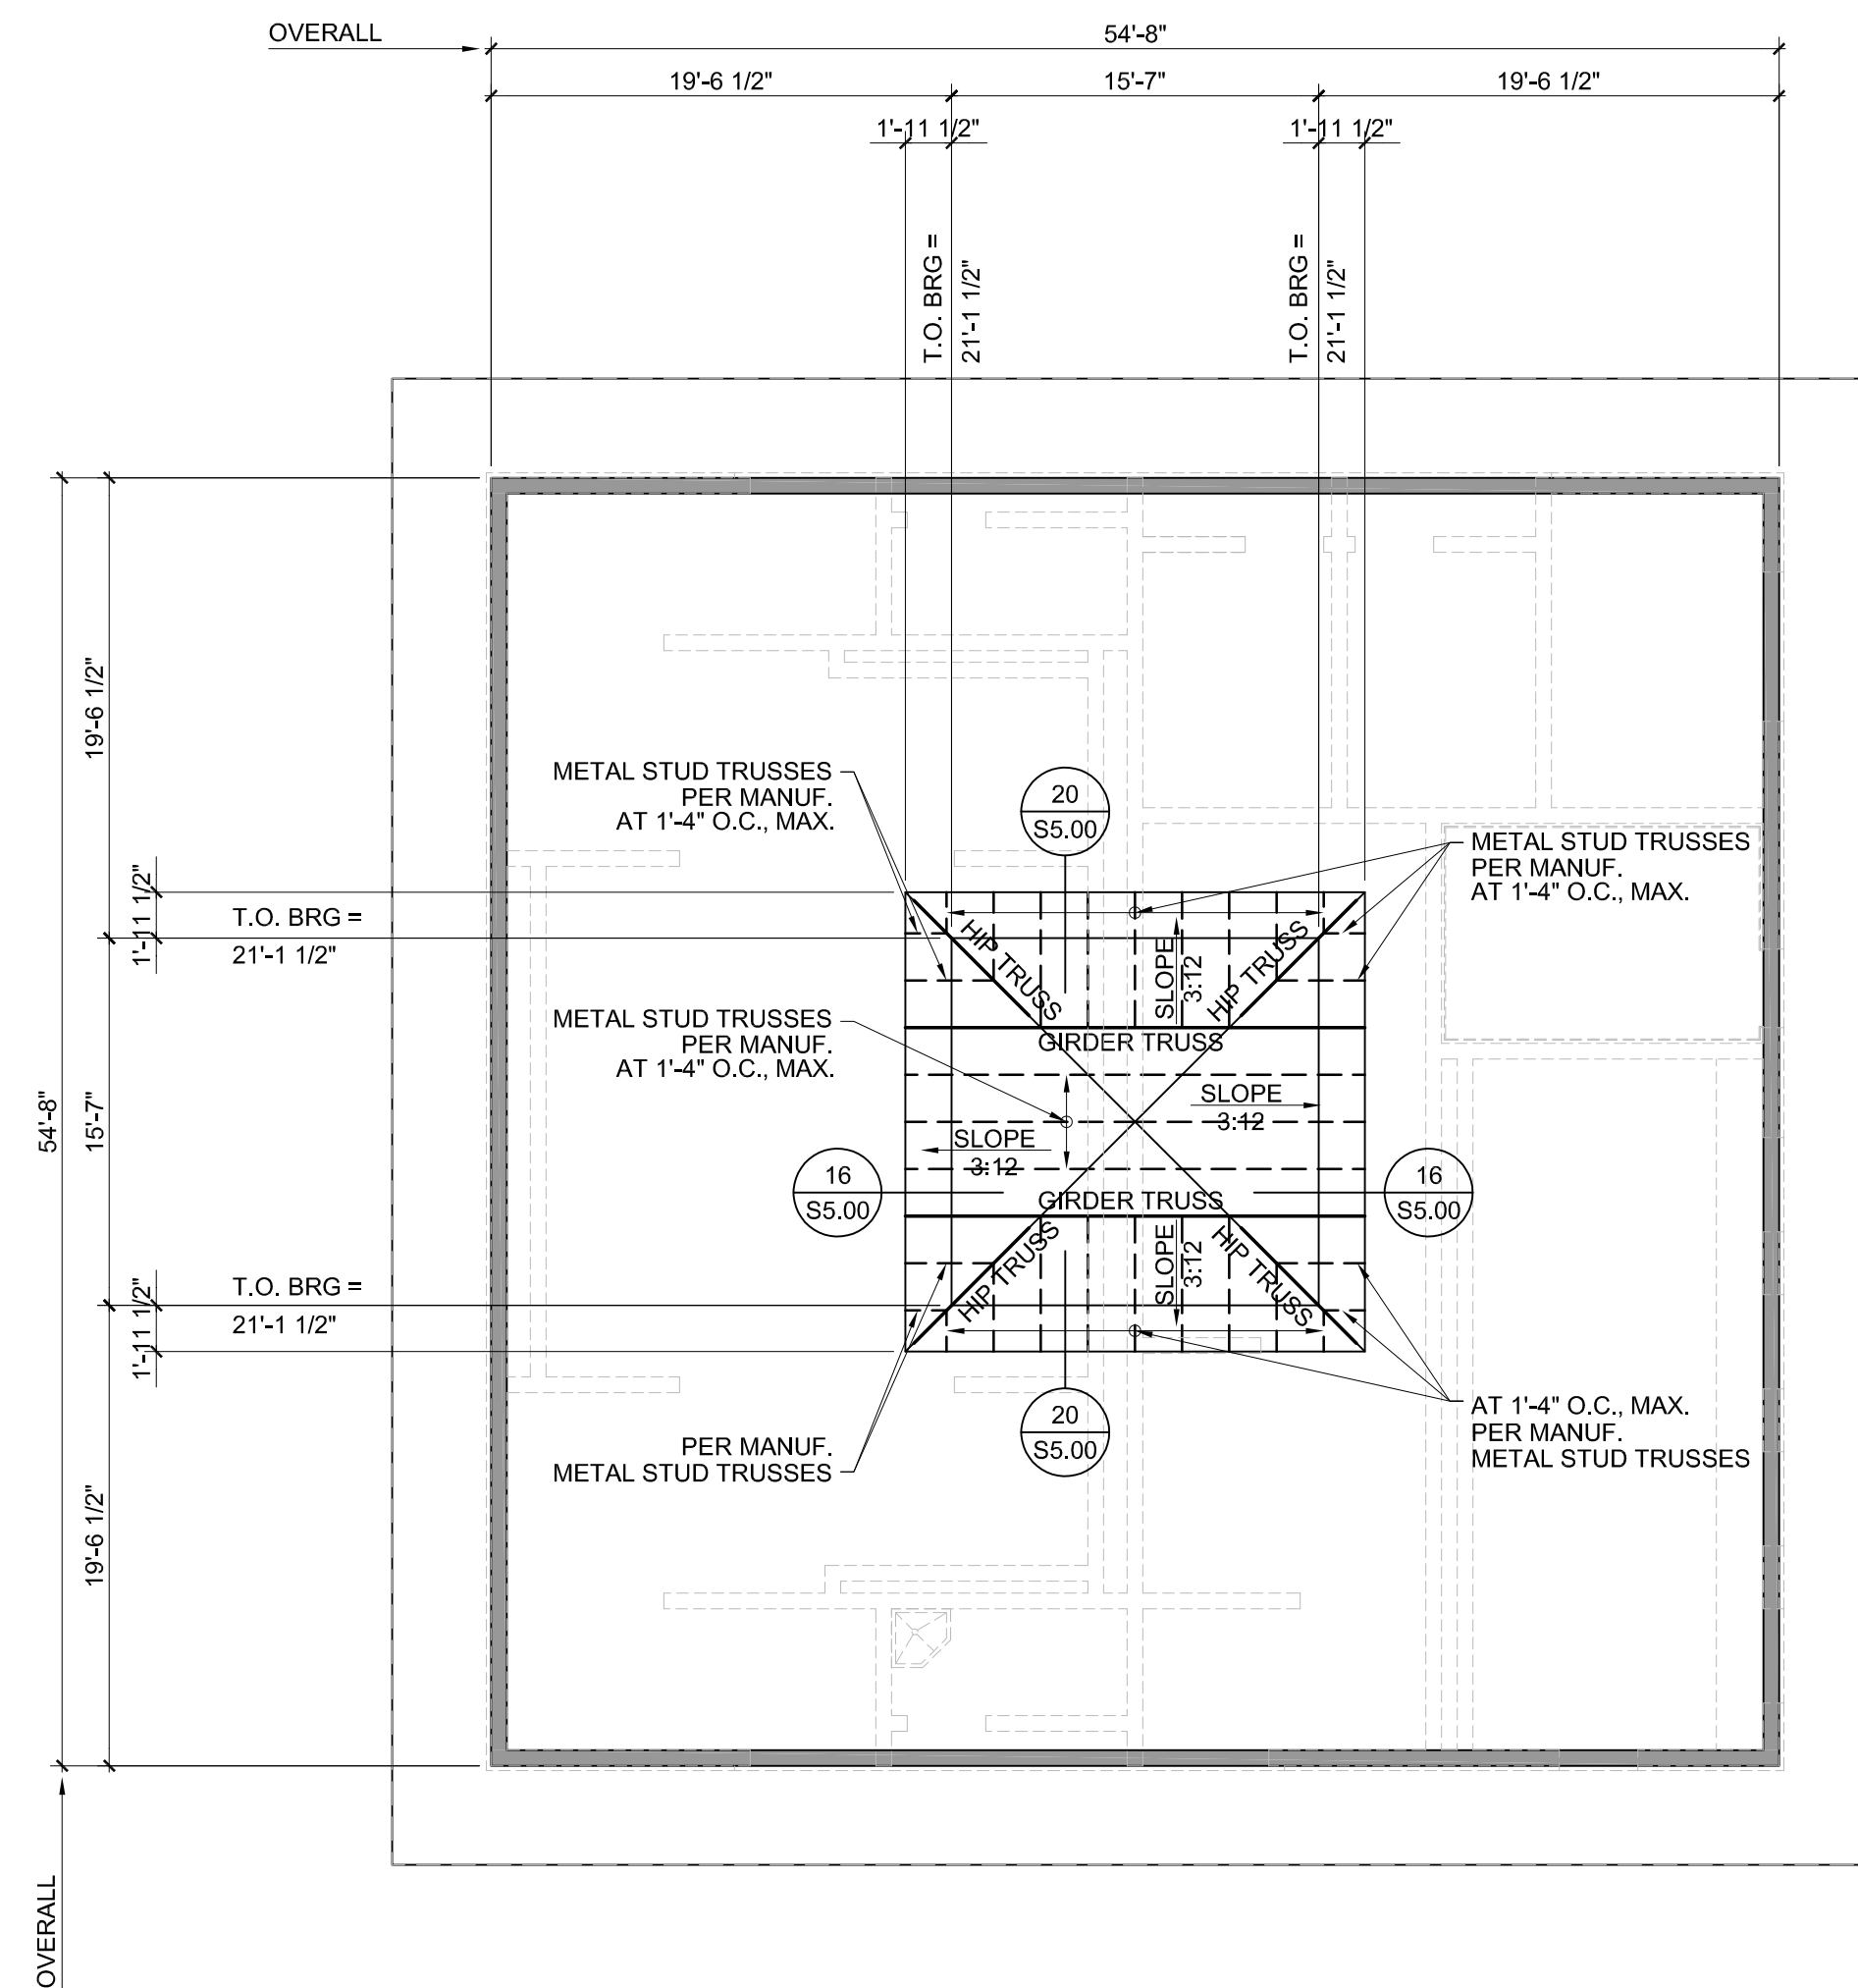


FRAMING NOTES:

1. CONTRACTOR TO VERIFY ALL DIMENSIONS WITH ARCHITECTURAL PLANS BEFORE COMMENCING WORK.
2. REFER TO ARCHITECTURAL DRAWINGS FOR ANY ADDITIONAL DIMENSIONS.
3. REFER TO ARCH'L PLANS FOR ROOF OVERHANG DIMENSION.
4. METAL STUD TRUSSES MANUFACTURER TO PROVIDE ADEQUATE BRIDGING FOR TRUSSES.
5. CONTRACTOR TO COORDINATE ALL MECHANICAL, ELECTRICAL AND PLUMBING COMPONENTS SUPPORTED BY THE STRUCTURE WITH THE STRUCTURE MANUFACTURER.
6. CONTRACTOR TO COORDINATE EXACT LOCATION AND SIZE OF ANY AND ALL ROOF HATCHES WITH ARCH'L DRAWINGS.
7. 8" CMU WALL IS A NOMINAL DIMENSION, ACTUAL WIDTH IS 7 5/8".
8. REFER TO M.E.P. DRAWINGS FOR ANY HOUSEKEEPING PADS AT MECHANICAL ROOMS.

HIGH ROOF FRAMING PLAN

SCALE: 1/8"=1'-0"

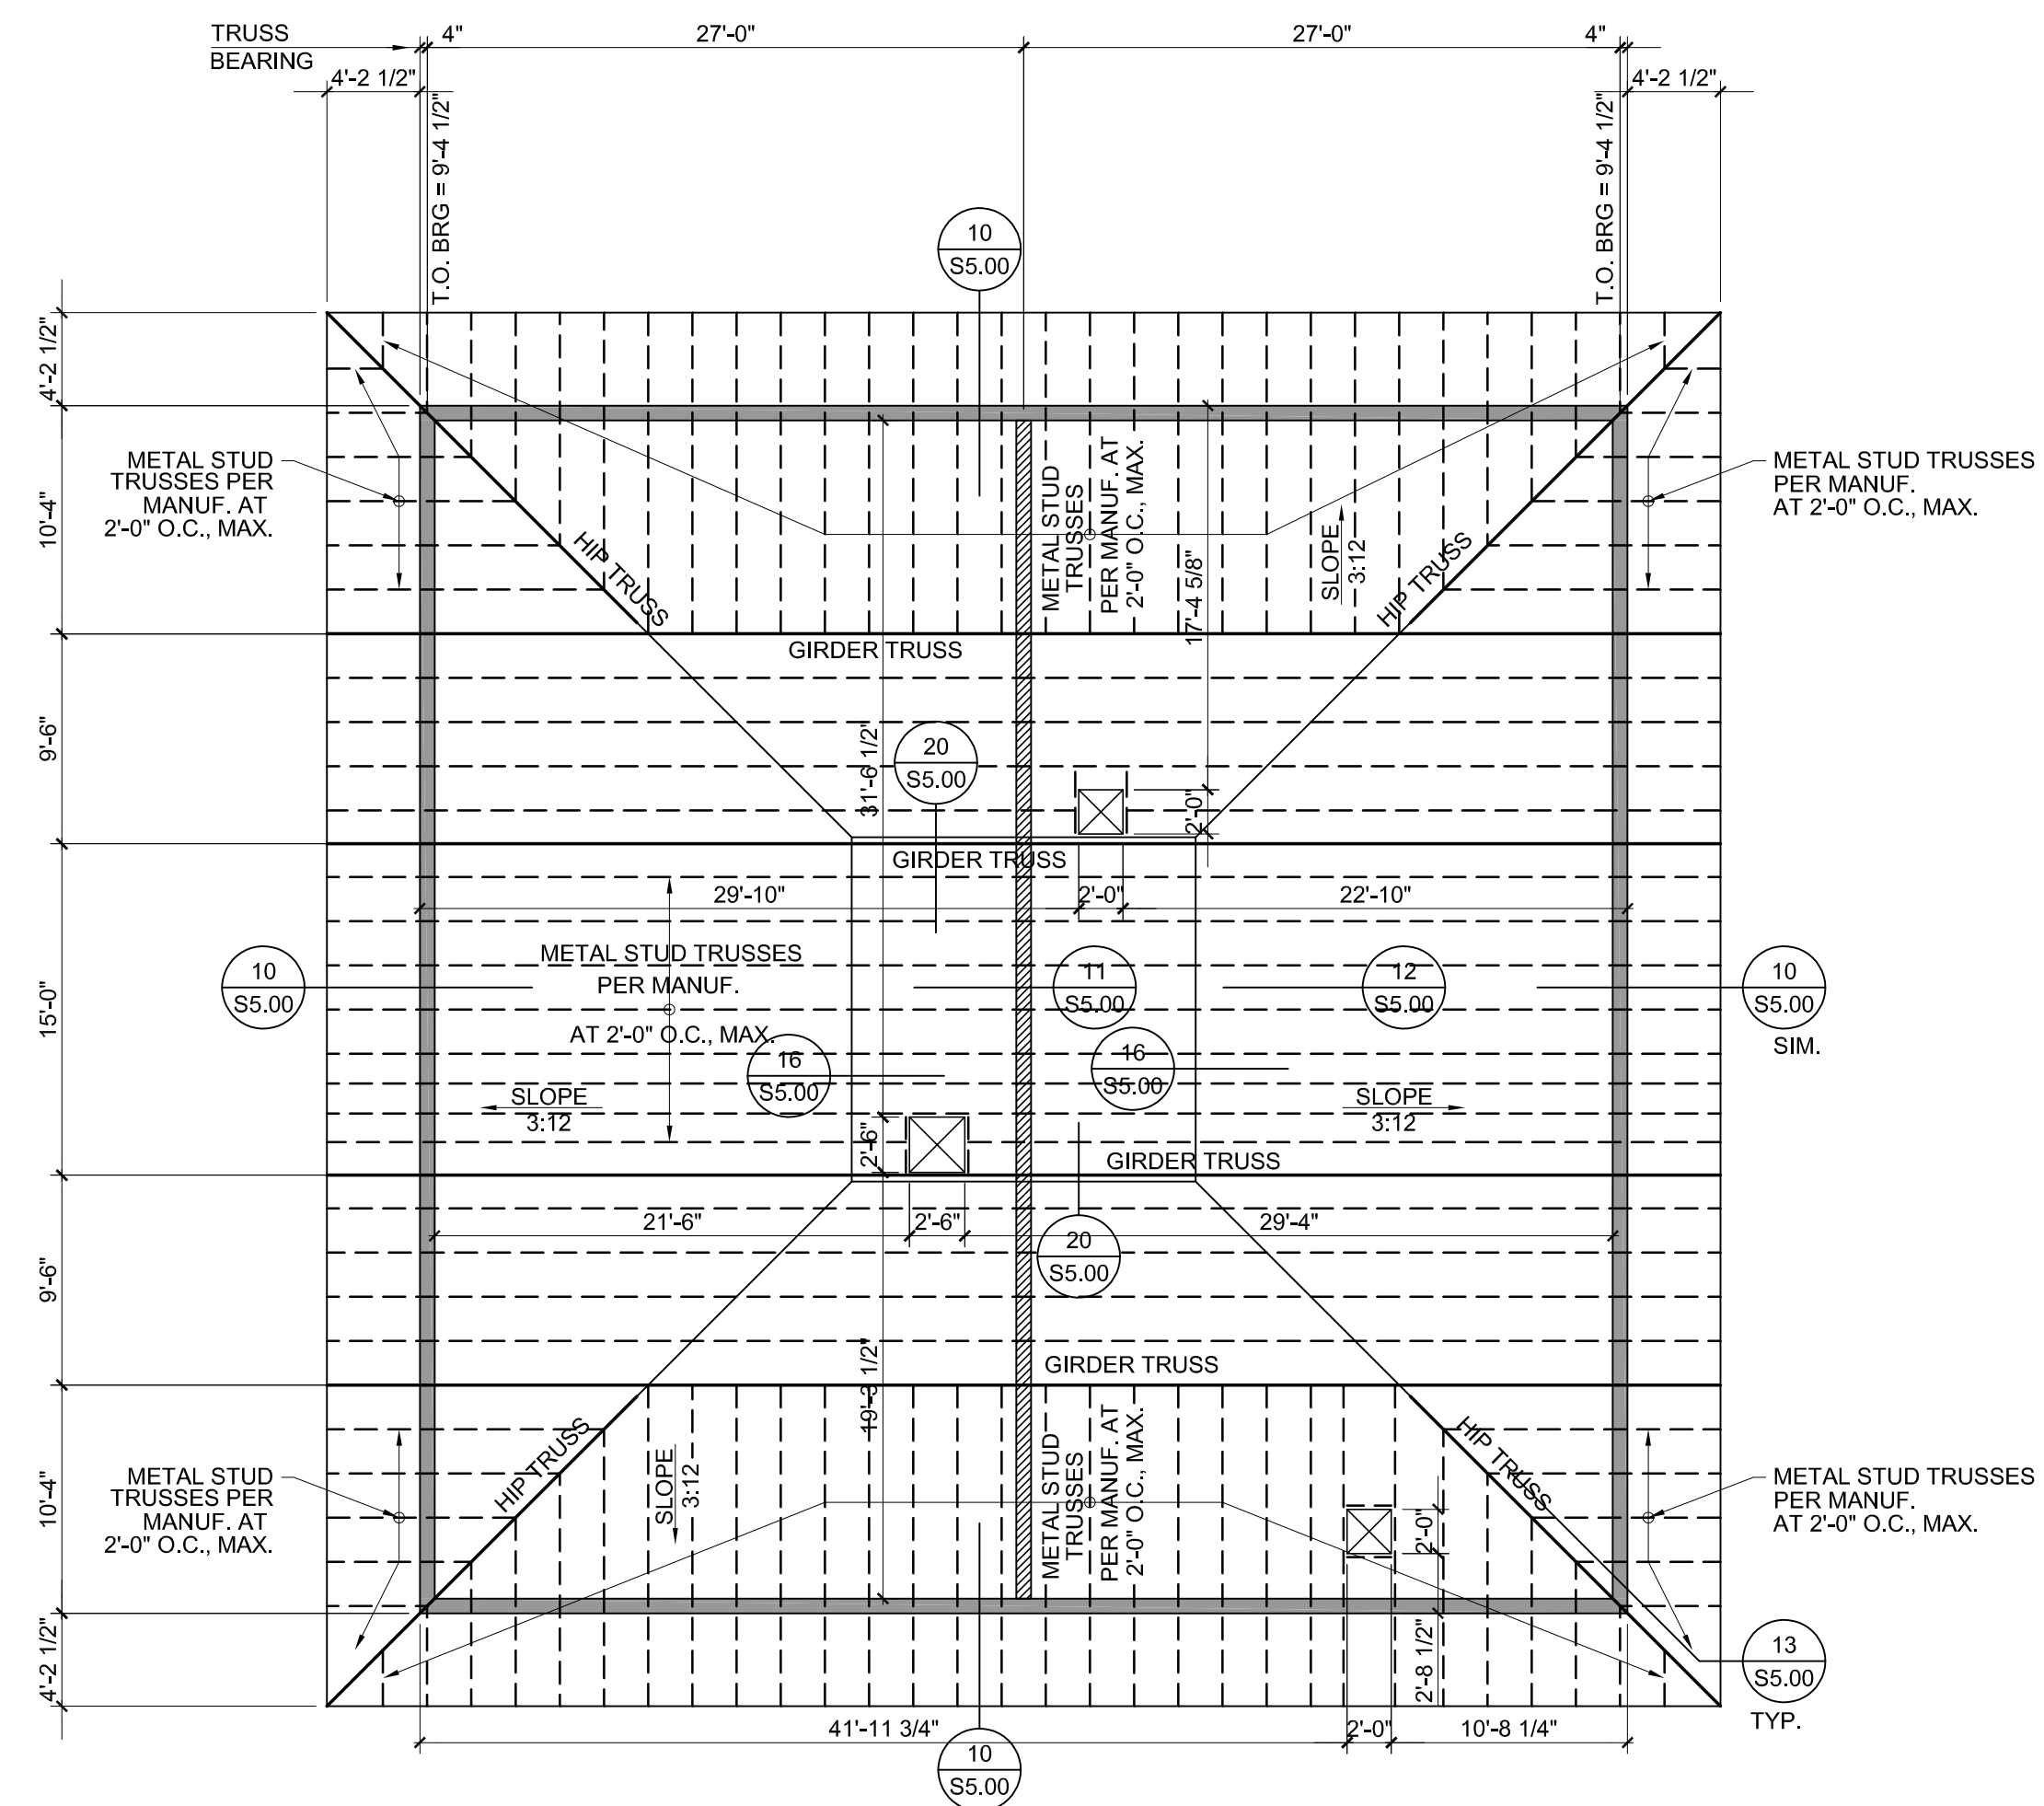


FRAMING NOTES:


1. CONTRACTOR TO VERIFY ALL DIMENSIONS WITH ARCHITECTURAL PLANS BEFORE COMMENCING WORK.
2. REFER TO ARCHITECTURAL DRAWINGS FOR ANY ADDITIONAL DIMENSIONS.
3. REFER TO ARCH'L PLANS FOR ROOF OVERHANG DIMENSION.
4. METAL STUD TRUSSES MANUFACTURER TO PROVIDE ADEQUATE BRIDGING FOR TRUSSES.
5. CONTRACTOR TO COORDINATE ALL MECHANICAL, ELECTRICAL AND PLUMBING COMPONENTS SUPPORTED BY THE STRUCTURE WITH THE STRUCTURE MANUFACTURER.
6. CONTRACTOR TO COORDINATE EXACT LOCATION AND SIZE OF ANY AND ALL ROOF HATCHES WITH ARCH'L DRAWINGS.
7. 8" CMU WALL IS A NOMINAL DIMENSION, ACTUAL WIDTH IS 7 5/8".
8. REFER TO M.E.P. DRAWINGS FOR ANY HOUSEKEEPING PADS AT MECHANICAL ROOMS.

ROOF FRAMING PLAN

SCALE: 1/8"=1'-0"

File Name: i:\33000s\33348\001\MEP\CADD\M1.01-PL-33348.dwg
Current Tab (Layout): M1.01 - User: AH5047
Printed Date: 7/25/2018 1:40:05 PM

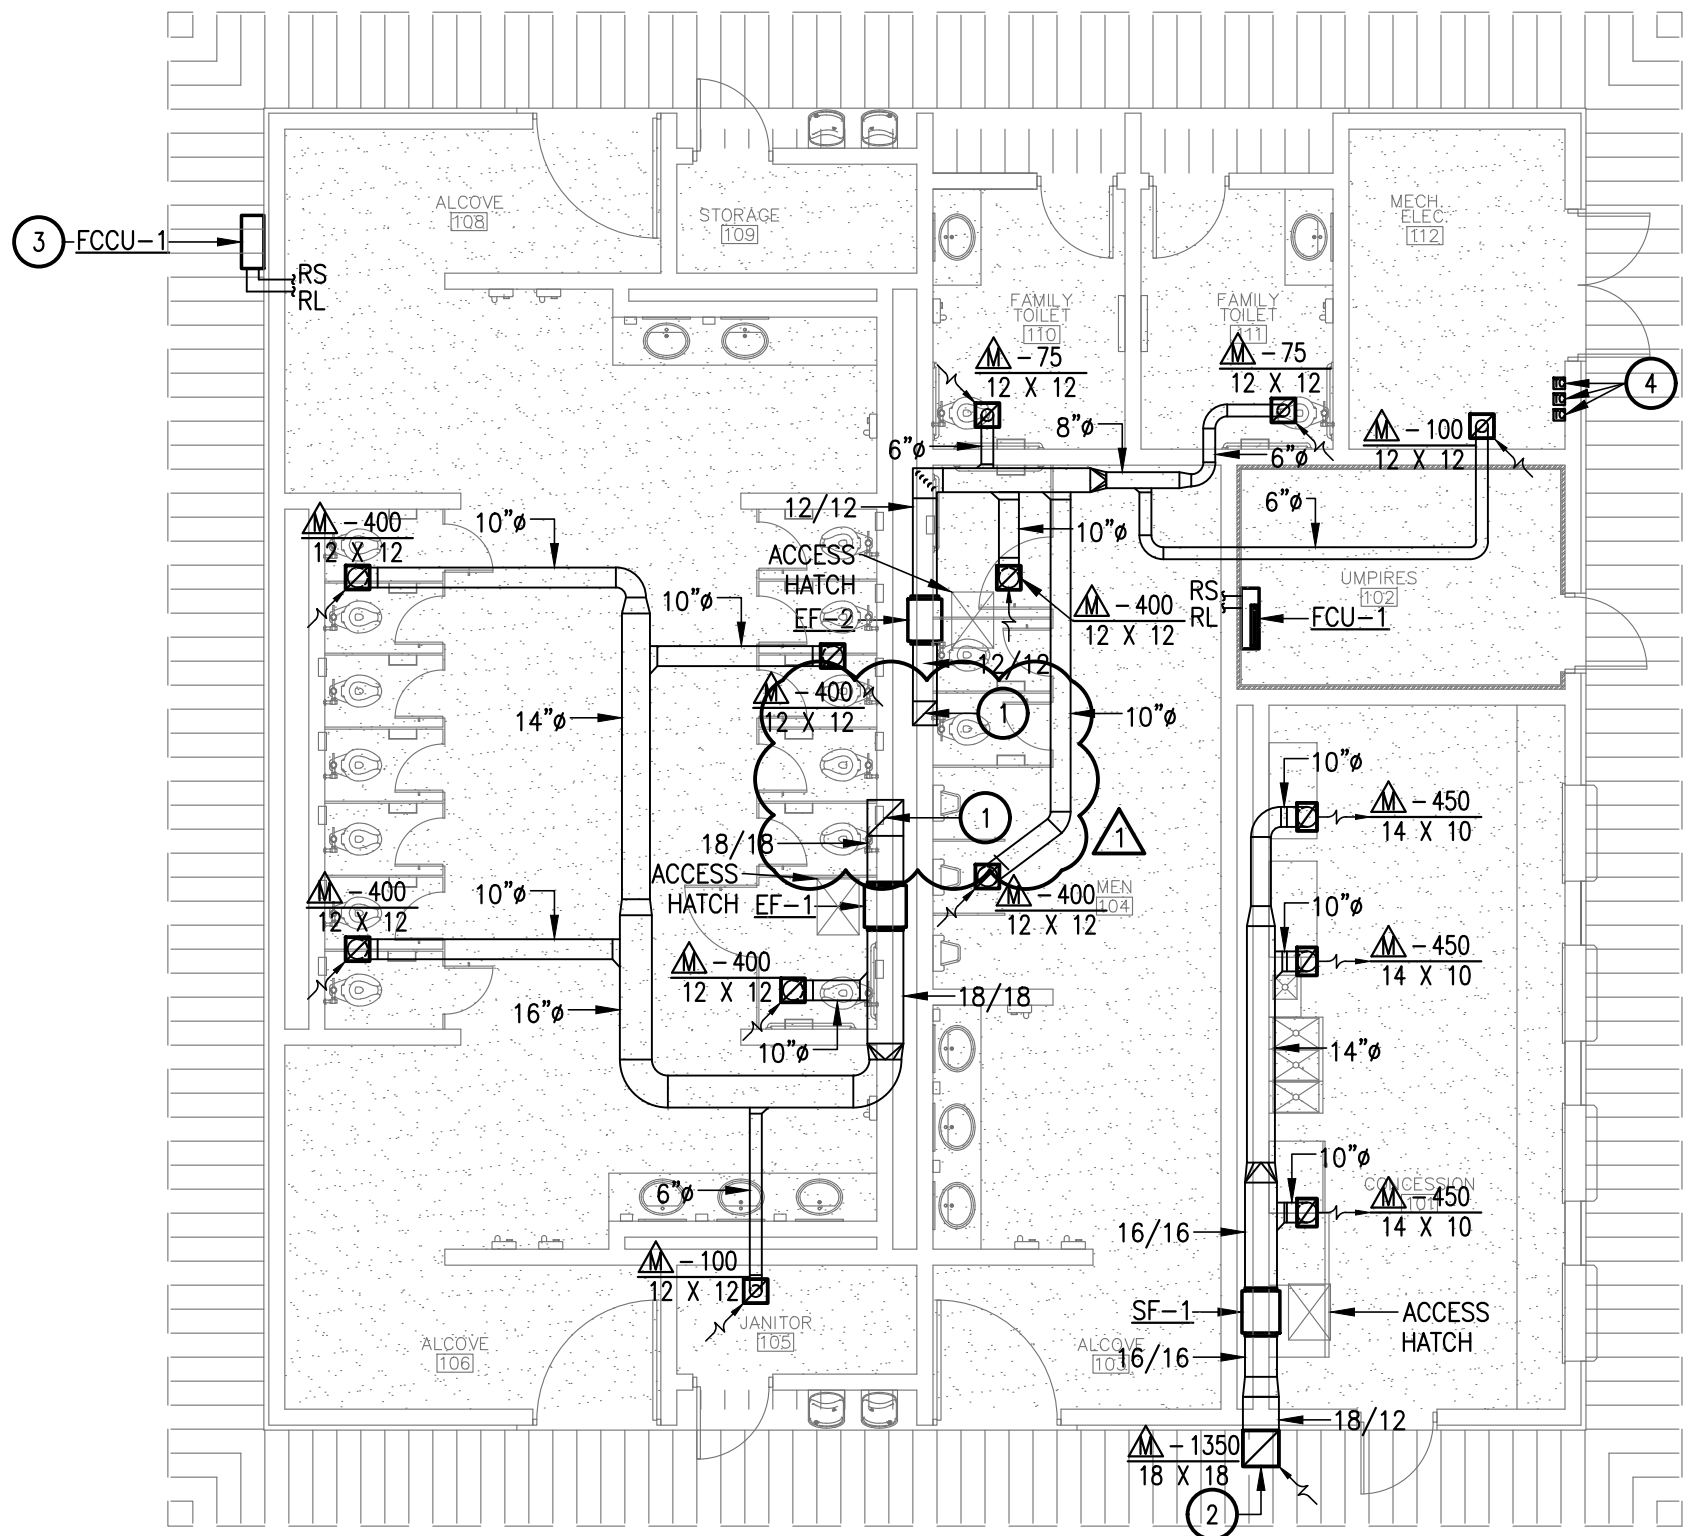

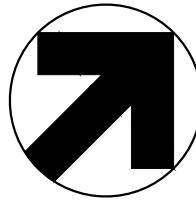 **01 MECHANICAL PLAN**
SCALE: 1/8" = 1'-0"

GENERAL NOTES:

A. REFER TO SHEET M0.01 FOR MECHANICAL GENERAL NOTES.

KEY NOTES:

1. TURN EXHAUST DUCT UP TOWARDS CUPOLA AND TERMINATE IN 1/2" MESH BIRDSCREEN.
2. MOUNT INTAKE GRILL IN SOFFIT PANEL. CUSTOM COLOR TO MATCH SOFFIT.
3. CONTRACTOR SHALL INSTALL CONDENSING UNIT ON WALL. TOP OF CONDENSING UNIT SHALL BE 1" BELOW SOFFIT. REFER TO SHEET M2.01 DETAIL 04.
4. CONTRACTOR SHALL INSTALL TIME CLOCK CONTROLLERS, ONE PER EXHAUST FAN, EQUAL TO TORK #DG100A. REFER TO ELECTRICAL SHEET E1.04

CITY OF MCALLEN
SOFTBALL FIELD FACILITIES
MUNICIPAL PARK
MCALLEN, TEXAS



Revision No.	Date	Description
1	7-26-2018	Addendum #1




**100%
CONSTRUCTION
DOCUMENTS**


Project No.:	33348
Issued:	07-11-18
Drawn By:	K.G.J.B
Checked By:	H.A.
Scale:	AS NOTED
Sheet Title	MECHANICAL PLAN
Sheet Number	M1.01

FAN SCHEDULE														
MARK	CFM	SERVICE	TYPE	RPM	EXT SP (IN WG)	MOTOR SIZE HP	BHP	DRIVE	VOLTAGE	MAX. SONES	WEIGHT (LBS)	MANUFACTURER	MODEL	NOTES
EF-1	1700	WOMENS	INLINE	1469	0.5	3/4	0.4	DIRECT	115	11.3	59	GREENHECK	SQ-130-VG	ALL
EF-2	1050	MENS/FAMILY/ELEC	INLINE	1558	0.5	1/4	0.2	DIRECT	115	9.2	45	GREENHECK	SQ-100-VG	ALL
SF-1	1300	CONCESSION	INLINE	1427	0.5	1/2	0.3	DIRECT	115	9.3	55	GREENHECK	SQ-120-VG	ALL
NOTES														
1. FAN SHALL HAVE FACTORY INSTALLED, PRE-WIRED INTEGRAL DISCONNECT SWITCH FROM FACTORY.														
2. FAN SHALL BE PROVIDED WITH FACTORY-MOUNTED SPEED CONTROL.														
3. EACH FAN SHALL BE CONTROLLED THROUGH INDIVIDUAL TIME CLOCK. MODEL:TORK #DG100A. REFER TO ELECTRICAL PLANS.														
GENERAL NOTES, TYPICAL OF ALL FANS:														
A. CONTRACTOR SHALL CONFIRM DUCT PENETRATIONS, CURB DIMENSIONS, WEIGHT SHALL NOT EXCEED SCHEDULED PRODUCT.														
B. ALL FANS INCLUDE DRIVE LOSSES. SUPPLIER SHALL PROVIDE DRIVE LOSS CALCULATIONS WITH EACH FAN DURING SUBMITTALS.														
C. SOUND POWER LEVELS/SONES AND FAN RPM SHALL NOT EXCEED SCHEDULED VALUES.														


GRILLE/DIFFUSER/REGISTER SCHEDULE					
MARK	SERVICE	DESCRIPTION	MANUFACTURER MODEL NO.	MAX. NO. LEVEL (1)	REMARKS
M	EXHAUST	HEAVY DUTY SURFACE MOUNTED ALUMINUM EXHAUST GRILLE WITH 1/2" BLADE SPACING AND 0" FIXED DEFLECTION.	TITUS 60FL	30	COLOR BY ARCHITECT
F		=THIS WILL DESIGNATE A STEEL FIRE RATED AIR DEVICE TYPE.			NECK/FLEXIBLE
		AIR OUTLET DESIGNATION ON PLANS	CAPACITY	FACE	CONNECTION
			0-150	6 X 6	6"
			151-285	9 X 9	8"
			286-440	12 X 12	10"
			441-550	12 X 12	12"
			551-750	15 X 15	14"
			750-1000	18 X 18	16"
NOTE: COORDINATE ALL AIR DEVICE TYPE WITH ARCHITECTURAL RCP.					

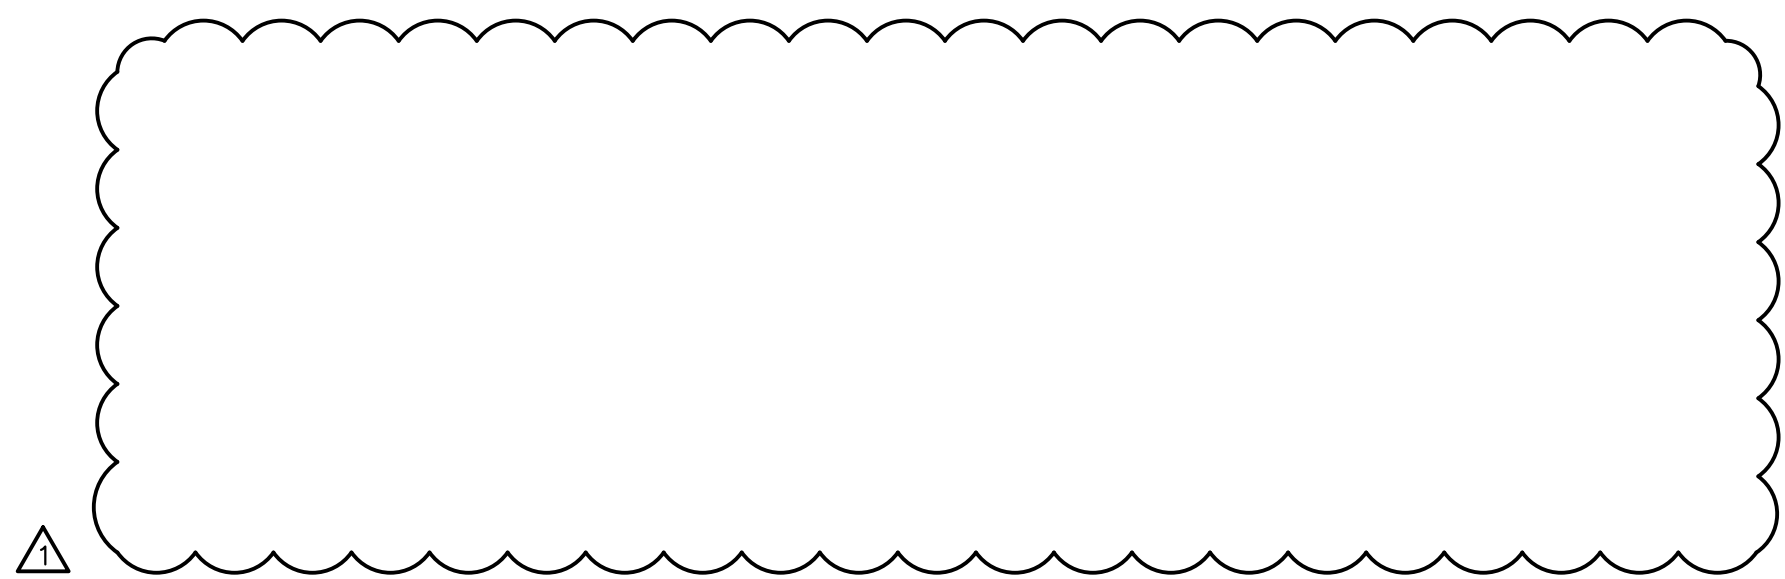


WALL MOUNT SPLIT SYSTEM SCHEDULE	
INDOOR UNIT MARK	FCCU-1
INDOOR UNIT TYPE	WALL
MAX SUPPLY CFM	328
MINIMUM O/A (CFM)	N/A
ENTERING AIR (DB/WB)	80/67
TOTAL COOLING CAP. (BTUH)	10900
SENSIBLE COOLING CAP. (BTUH)	9480
HEATING CAPACITY (BTUH)	13500
VOLTAGE/PHASE	208-230/1
MCA	N/A
MAX. FUSE SIZE	N/A
MANUFACTURER	DAIKIN
MODEL NO.	FTX12NMVJU
WEIGHT (LBS)	18
CONDENSING UNIT MARK	
VOLTAGE/PHASE	FCCU-1
MCA	208-230/1
MAX. FUSE SIZE	12.2
AMB. AIR TEMP. (CLG°F/HTG°F)	15
REFRIGERANT	95/47
COOLING AMBIENT RANGE	R-410A
HEATING MODE OPER. RANGE	(-4°F) - 115°F
MANUFACTURER	5°F - 75°F
MODEL NO.	DAIKIN
WEIGHT (LBS)	RX12NMVJU
SEER	60
HTG EFF. (HSPF)	19
MAX LINE LENGTH (FT)	8.5
MAX. VERTICAL RISE (FT)	66
	49
NOTES	ALL
NOTES:	
1. ELECTRICAL CONTRACTOR TO PROVIDE SINGLE CIRCUIT POWER FROM SERVICE TO OUTDOOR UNIT AND WIRE TO INDOOR UNIT.	
2. PROVIDE INDOOR UNITS WITH MOUNTING BRACKETS IF REQUIRED.	
3. PROVIDE CONDENSER COIL CORROSION PROTECTION.	
4. CONTRACTOR TO PROVIDE PAD OR CURB FOR MOUNTING CONDENSING UNIT.	
5. BOTH LIQUID AND SUCTION LINES MUST BE INSULATED (1/2" FLEXIBLE ELASTOMERIC IS ACCEPTABLE UNLESS INDICATED OTHERWISE IN SPECIFICATIONS).	
6. SIGHT GLASSES, FILTER DRYERS, AND FIELD SUPPLIED EXPANSION VALVES ARE NOT TO BE USED.	
7. PROVIDE INVERTER DRIVEN COMPRESSOR FOR IMPROVED HUMIDITY CONTROL.	
8. INSTALL PER MANUFACTURERS INSTRUCTIONS AND PIPING RECOMMENDATIONS.	
9. PROVIDE WALL MOUNTED AND WIRED 7-DAY PROGRAMMABLE T-STAT.	
10. 2 YEAR PARTS & 10 YEAR COMPRESSOR PART WARRANTY	

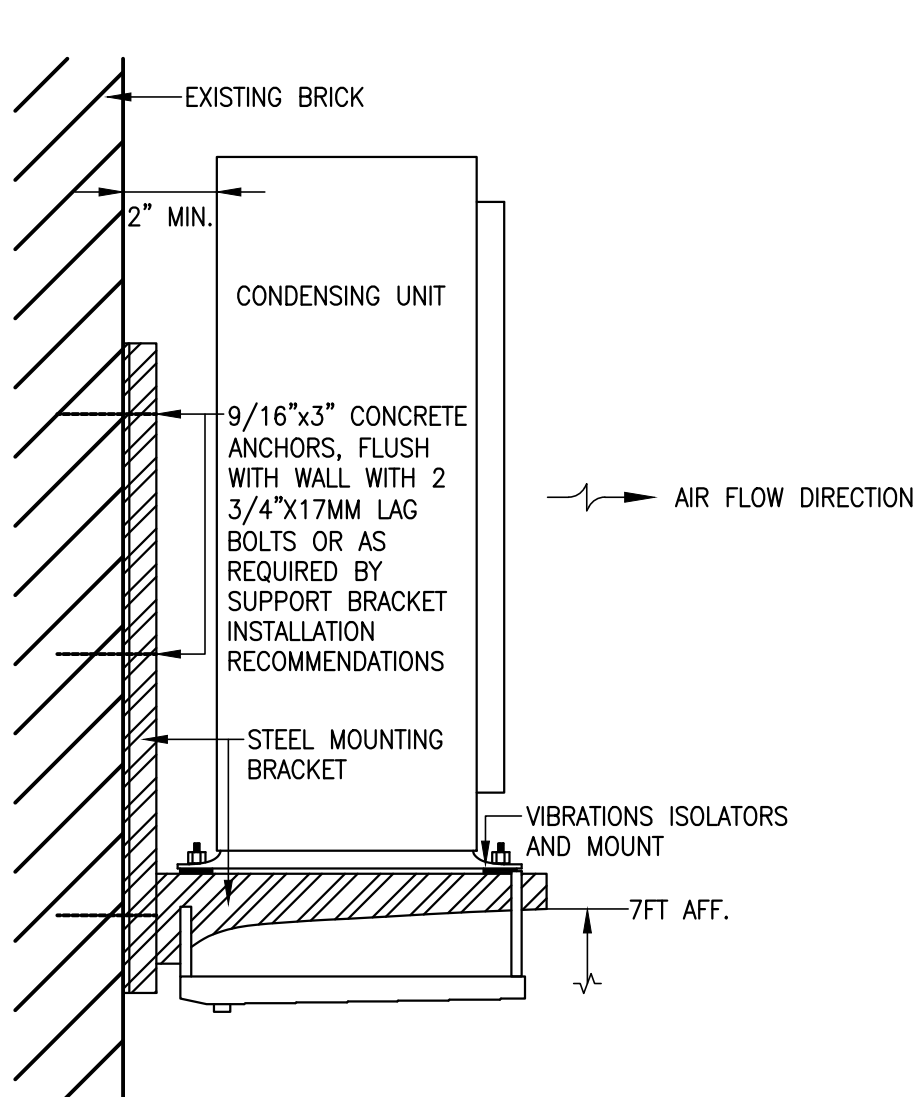


04 WALL MOUNTED CONDENSING UNIT
SCALE: N.T.S.

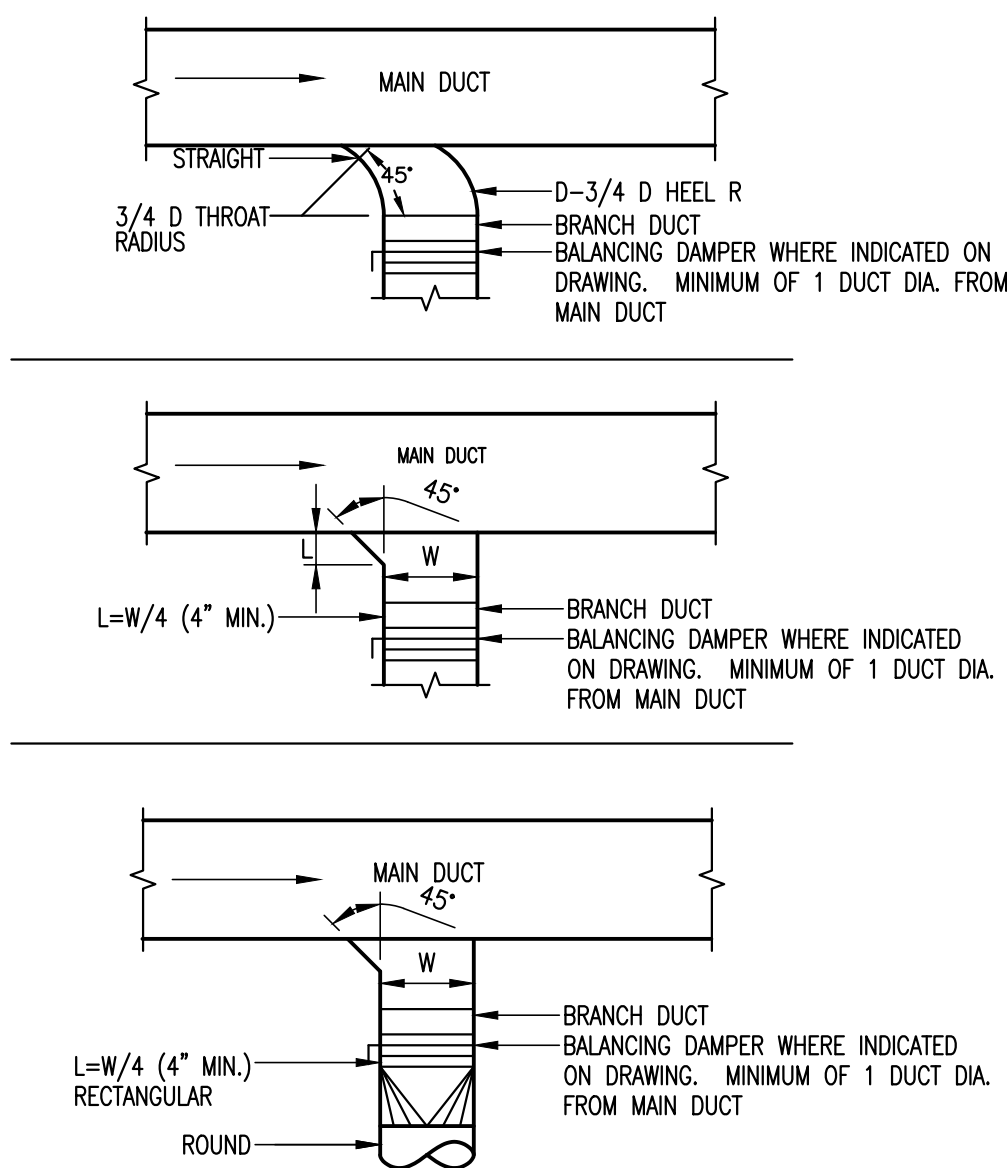

03 TYPICAL BRANCH CONNECTION
SCALE: N.T.S.

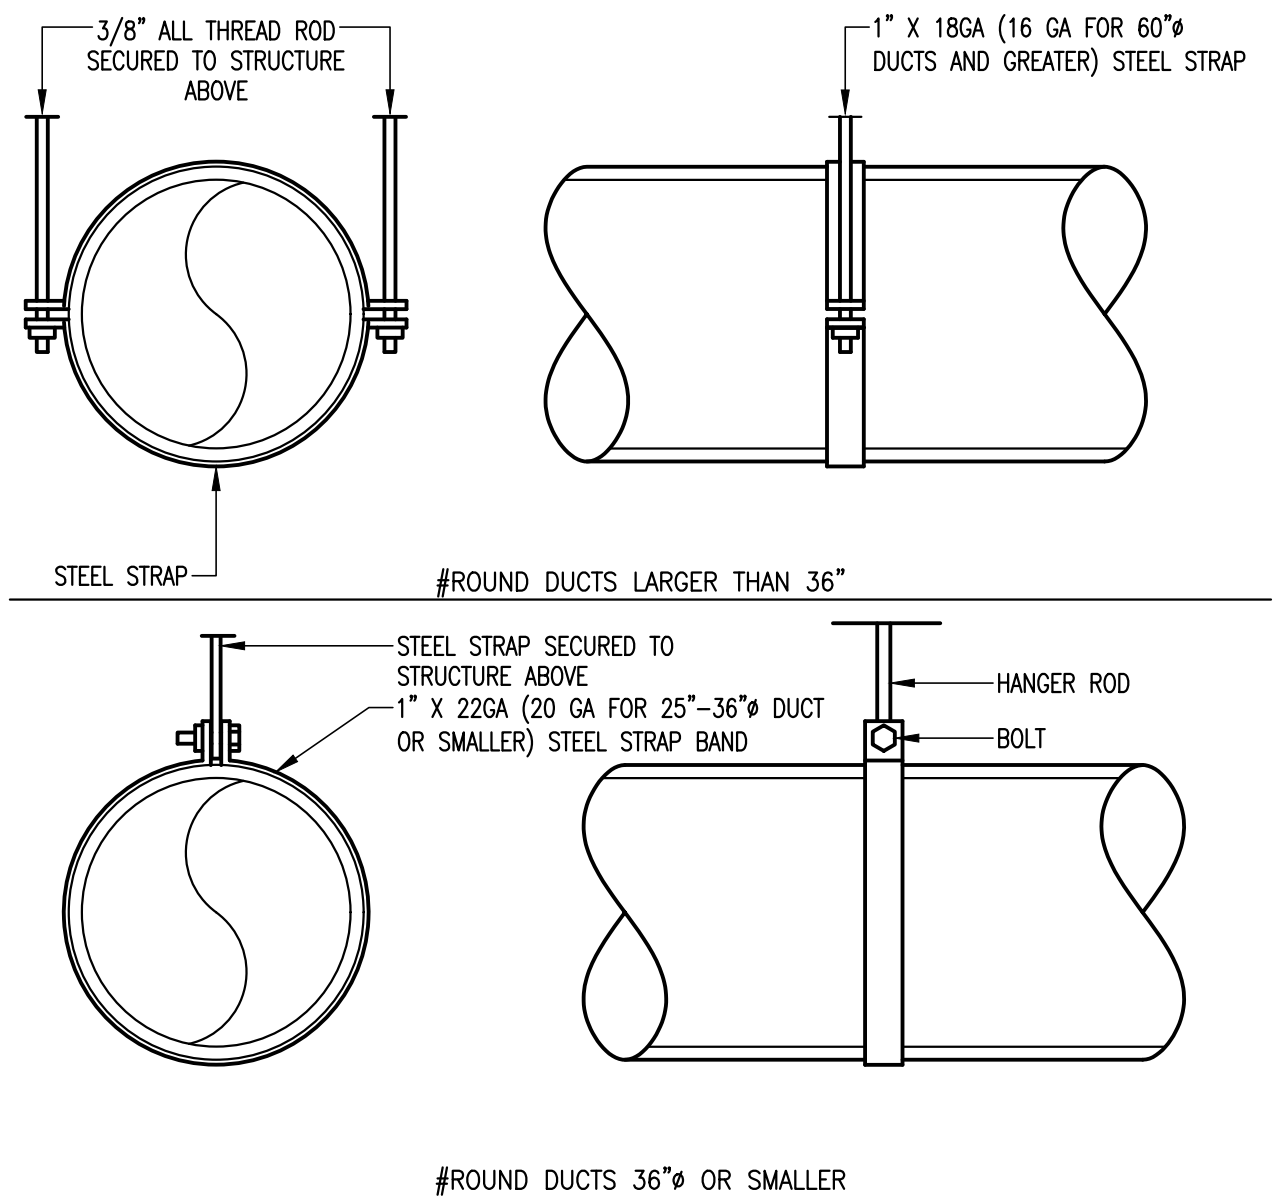

02 EXPOSED AND CONCEALED ROUND DUCT HANGER
SCALE: N.T.S.

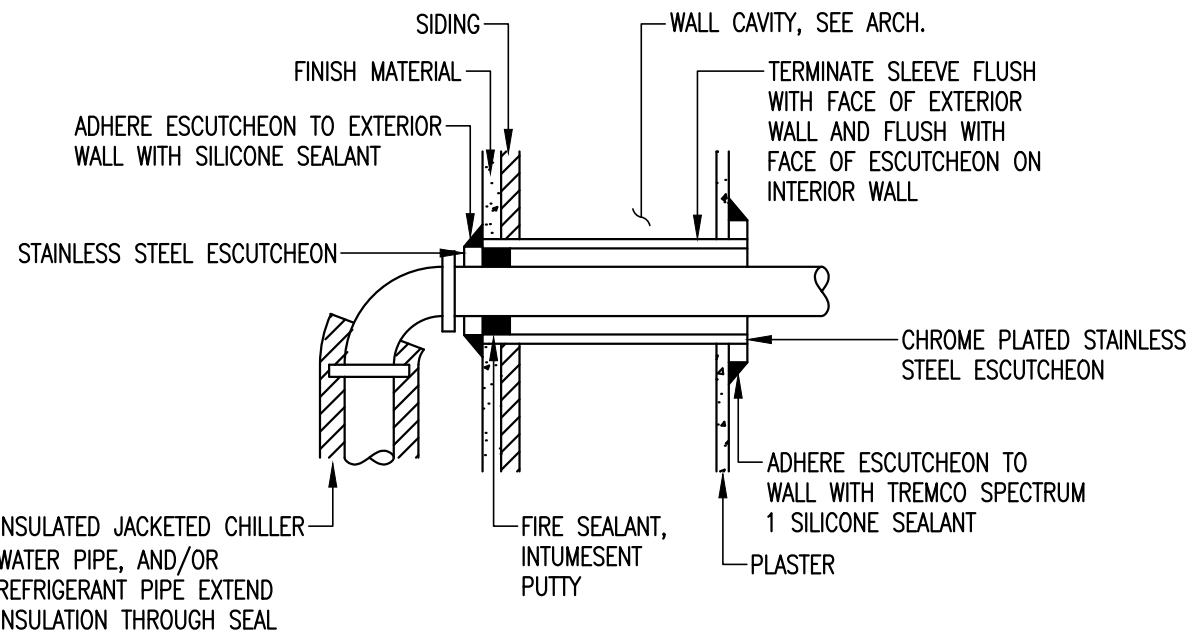


01 TYP. EXTERIOR WALL PENETRATION
SCALE: N.T.S.

Revision No.	Date	Description
1	7-26-2018	Addendum #1




100%
CONSTRUCTION
DOCUMENTS


Project No.:	33348
Issued:	07-11-18
Drawn By:	K.G./J.B
Checked By:	H.A.
Scale:	AS NOTED
Sheet Title	MECHANICAL SCHEDULE
Sheet Number	M2.01

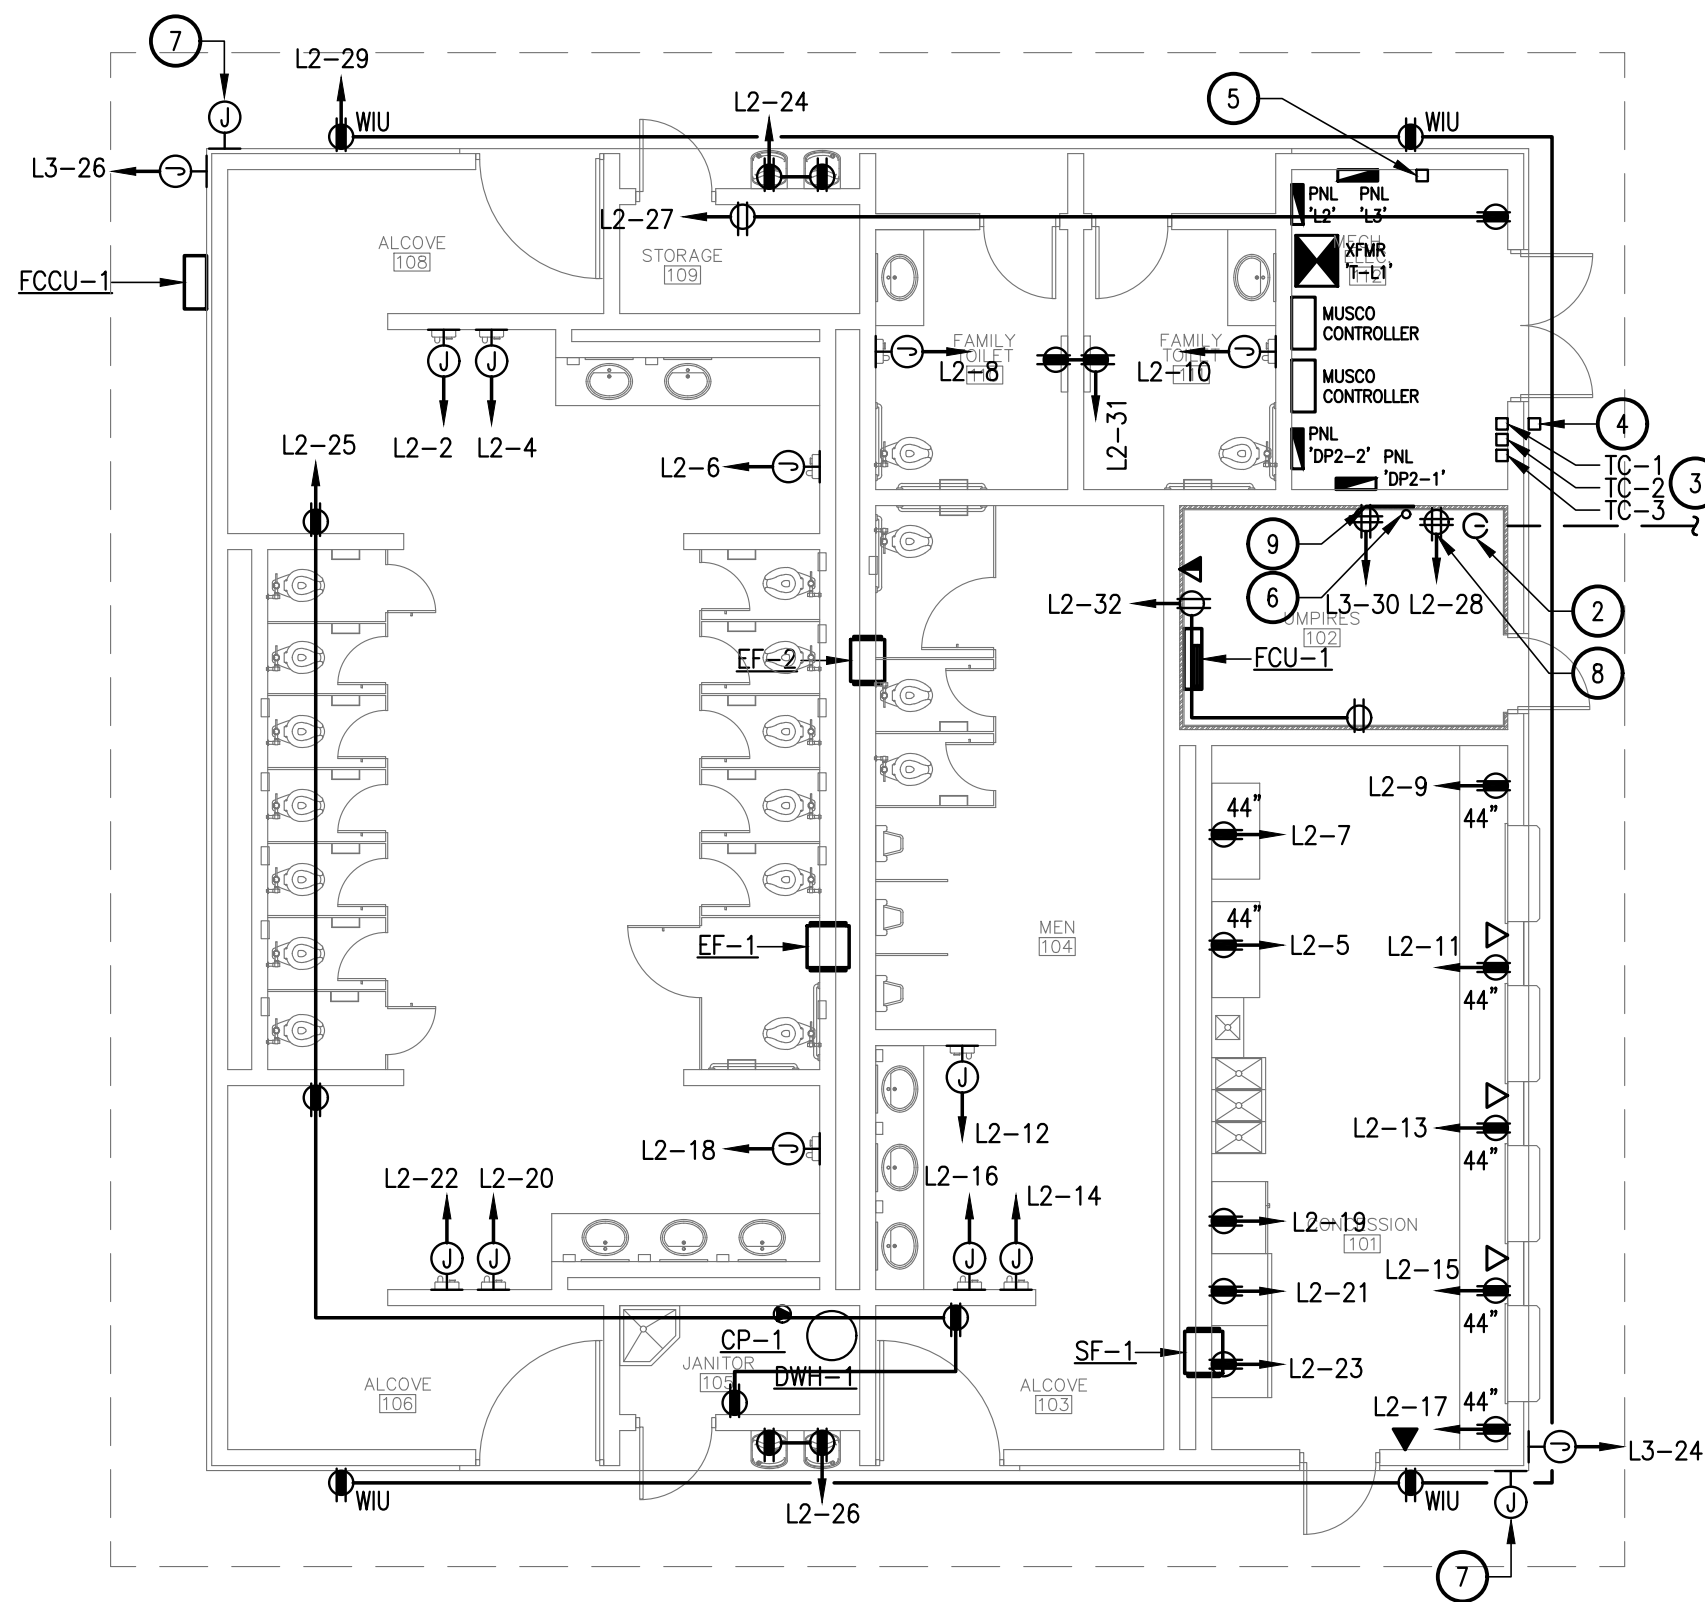


02 ELECTRICAL POWER PLAN - CONCESSION
SCALE: 1/8" = 1'-0"

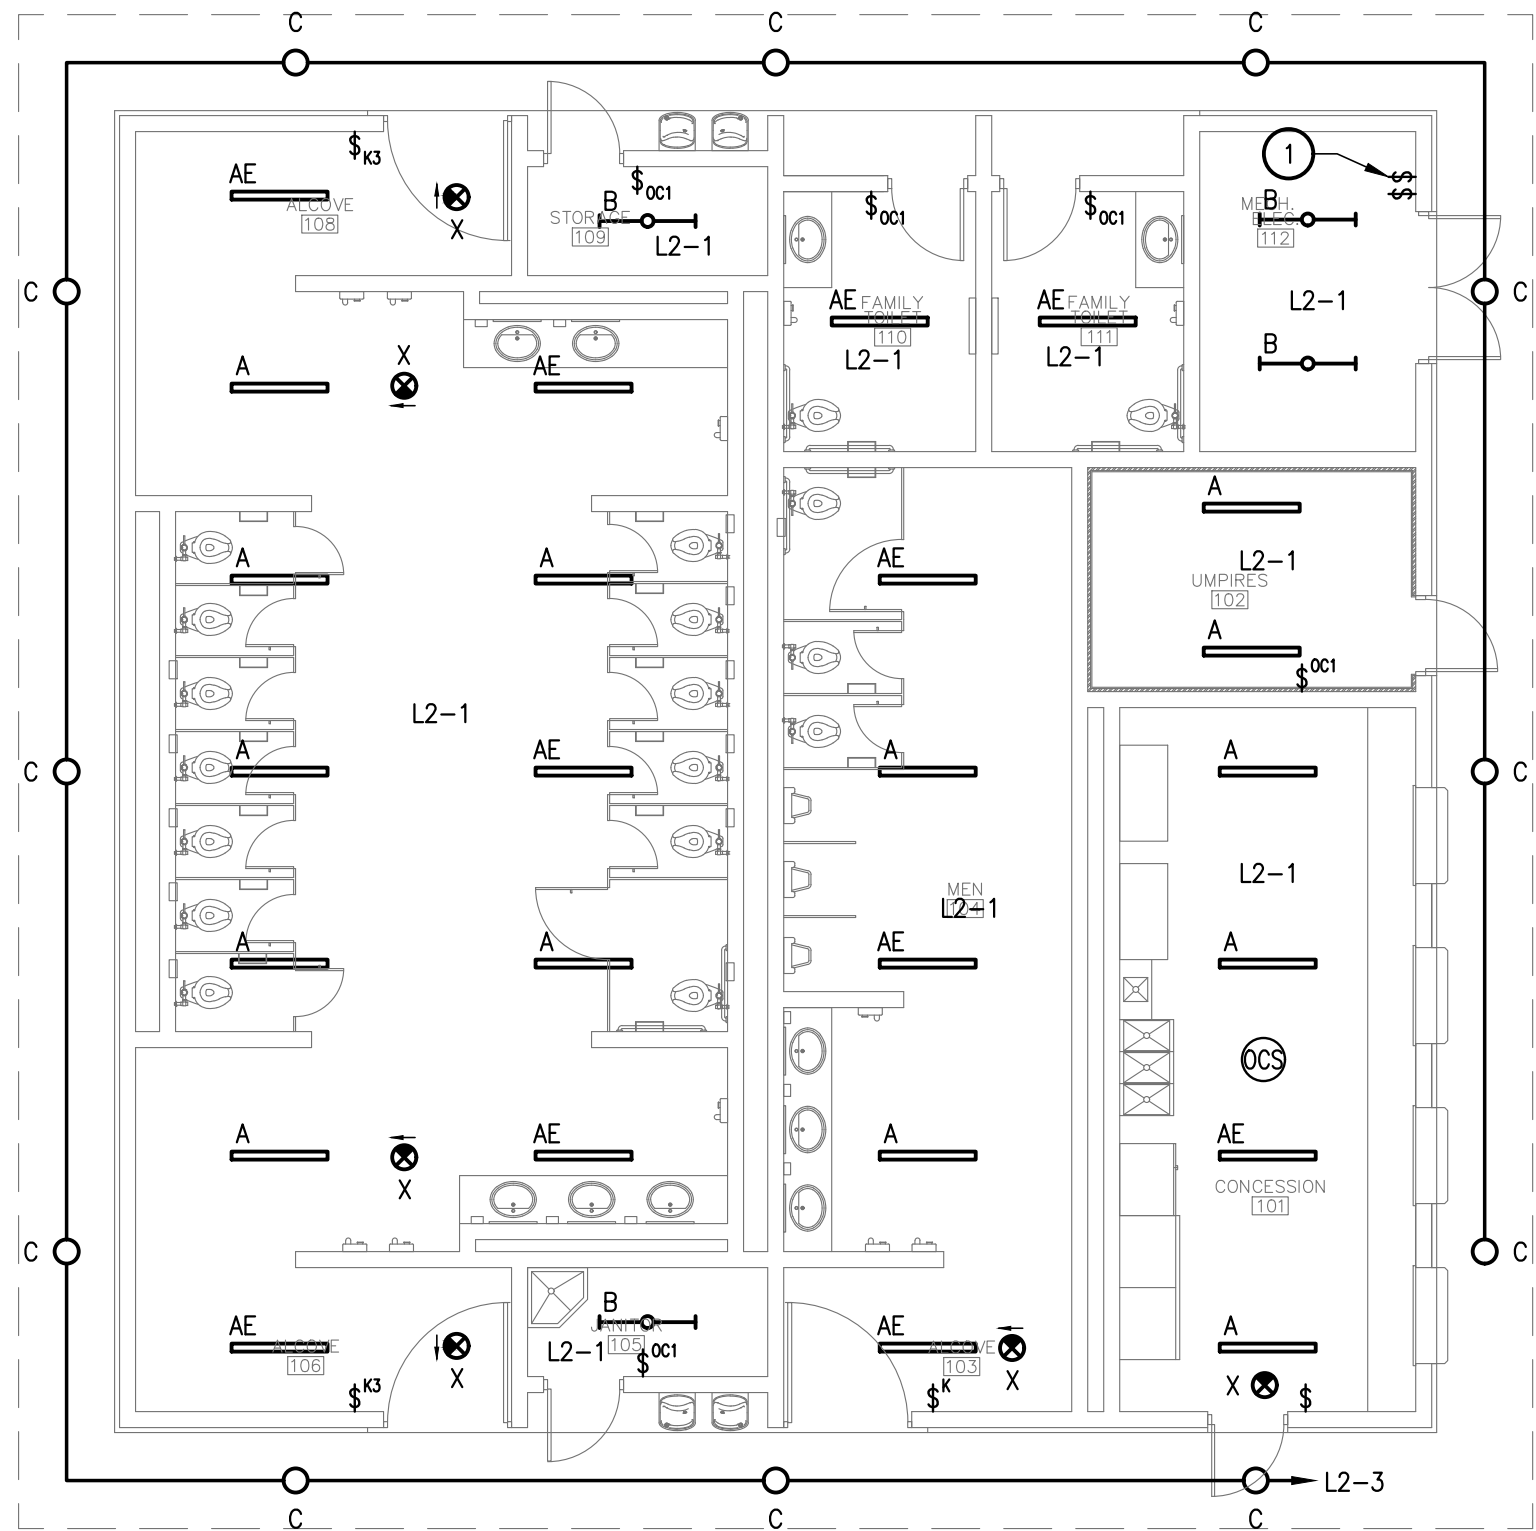

01 ELECTRICAL LIGHTING PLAN - CONCESSION
SCALE: 1/8" = 1'-0"

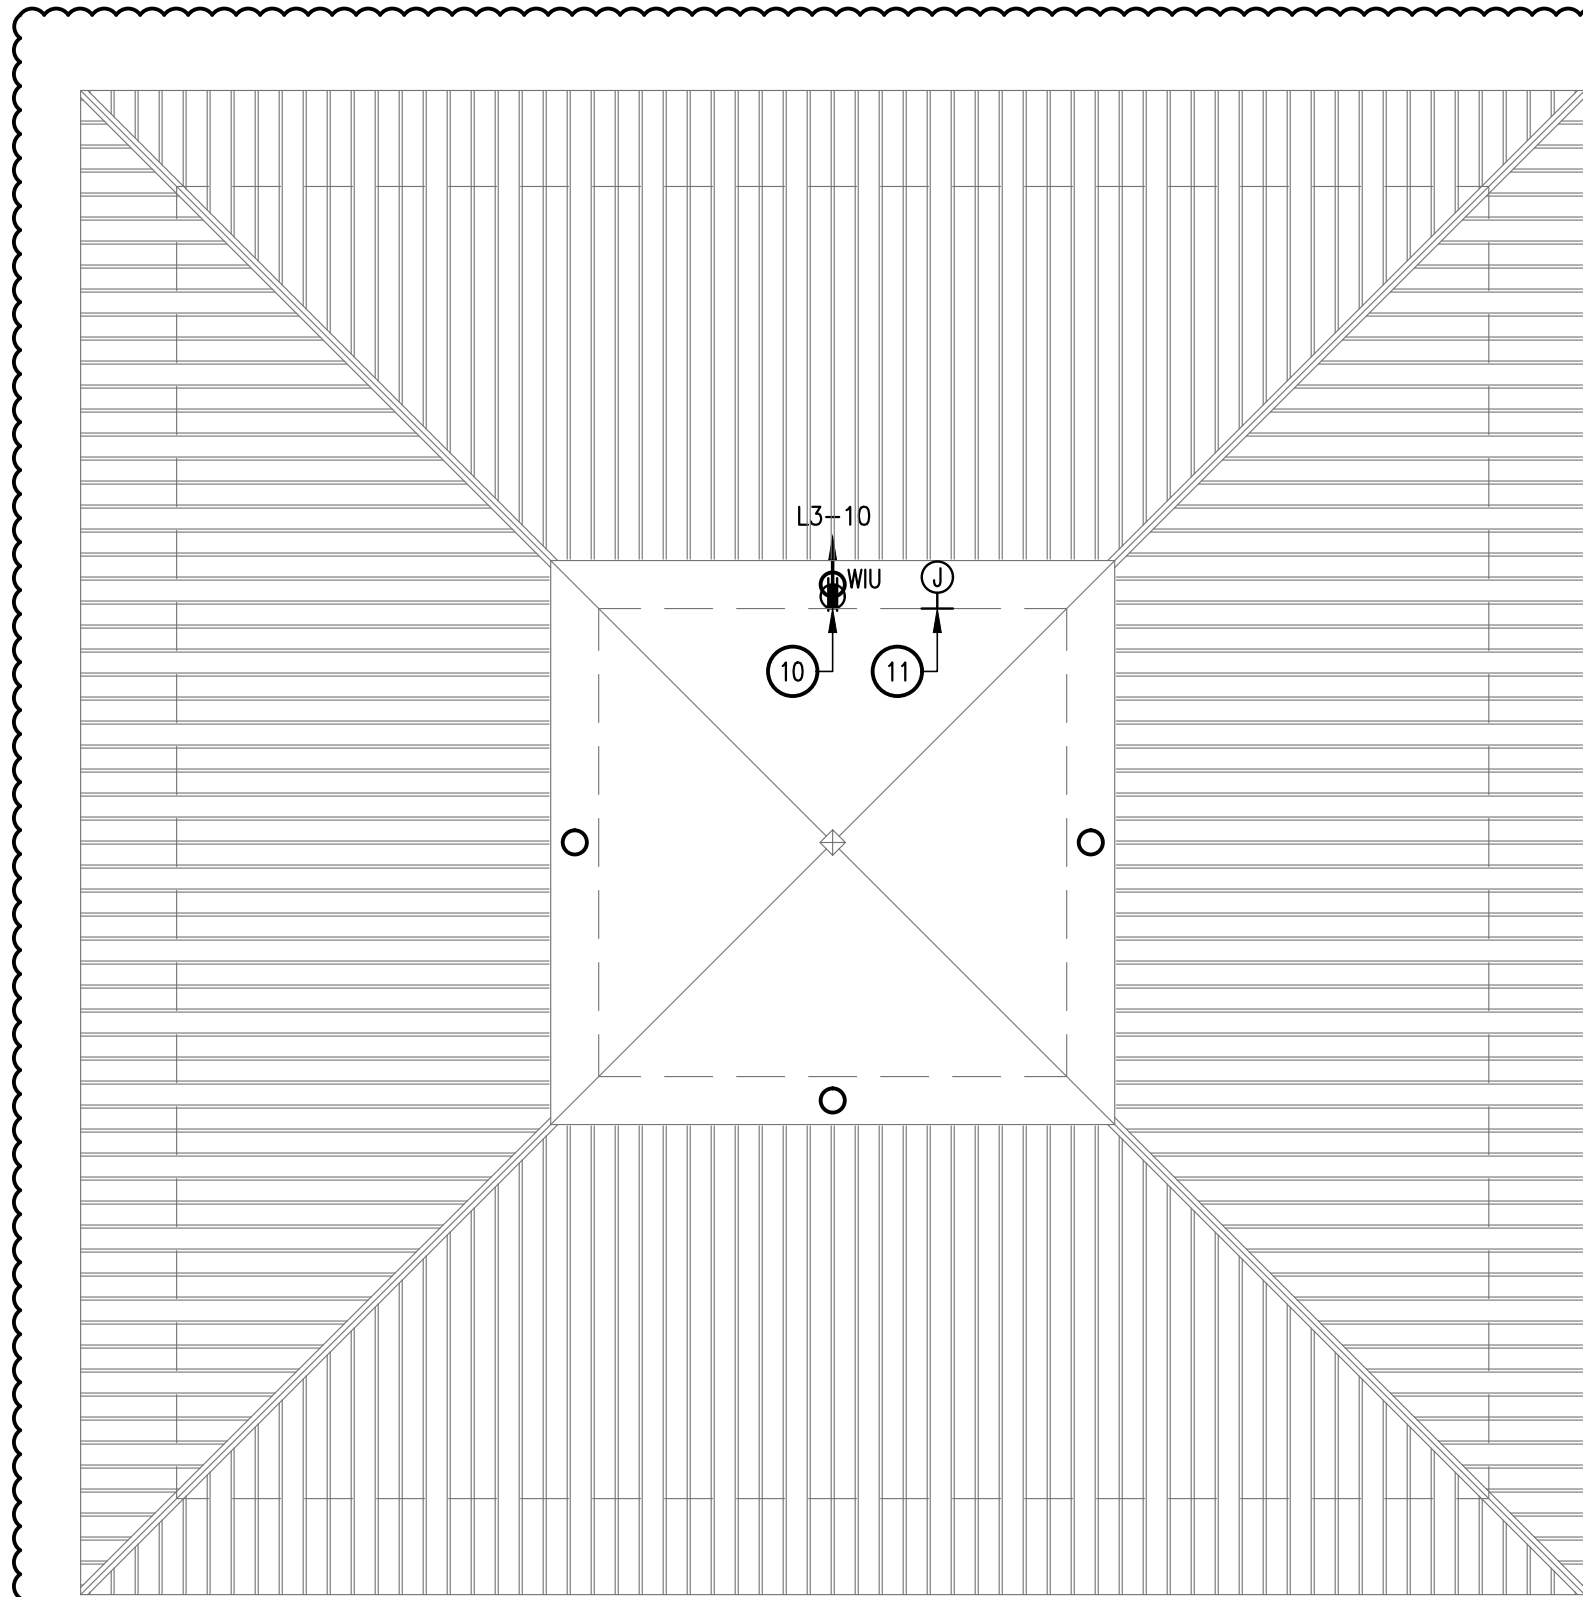

04 ELECTRICAL POWER PLAN - CUPOLA
SCALE: 1/8" = 1'-0"

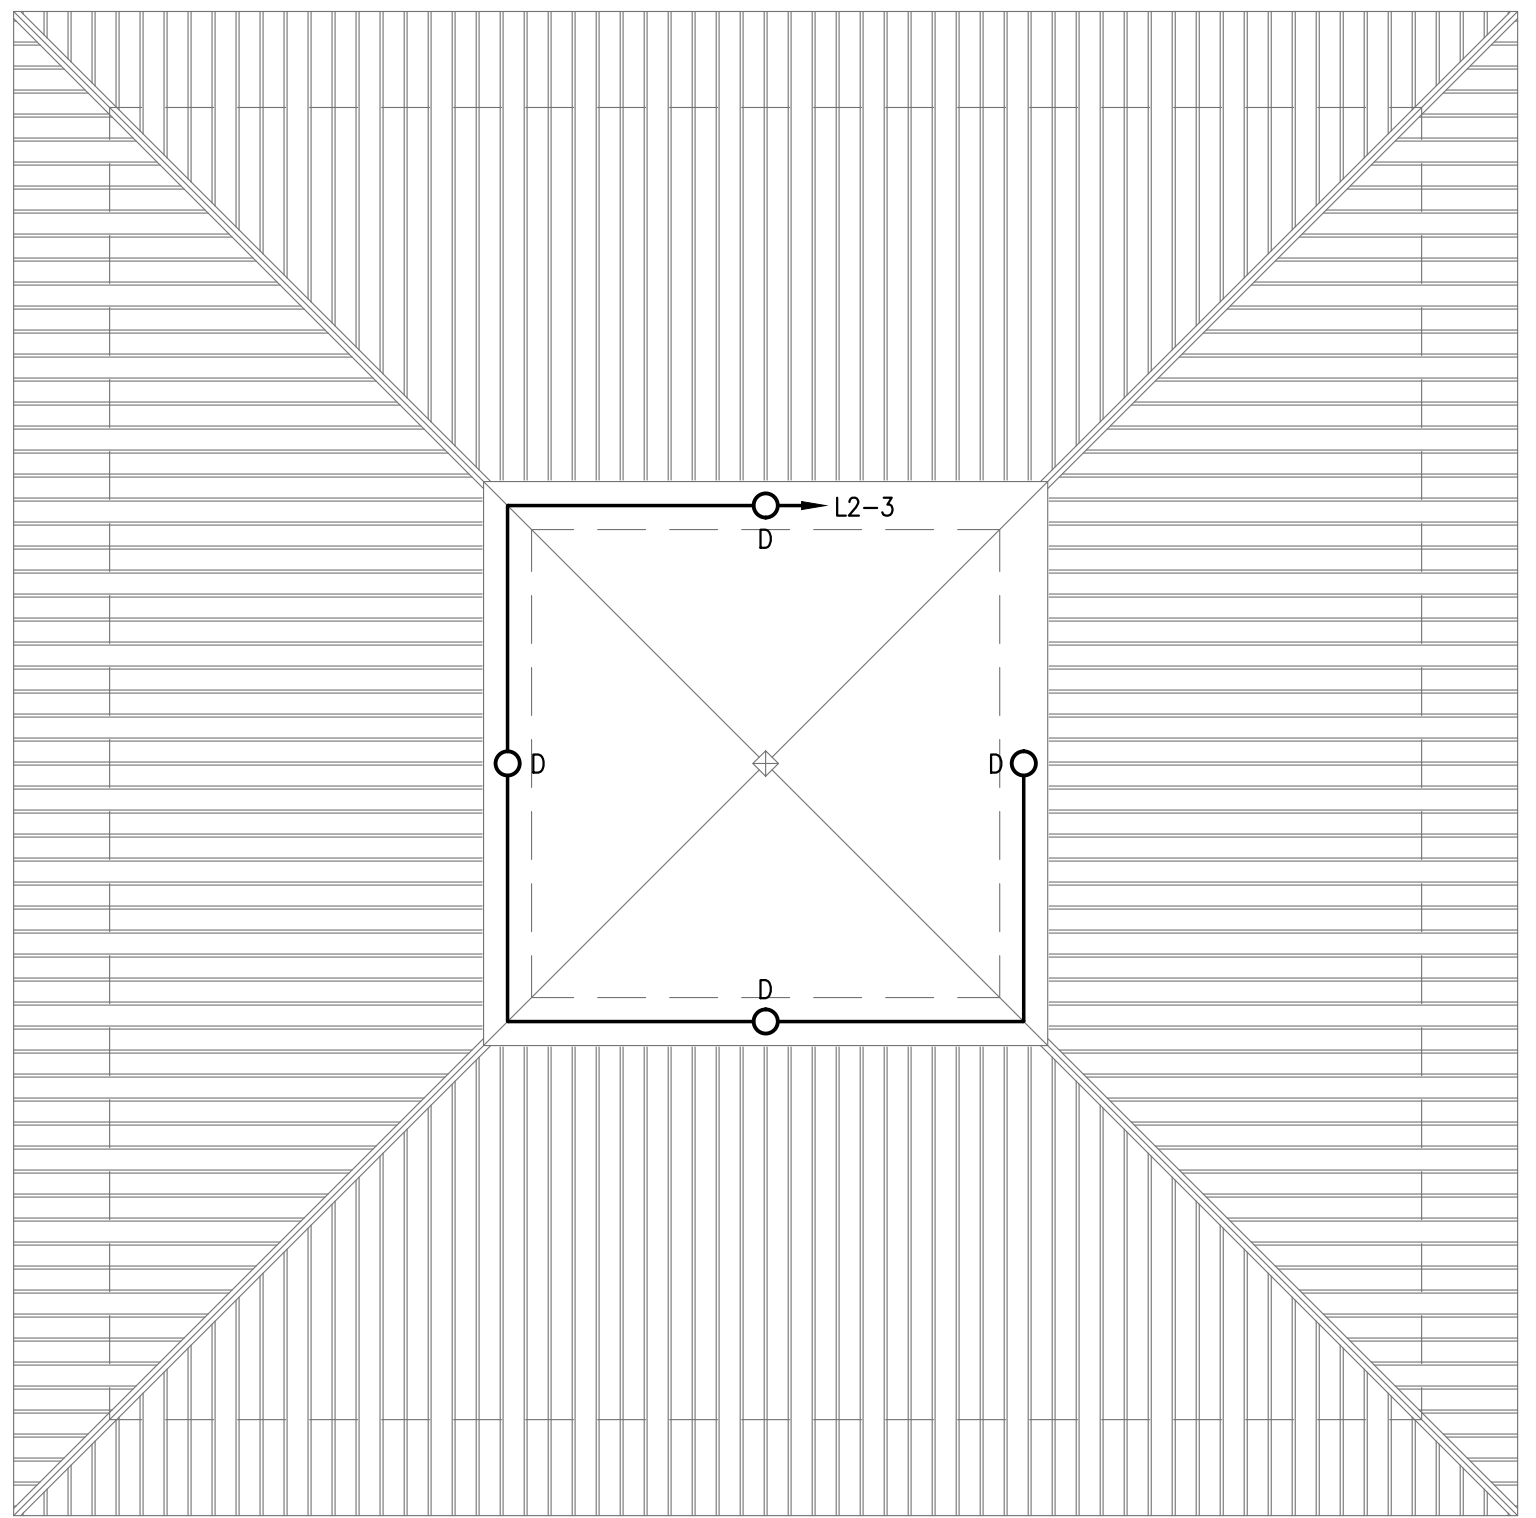

03 ELECTRICAL LIGHTING PLAN - CUPOLA
SCALE: 1/8" = 1'-0"

GENERAL NOTES:

- REFER TO SHEET E001 FOR ELECTRICAL GENERAL NOTES.
- REFER TO MECHANICAL EQUIPMENT CONNECTION SCHEDULE FOR ELECTRICAL CONNECTION TO MECHANICAL EQUIPMENT.

KEY NOTES:


- PROVIDE DEDICATED LIGHT SWITCH FOR CONTROL OF CUPOLA LIGHTING. SWITCH SHALL BE WIRED TO OVERRIDE TIMECLOCK CONTROL OF EXTERIOR LIGHTS.
- PROVIDE (2) 4" PVC CONDUITS AND STUB OUT FROM UMPIRE'S ROOM WITH PULL STRING. REFER TO SITE PLAN FOR LOCATION OF FIBER PEDESTAL.
- TYPICAL OF ALL FANS. PROVIDE DIGITAL, SINGLE CHANNEL, 7 DAY PROGRAMMABLE TIME CLOCK WITH HOLIDAY SCHEDULING. BASIS OF DESIGN: TORK #DG100A.
- PROVIDE WITH KNOX BOX.
- PROVIDE ASTRONOMIC, DUAL CHANNEL, PROGRAMMABLE TIME CLOCK (TC-4) WITH HOLIDAY SCHEDULING AND PHOTOCCELL INPUT. BASIS OF DESIGN: TORK #DGLC200A-NC FOR CONTROL EXTERIOR LIGHTING.
- PROVIDE (2) 4" CONDUITS WITH PULL STRING AND STUB OUT OF BUILDING, BELOW GRADE. CONDUIT SHALL BE ROUTED TO EXISTING TELEPHONE PEDESTAL ON NORTH PROPERTY LINE. REFER TO SITE PLAN FOR ADDITIONAL INFORMATION.
- PROVIDE RECESSED, DOUBLE GANG, WEATHER PROOF JUNCTION BOX AT BUILDING SOFFIT WITH 1/2" C STUBBED INTO ACCESSIBLE ATTIC SPACE. PROVIDE PULL STRING. BOX SHALL SERVE FOR CAMERA INSTALLATION.
- COORDINATE QUAD RECEPTACLE LOCATION WITH CITY OF MCALEN IT DEPARTMENT PRIOR TO ROUGH-IN. RECEPTACLE SHALL BE INSTALLED AT HEIGHT EQUAL TO COMMUNICATIONS RACK.
- PROVIDE 2'x2'x3/4" PLYWOOD BOARD FOR TELEPHONE SERVICE DEMARC.
- RECEPTACLE IN WEATHER-PROOF ENCLOSURE TO BE INSTALLED AT EXTERIOR WALL OF CUPOLA 4" BELOW LOUVER.
- INSTALL 4X4 J-BOX AND 1-1/4" CONDUIT WITH PULL-STRING FOR DATA CABLE ROUTING FOR FUTURE SPEAKER SYSTEM.

CITY OF MCALEN
SOFTBALL FIELD FACILITIES
MUNICIPAL PARK
MCALEN, TEXAS



HALFF
5000 WEST MILITARY, SUITE 100
MCALEN, TEXAS 78503
PHONE (361) 664-0382
FAX (361) 664-0382
TBE FIRM #F-512

Revision No.	Date	Description	Addendum #1
1	7-26-2018		

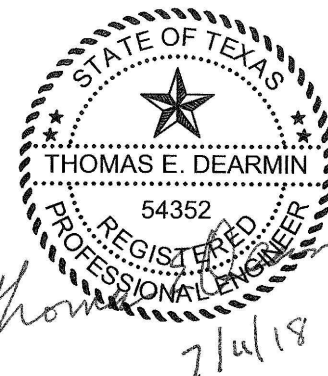

100%
CONSTRUCTION
DOCUMENTS

Project No.:	33348
Issued:	07-11-18
Drawn By:	CHAVEZ/MG
Checked By:	TED
Scale:	AS NOTED
Sheet Title	CONCESSION BUILDING ELECTRICAL PLANS
E1.04	
Sheet Number	

PANELBOARD 'L3'												
VOLTAGE: 208Y/120 VOLT 3 PHASE 4 WIRE						LOCATION: ELECTRICAL ROOM						
LUGS ONLY						MOUNTING: SURFACE						
BUSES: MAIN - 100 A; NEUTRAL - 100%; EQUIPMENT GROUND						Isc = 10,000 A RMS SYM AVAILABLE						
VA-L	VA-R	VA-O	LOAD	BKR	CKT	PH	CKT	BKR	LOAD	VA-L	VA-R	VA-O
0	180		RECEPTACLE (POLE B10)	20/1	1	A	2	20/1	PWR: SCOREBOARD 4	0	0	500
0	180		RECEPTACLE (POLE B9)	20/1	3	B	4	20/1	PWR: SCOREBOARD 5	0	0	500
0	180		RECEPTACLE (POLE B14)	20/1	5	C	6	20/1	PWR: SCOREBOARD 6	0	0	500
0	180		RECEPTACLE (POLE B13)	20/1	7	A	8	20/1	REC: BATTING CAGES - NORTH	0	0	900
0	180		RECEPTACLE (POLE B12)	20/1	9	B	10	20/1	REC: CUPOLA	0	0	180
0	180		RECEPTACLE (POLE B11)	20/1	11	C	12	20/1	SPARE	0	0	0
0	180		RECEPTACLE (POLE A6)	20/1	13	A	14	20/1	SPARE	0	0	0
0	180		RECEPTACLE (POLE A5)	20/1	15	B	16	20/1	CAMERA FEED ON POLE B11	0	0	180
0	180		RECEPTACLE (POLE A8)	20/1	17	C	18	20/1	CAMERA FEED ON POLE B12	0	0	180
0	180		RECEPTACLE (POLE A7)	20/1	19	A	20	20/1	CAMERA FEED ON POLE A7	0	0	180
0	0		SPARE	20/1	21	B	22	20/1	CAMERA FEED ON POLE B9	0	0	180
0	0		SPARE	20/1	23	C	24	20/1	CAMERA FEED ON RR BLDG NORTH	0	0	180
0	180		RECEPTACLE (POLE P1)	20/1	25	A	26	20/1	CAMERA FEED ON RR BLDG SOUTH	0	0	180
0	180		PWR: ECB-2	20/1	27	B	28	20/1	CAMERA FEED ON POLE B14	0	0	180
0	180		RECEPTACLE (BACKSTOP FIELD 4)	20/1	29	C	30	20/1	RECEP: TELEPHONE BOARD	0	0	360
0	180		RECEPTACLE (BACKSTOP FIELD 5)	20/1	31	A	32	20/1	LTG: FLAG POLES	1500	0	0
0	180		RECEPTACLE (BACKSTOP FIELD 6)	20/1	33	B	34	20/1	SPARE	0	0	0
0	0		SPARE	20/1	35	C	36	20/1	SPARE	0	0	0
0	0		SPARE	20/1	37	A	38	20/1	SPARE	0	0	0
0	0		SPARE	20/1	39	B	40	20/1	SPARE	0	0	0
0	0		SPARE	20/1	41	C	42	20/1	SPARE	0	0	0
VA-L (LIGHTING)				1500	CONNECTED					1875	DEMAND	
VA-R (RECEPTALES)				5400	CONNECTED					5400	DEMAND	
VA-O (OTHER)				1500	CONNECTED					1500	DEMAND	
VA: TOTAL				8400	CONNECTED					8775	DEMAND	
AMPS: TOTAL				23	CONNECTED					24	DEMAND	
L	R	O	TOTAL									
1500	2340	500	VA CONNECTED TO A PHASE	4340	VA =	36	AMPS CONNECTED TO A PHASE @ 120 VOLTS					
0	1620	500	VA CONNECTED TO B PHASE	2120	VA =	18	AMPS CONNECTED TO B PHASE @ 120 VOLTS					
0	1440	500	VA CONNECTED TO C PHASE									

NEW PANEL BOARD 'L1'																			
VOLTAGE: 208Y/120 VOLT 3 PHASE 4 WIRE							LOCATION: EQUIPMENT RACK												
LUGS ONLY							MOUNTING: SURFACE												
BUSES: MAIN – 225 A; NEUTRAL – 100%; EQUIPMENT GROUND							Isc = 10,000 A RMS SYM AVAILABLE												
VA:L	VA:R	VA:O	LOAD	BKR	CKT	PH	CKT	BKR	LOAD	VA:L	VA:R	VA:O							
0	0	500	PWR: SCOREBOARD FIELD 1	20/1	1	A	2	20/1	RECEPTACLE (POLE B1)	0	180								
0	0	500	PWR: SCOREBOARD FIELD 2	20/1	3	B	4	20/1	RECEPTACLE (POLE B2)	0	180								
0	0	500	PWR: SCOREBOARD FIELD 3	20/1	5	C	6	20/1	RECEPTACLE (POLE B3)	0	180								
0	180		CAMERA FEED ON POLE B1	20/1	7	A	8	20/1	RECEPTACLE (POLE B4)	0	180								
0	180		CAMERA FEED ON POLE A1	20/1	9	B	10	20/1	RECEPTACLE (POLE B5)	0	180								
0	180		CAMERA FEED ON POLE A3	20/1	11	C	12	20/1	RECEPTACLE (POLE B6)	0	180								
0	180		CAMERA FEED ON POLE B5	20/1	13	A	14	20/1	RECEPTACLE (POLE B7)	0	180								
0	180		CAMERA FEED ON POLE B3	20/1	15	B	16	20/1	RECEPTACLE (POLE B8)	0	180								
0	180		PWR: ECB–1	20/1	17	C	18	20/1	RECEPTACLE (POLE A1)	0	180								
0	0		SPARE	20/1	19	A	20	20/1	RECEPTACLE (POLE A2)	0	180								
0	0		SPARE	20/1	21	B	22	20/1	RECEPTACLE (POLE A3)	0	180								
0	0		SPARE	20/1	23	C	24	20/1	RECEPTACLE (POLE A4)	0	180								
0	0		SPARE	20/1	25	A	26	20/1	SPARE	0	0								
0	0		SPARE	20/1	27	B	28	20/1	SPARE	0	0								
0	0		SPARE	20/1	29	C	30	20/1	SPARE	0	0								
0	0		SPACE	–	31	A	32	–	SPACE	0	0								
0	0		SPACE	–	33	B	34	–	SPACE	0	0								
0	0		SPACE	–	35	C	36	–	SPACE	0	0								
0	0		SPACE	–	37	A	38	–	SPACE	0	0								
0	0		SPACE	–	39	B	40	–	SPACE	0	0								
0	0		SPACE	–	41	C	42	–	SPACE	0	0								
VA:L (LIGHTING)				0	CONNECTED					0	DEMAND								
VA:R (RECEPTALES)				3240	CONNECTED					3240	DEMAND								
VA:O (OTHER)				1500	CONNECTED					1500	DEMAND								
VA: TOTAL				4740	CONNECTED					4740	DEMAND								
AMPS: TOTAL				13	CONNECTED					13	DEMAND								
L	R	O	TOTAL																
0	1080	500	VA CONNECTED TO A PHASE	1580	VA =				13	AMPS CONNECTED TO A PHASE @ 120 VOLTS									
0	1080	500	VA CONNECTED TO B PHASE	1580	VA =				13	AMPS CONNECTED TO B PHASE @ 120 VOLTS									
0	1080	500	VA CONNECTED TO C PHASE	1580	VA =				13	AMPS CONNECTED TO C PHASE @ 120 VOLTS									
0	3240	1500	TOTAL	4740	VA														

PANEL BOARD 'L4'																		
VOLTAGE: PRIMARY INPUT 480V TO 240/120 VOLT 1 PHASE SECONDARY						LOCATION: GREEN AREA												
FACTORY INTALLED PRIMARY AND SECONDARY MAIN BREAKERS						MOUNTING: EQUIPMENT RACK												
BUSES: MAIN – 125 A; NEUTRAL – 100%; EQUIPMENT GROUND						Isc = 18,000 A RMS SYM AVAILABLE												
VA/L	VA/R	VA-O	LOAD	BKR	CKT	PH	CKT	BKR	LOAD	VA/L	VA/R	VA-O						
0	0	1980	REC: FOOD TRUCKS	30/1	1	A	2	30/1	REC: FOOD TRUCKS	0	0	1980						
0	0	1980	REC: FOOD TRUCKS	30/1	3	B	4	30/1	REC: FOOD TRUCKS	0	0	1980						
0	0	1980	REC: FOOD TRUCKS	30/1	5	A	6	30/1	REC: FOOD TRUCKS	0	0	1980						
0	0	1980	REC: FOOD TRUCKS	30/1	7	B	8	30/1	REC: FOOD TRUCKS	0	0	1980						
0	0	1980	REC: MOBILE STAGE	30/1	9	A	10	20/1	SPARE	0	0							
0	0		SPARE	20/1	11	B	12	20/1	SPARE	0	0							
0	0		SPARE	20/1	13	A	14	20/1	SPARE	0	0							
0	0		SPARE	20/1	15	B	16	20/1	SPARE	0	0							
0	0		SPACE	–	17	A	18	–	SPACE	0	0							
0	0		SPACE	–	19	B	20	–	SPACE	0	0							
0	0		SPACE	–	21	A	22	–	SPACE	0	0							
0	0		SPACE	–	23	B	24	–	SPACE	0	0							
0	0		SPACE	–	25	A	26	–	SPACE	0	0							
0	0		SPACE	–	27	B	28	–	SPACE	0	0							
0	0		SPACE	–	29	A	30	–	SPACE	0	0							
0	0		SPACE	–	31	B	32	–	SPACE	0	0							
0	0		SPACE	–	33	A	34	–	SPACE	0	0							
0	0		SPACE	–	35	B	36	–	SPACE	0	0							
0	0		SPACE	–	37	A	38	–	SPACE	0	0							
0	0		SPACE	–	39	B	40	–	SPACE	0	0							
VA/L (LIGHTING)				0	CONNECTED					0	DEMAND							
VA/R (RECEPTACLES)				0	CONNECTED					0	DEMAND							
VA-O (OTHER)				17820	CONNECTED					17820	DEMAND							
VA: TOTAL				17820	CONNECTED					17820	DEMAND							
AMPS: TOTAL				74	CONNECTED					74	DEMAND							
L	R	O	TOTAL															
0	0	9900	VA CONNECTED TO A PHASE		9900	VA =		83	AMPS CONNECTED TO A PHASE @ 120 VOLTS									
0	0	7920	VA CONNECTED TO B PHASE		7920	VA =		66	AMPS CONNECTED TO B PHASE @ 120 VOLTS									
0	0	17820	TOTAL		17820	VA												


PANELBOARD 'L2'												
VOLTAGE: 208Y/120 VOLT 3 PHASE 4 WIRE						LOCATION: ELECTRICAL ROOM						
LUGS ONLY						MOUNTING: SURFACE						
BUSES: MAIN – 225 A; NEUTRAL – 100%; EQUIPMENT GROUND						Isc = 10,000 A RMS SYM AVAILABLE						
VA:L	VA:R	VA:O	LOAD	BKR	CKT	PH	CKT	BKR	LOAD	VA:L	VA:R	VA:O
1261	0		LTG: GENERAL	20/1	1	A	2	20/1	PWR: HAND DRYER	0	0	1800
360	0		LTG: BUILDING EXTERIOR	20/1	3	B	4	20/1	PWR: HAND DRYER	0	0	1800
0	1440		REC: CONCESSION	20/1	5	C	6	20/1	PWR: HAND DRYER	0	0	1800
0	1440		REC: CONCESSION	20/1	7	A	8	20/1	PWR: HAND DRYER	0	0	1800
0	1440		REC: CONCESSION	20/1	9	B	10	20/1	PWR: HAND DRYER	0	0	1800
0	1440		REC: CONCESSION	20/1	11	C	12	20/1	PWR: HAND DRYER	0	0	1800
0	1440		REC: CONCESSION	20/1	13	A	14	20/1	PWR: HAND DRYER	0	0	1800
0	1440		REC: CONCESSION	20/1	15	B	16	20/1	PWR: HAND DRYER	0	0	1800
0	1440		REC: CONCESSION	20/1	17	C	18	20/1	PWR: HAND DRYER	0	0	1800
0	900		REC: CONCESSION REFRIGERATOR	20/1	19	A	20	20/1	PWR: HAND DRYER	0	0	1800
0	900		REC: CONCESSION REFRIGERATOR	20/1	21	B	22	20/1	PWR: HAND DRYER	0	0	1800
0	900		REC: CONCESSION REFRIGERATOR	20/1	23	C	24	20/1	REC: WATER COOLER	0	0	500
0	720		REC: GENERAL	20/1	25	A	26	20/1	REC: WATER COOLER	0	0	500
0	540		REC: GENERAL	20/1	27	B	28	20/1	REC: IT RACK	0	720	
0	720		REC: EXTERIOR	20/1	29	C	30	20/1	PWR: CP-1	0	0	219
0	360		REC: FAMILY RESTROOM	20/1	31	A	32	20/1	REC: UMPIRE ROOM	0	360	
0	0	3000	PWR: DWH-1	40/2	33	B	34	15/2	PWR: FCCU-1 (FCU-1)	0	0	1269
0	0	3000	"	–	35	C	36	–	"	0	0	1269
0	0	1656	PWR: EF-1	20/1	37	A	38	50/3	PANEL 'L3'	1500	2340	500
0	0	696	PWR: EF-2	20/1	39	B	40	–	"	0	1440	500
0	0	1176	PWR: SF-1	20/1	41	C	42	–	"	0	1440	500
VA:L (LIGHTING)				3121	CONNECTED					3901	DEMAND	
VA:R (RECEPTACLES)				21420	CONNECTED					15710	DEMAND	
VA:O (OTHER)				34585	CONNECTED					34585	DEMAND	
VA: TOTAL				59126	CONNECTED					54196	DEMAND	
AMPS: TOTAL				164	CONNECTED					150	DEMAND	
L	R	O				TOTAL						
2761	7560	9856	VA CONNECTED TO A PHASE			20177	VA =	168	AMPS CONNECTED TO A PHASE @ 120 VOLTS			
360	6480	12665	VA CONNECTED TO B PHASE			19505	VA =	163	AMPS CONNECTED TO B PHASE @ 120 VOLTS			
0	7380</											

CITY OF MCALLEN
SOFTBALL FIELD FACILITIES
MUNICIPAL PARK
MCALLEN, TEXAS





Project No.:	33348
Issued:	07-11-18
Drawn By:	CHAVEZ/MG
Checked By:	TED
Scale:	AS NOTED
Sheet Title	
ELECTRICAL SCHEDULES	
E3.04	
Sheet Number	

File Name: I:\33000s\33348\00\WER\CADD\PI.01-PL-33348.dwg
Current Tab (Layout): PI.01 User: AH1497
Printed Date: 7/25/2018 2:29:50 PM

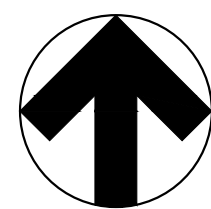


01 PLUMBING PARTIAL SITE PLAN

SCALE: 1"=40'

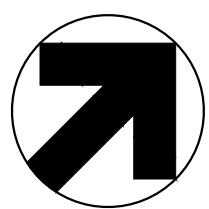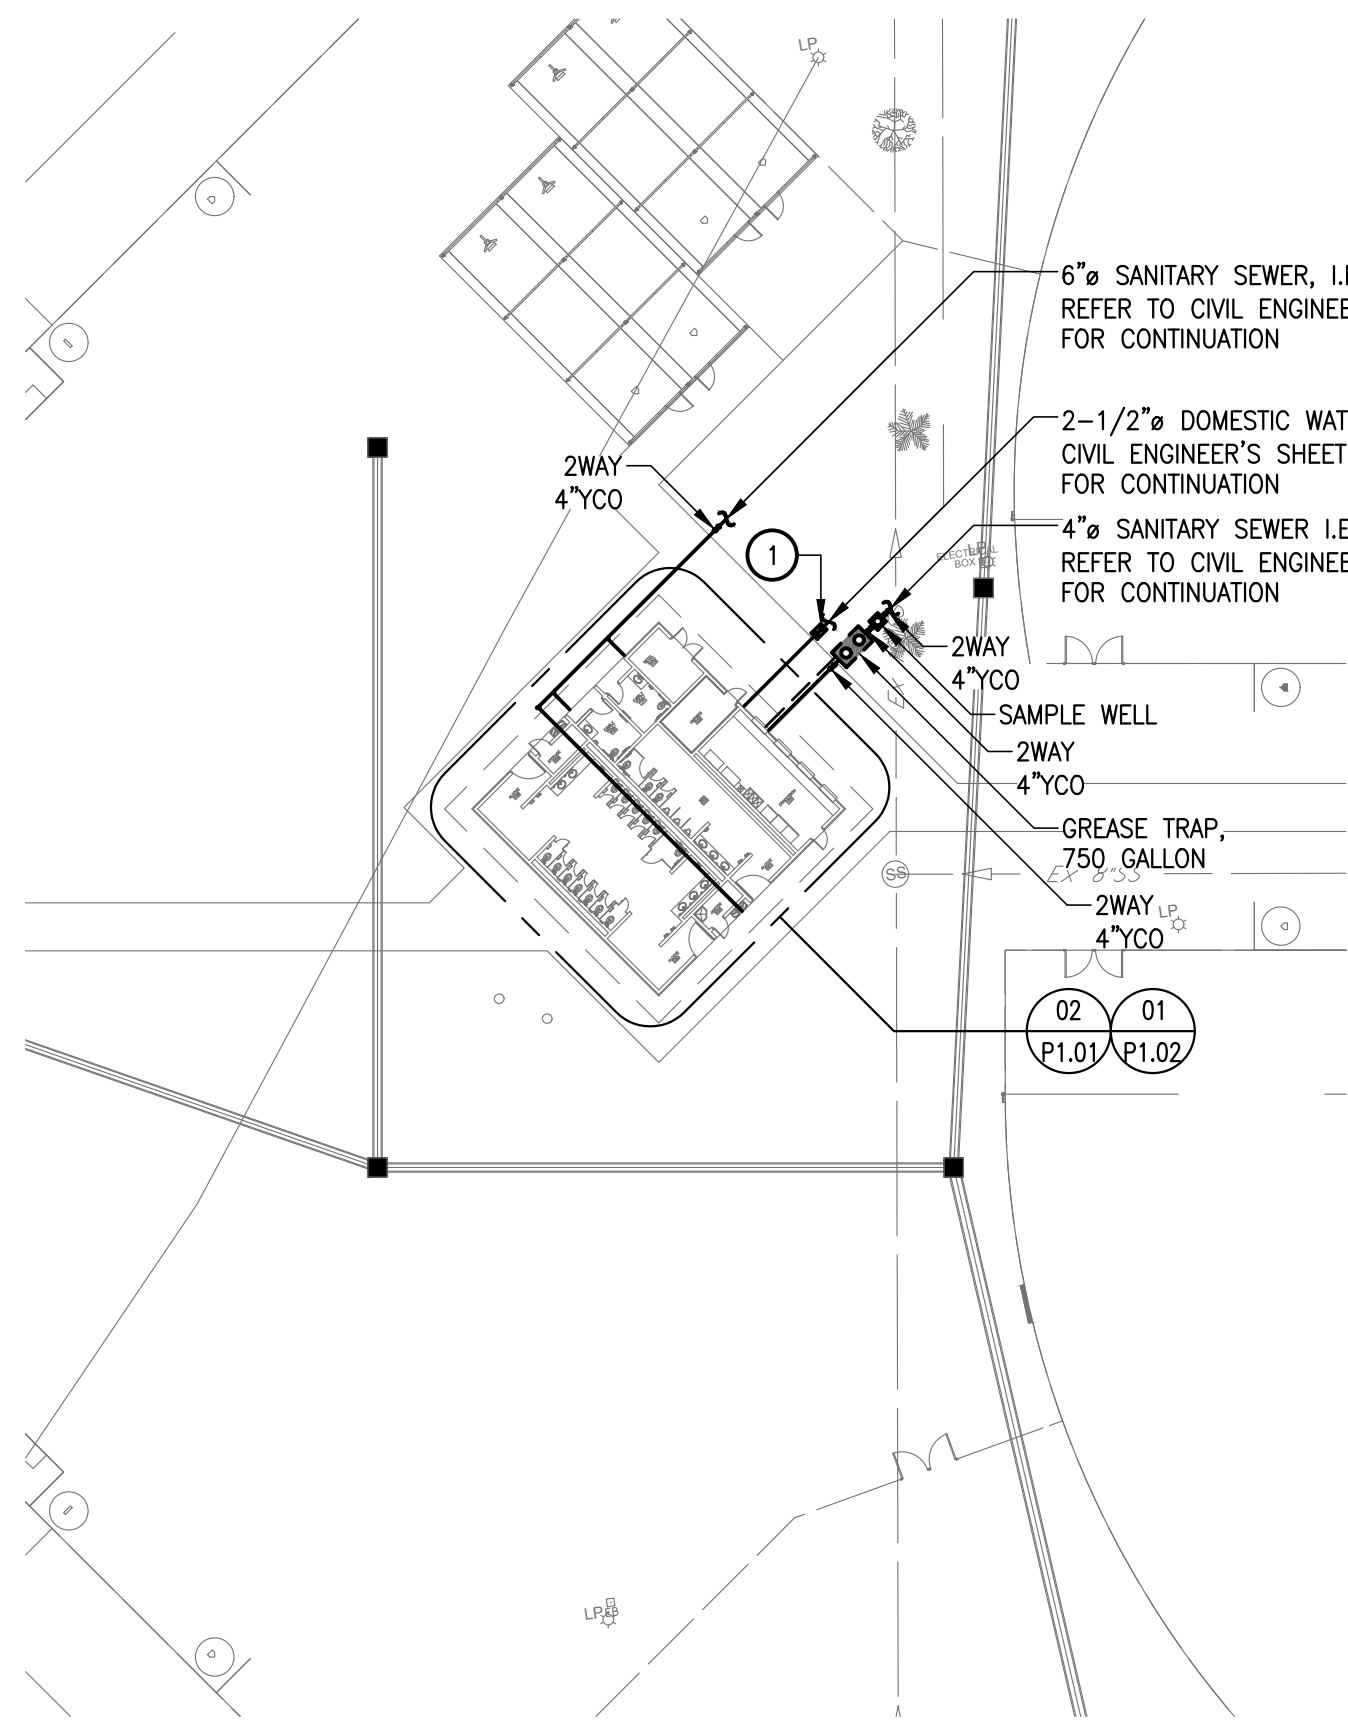

02 PLUMBING SANITARY SEWER PLAN

SCALE: 1/4" = 1'-0"

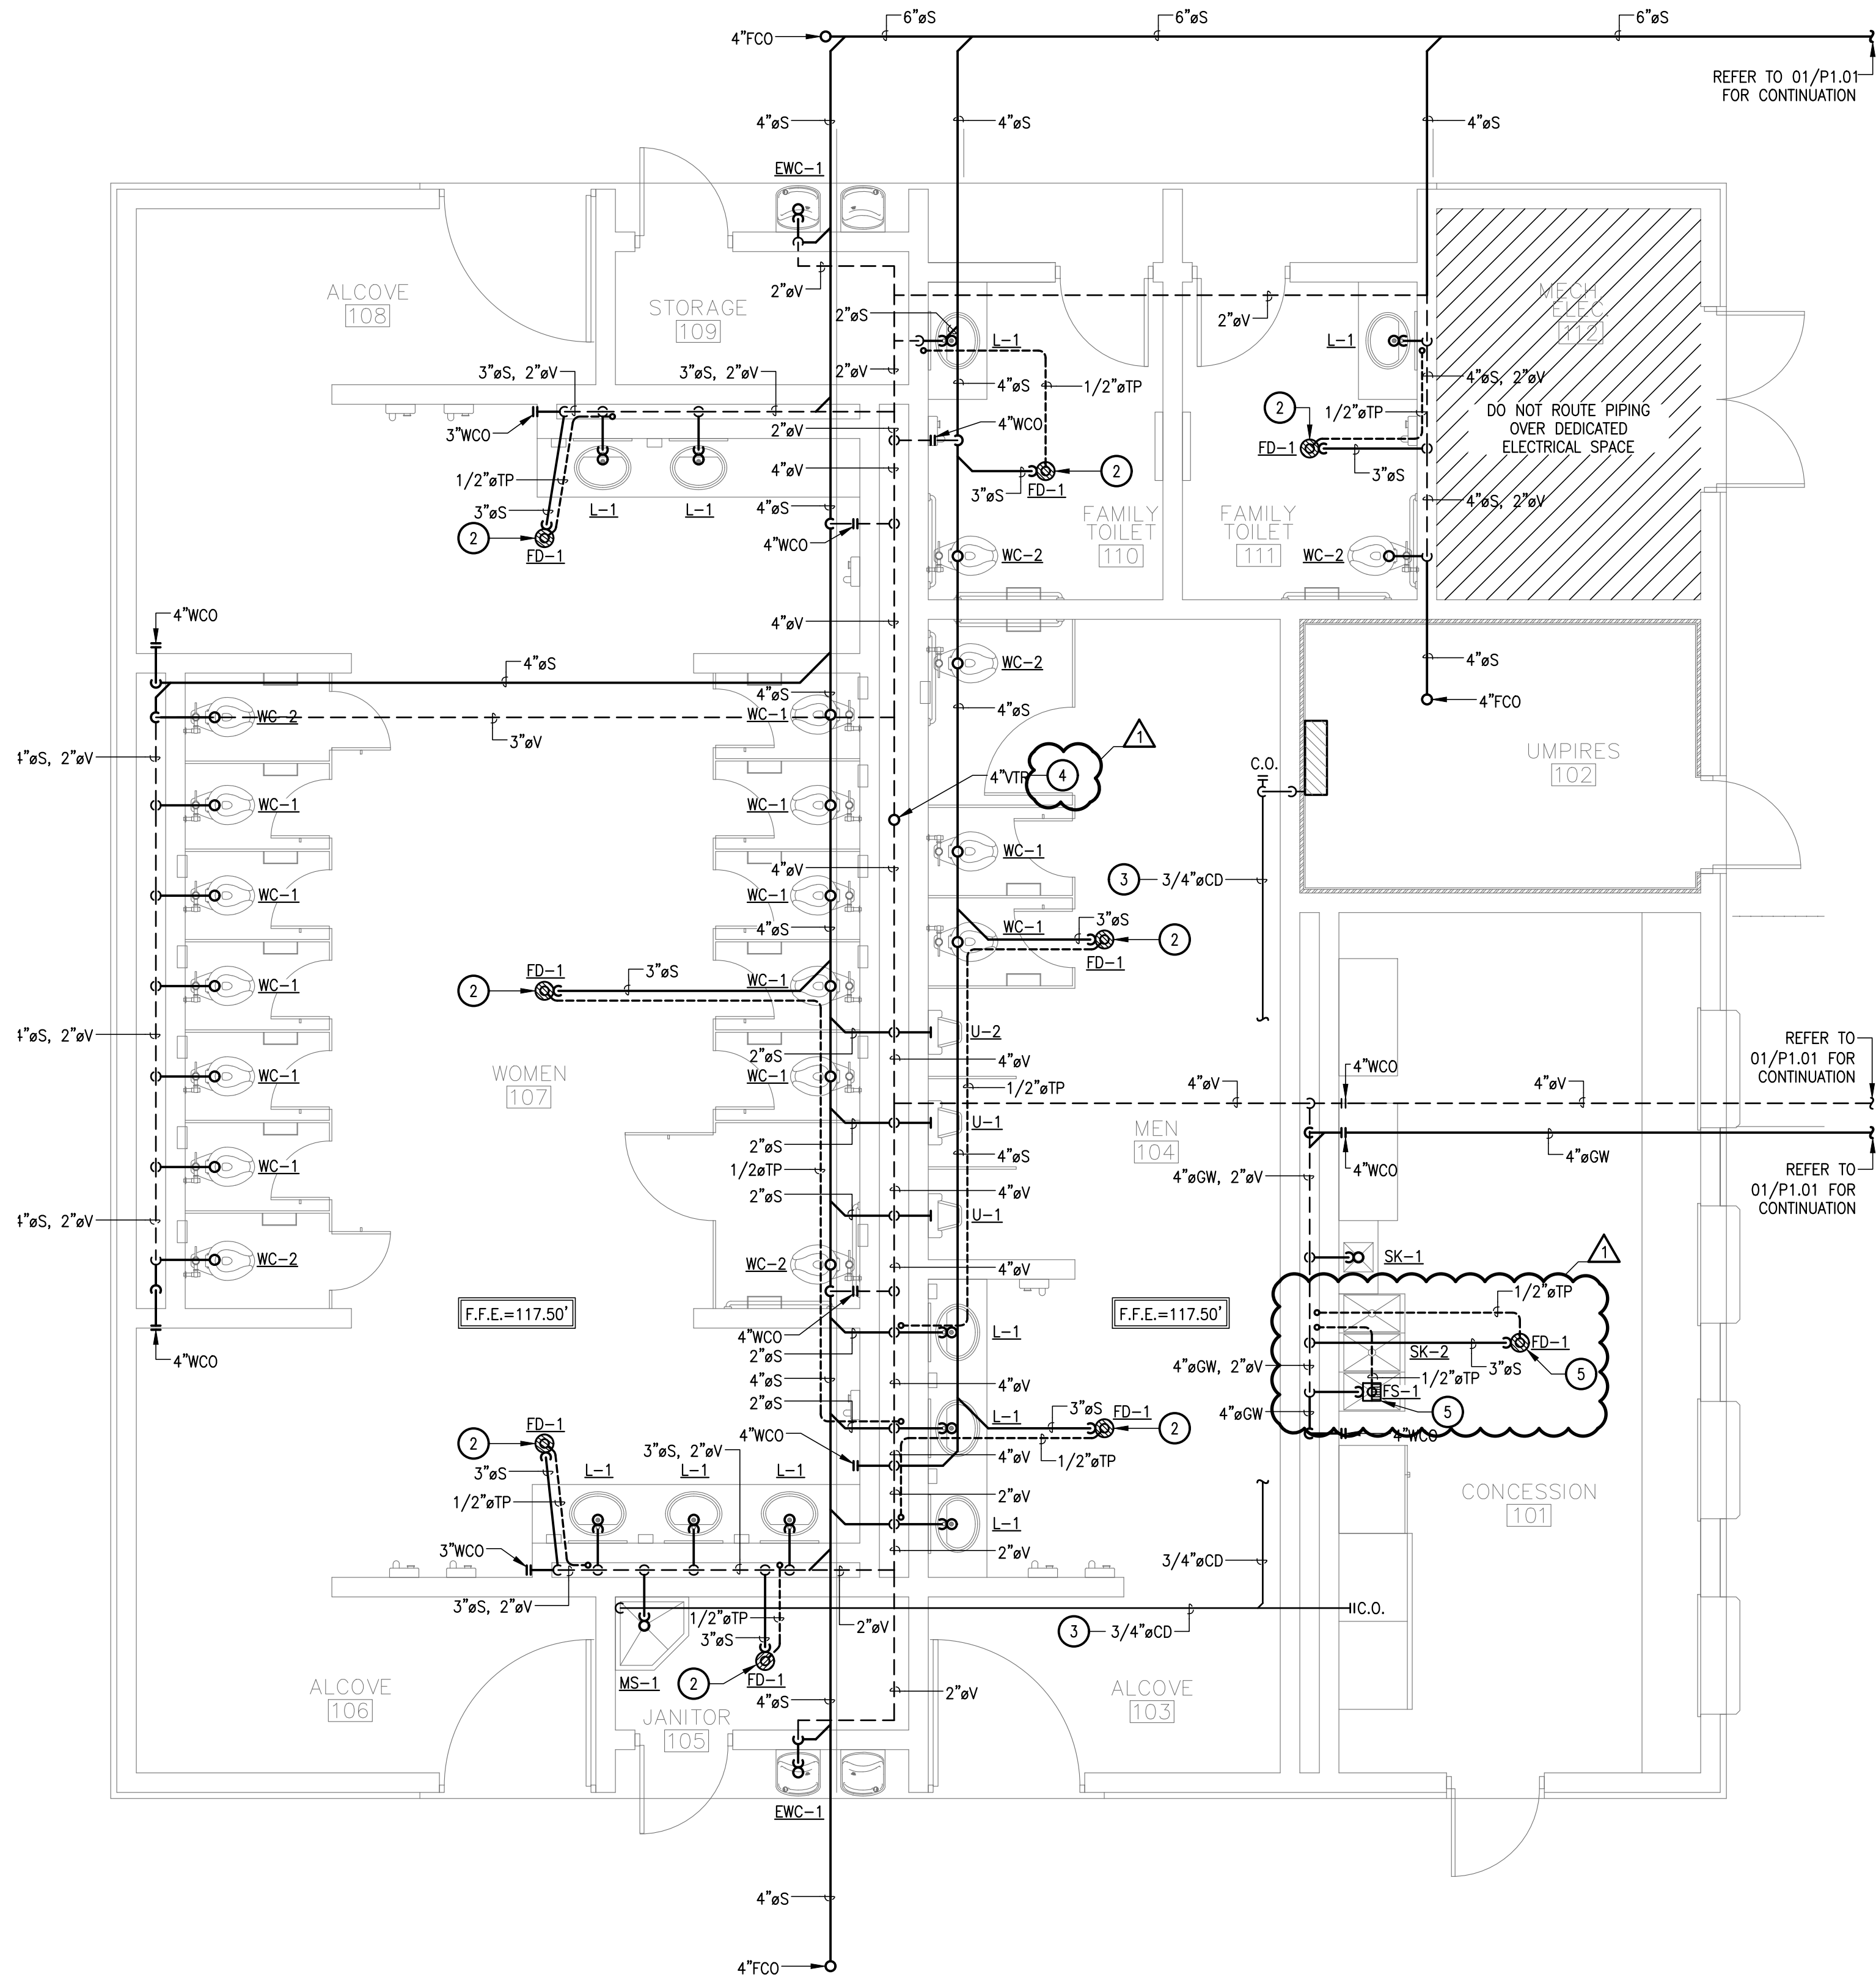

GENERAL NOTES:

A. REFER TO P0.01 FOR PLUMBING GENERAL NOTES.

KEY NOTES: Ⓢ

1. SHUT-OFF VALVE IN CAST BOX SET FLUSH WITH FINISH GRADE.
2. FLOOR DRAIN SHALL BE PRIMED WITH 1/2" PIPE FROM NEAREST LAVATORY P-TRAP TAILPIECE. REFER TO DETAIL 06 ON SHEET P2.01 FOR REQUIREMENTS.
3. PROVIDE AND INSTALL INSULATED COPPER CONDENSATE DRAIN LINE IN ATTIC SPACE. PROVIDE PIPE HANGER SUPPORTS MAXIMUM 5'-0" O.C. SPACING. SLOPE PIPING 1/8" INCH PER FOOT. ROUTE AND DROP CONDENSATE LINE EXPOSED ALONG THE WALL INTO NEAREST MOP SINK. CLAMP PIPE SECURELY TO WALL.
4. RISE VENT AND TERMINATE INSIDE VENTILATED ROOF CUPULA. REFER TO ARCHITECTURAL PLANS FOR CUPULA INFORMATION. DO NOT PENETRATE ROOF WITH VENT.
5. FLOOR DRAIN/FLOOR SINK SHALL BE PRIMED FROM TRAP PRIMER VALVE ABOVE CEILING. REFER TO DOMESTIC WATER PLAN 01/P1.01 FOR TRAP PRIMER VALVE LOCATION ABOVE CEILING.

WHERE BEAM PENETRATIONS ARE REQUIRED FOR PROPER SLOPE AND CONNECTION OF SEWER LINE, PIPES SHALL BE SLEEVED. COORDINATE ANY BEAM PENETRATION WITH STRUCTURAL ENGINEER.

PLUMBING CONTRACTOR SHALL COORDINATE DOMESTIC WATER AND SANITARY SEWER LINE DIRECTION OF FLOW, SIZE, INVERT, AND POINT OF CONNECTION WITH CIVIL PLANS PRIOR TO INSTALLATION OF ROUGH-IN TO AVOID CONFLICT. ANY DISCREPANCIES FOUND BY THE PLUMBING CONTRACTOR SHALL BE REPORTED TO THE ENGINEER/ARCHITECT IMMEDIATELY AND PRIOR TO ANY INSTALLATION. FAILURE TO COMPLY SHALL MAKE ALL CORRECTIONS AND/OR MODIFICATIONS THE FULL RESPONSIBILITY OF THE CONTRACTOR.

CITY OF MCALEN
SOFTBALL FIELD FACILITIES
MUNICIPAL PARK
MCALEN, TEXAS



HALFF
5000 WEST MILITARY, SUITE 100
MCALEN, TEXAS 78503
TEL: (361) 664-0282
FAX: (361) 664-0282
TBE FIRM #312


Revision No.	Date	Description	Addendum #1
1	7-26-2018		



100%
CONSTRUCTION
DOCUMENTS

Project No.:	33348
Issued:	07-11-18
Drawn By:	E.M.
Checked By:	H.A.
Scale:	AS NOTED
Sheet Title	PLUMBING PARTIAL SITE PLAN AND SANITARY SEWER PLAN
P1.01	Sheet Number

File Name: i:\33000s\33348\00\WEP\CADD\PI.02-PL-33348.dwg
Current Tab (Layout): PI.02 User: AH1497
Printed Date: 7/25/2018 2:29:58 PM

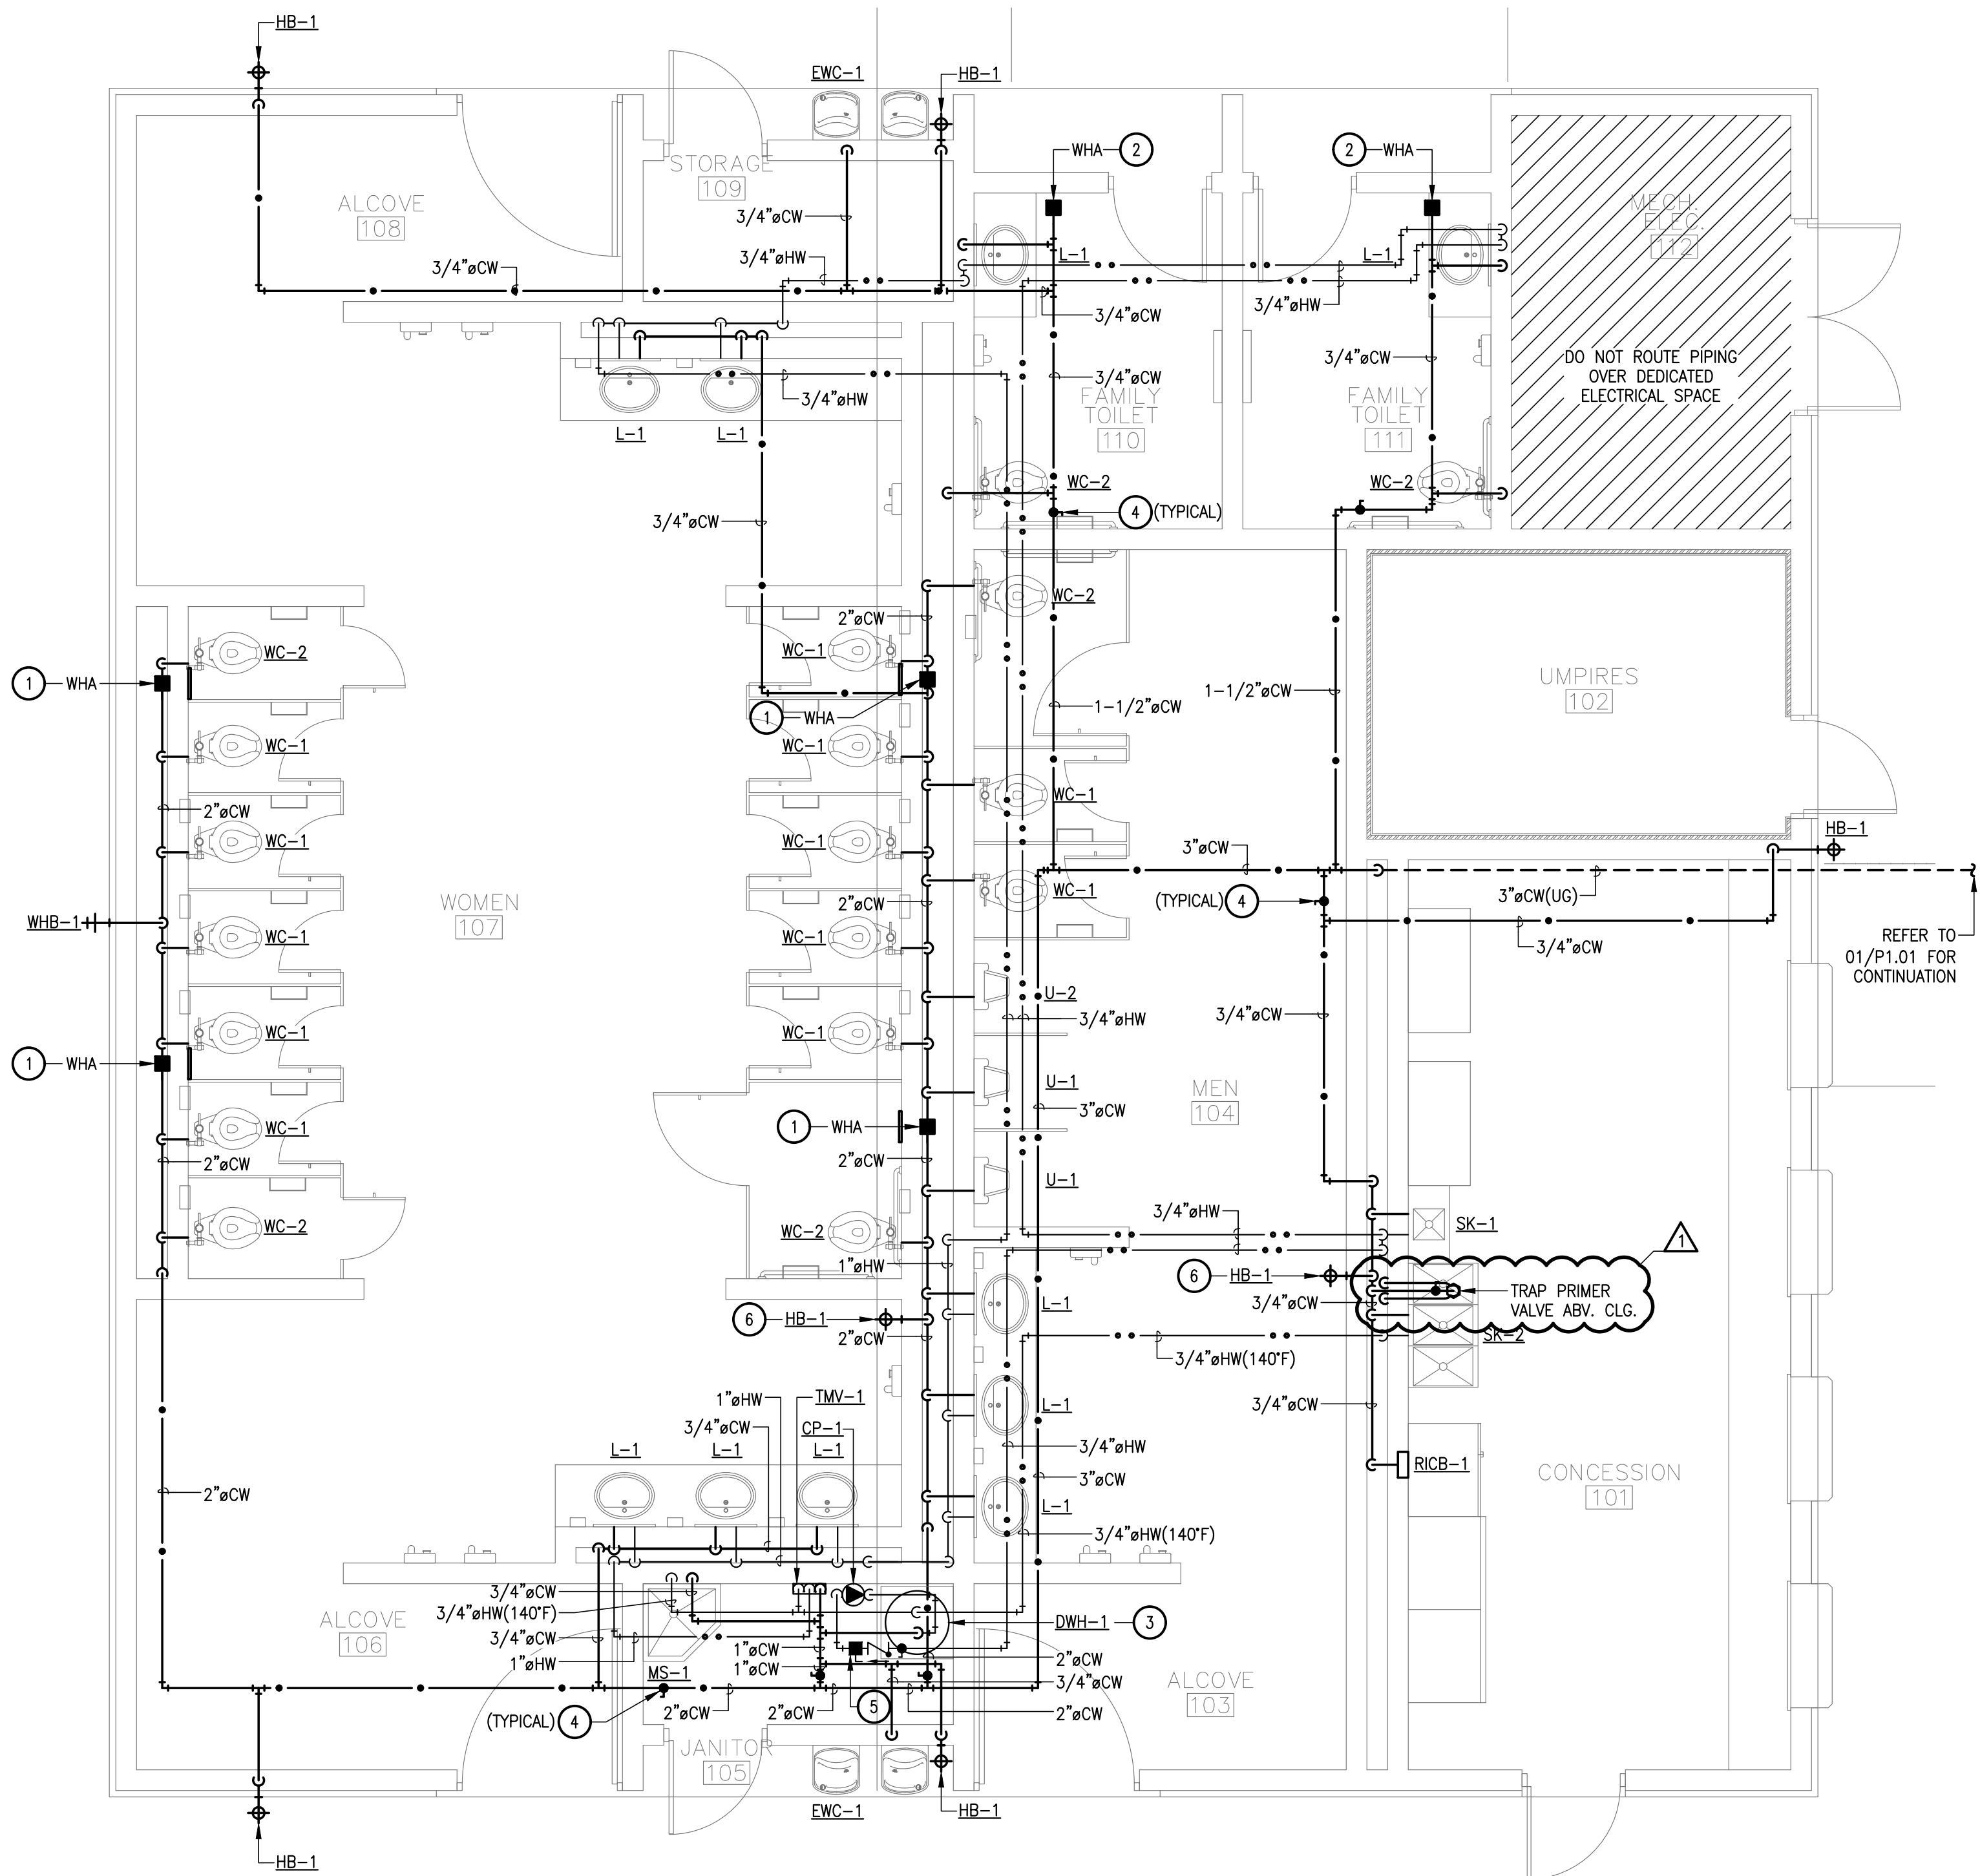

GENERAL NOTES:

A. REFER TO P0.01 FOR PLUMBING GENERAL NOTES.

KEY NOTES: Ⓢ

1. WATER HAMMER ARRESTOR IN CHASE. WHERE INACCESSIBLE PROVIDE AND INSTALL 12"x12" HINGED 16 GAUGE STEEL ACCESS PANEL WITH LOCKABLE KEYED DOOR. PRIME COATED WITH RUST INHIBITIVE ELECTROSTATIC POWDER, BAKED GREY ENAMEL AND SHALL BE PAINTED TO MATCH SURROUNDING AREAS. COORDINATE LOCATION TO AVOID CONFLICTS WITH PLUMBING FIXTURE(S), STALL PARTITION AND/OR GRAB BARS.
2. WATER HAMMER ARRESTOR ABOVE CEILING. WHERE INACCESSIBLE PROVIDE AND INSTALL 12"x12" HINGED 16 GAUGE STEEL ACCESS PANEL WITH LOCKABLE KEYED DOOR. PRIME COATED WITH RUST INHIBITIVE ELECTROSTATIC POWDER, BAKED GREY ENAMEL AND SHALL BE PAINTED TO MATCH SURROUNDING AREAS. COORDINATE LOCATION TO AVOID CONFLICTS WITH LIGHT FIXTURES AND MECHANICAL EQUIPMENT ON CEILING.
3. PROVIDE AND INSTALL SHUT-OFF VALVES ON ALL INLETS AND OUTLETS OF WATER HEATER, CIRCULATING PUMP AND THERMOSTATIC MIXING VALVE.
4. SHUT-OFF VALVE ABOVE CEILING. WHERE INACCESSIBLE PROVIDE AND INSTALL 12"x12" HINGED 16 GAUGE STEEL ACCESS PANEL WITH LOCKABLE KEYED DOOR. PRIME COATED WITH RUST INHIBITIVE ELECTROSTATIC POWDER, BAKED GREY ENAMEL AND SHALL BE PAINTED TO MATCH SURROUNDING AREAS. COORDINATE LOCATION TO AVOID CONFLICTS WITH LIGHT FIXTURES AND MECHANICAL EQUIPMENT ON CEILING.
5. BALANCING VALVE, CHECK VALVE AND SHUT-OFF VALVE ABOVE CEILING. BALANCING VALVE SHALL BE SET TO 0.56PM.
6. HOSE BIB SHALL BE INSTALLED 1'-6" ABOVE FINISH FLOOR. LOCATE HOSE BIB IN WALL SPACE BETWEEN P-TRAP SOLID ENCLOSURE AND APPROACH EDGE OF COUNTERTOP. REFER TO ARCHITECTURAL PLANS FOR ENCLOSURE DIMENSIONS TO AVOID CONFLICT.

CITY OF MCALEN
SOFTBALL FIELD FACILITIES
MUNICIPAL PARK
MCALEN, TEXAS



Revision	Date	Description	Addendum #1
No.	1	7-26-2018	



100%
CONSTRUCTION
DOCUMENTS

Project No.:	33348
Issued:	07-11-18
Drawn By:	E.M.
Checked By:	H.A.
Scale:	AS NOTED
Sheet Title	PLUMBING DOMESTIC WATER PLAN
P1.02	
Sheet Number	

MATCHLINE; SEE SHEET L2.01

FIELD
3

TRANSFORMER
ENCLOSURE:
SAME SHEET

BASE DIMENSION
LINE

TAMARACK AVE

EXISTING PARKING LOT

EX. PARKING TO REMAIN

MAINTENANCE BUILDING
ALTERNATE NO. 3
SAME SHEET

EXISTING FENCE

MCALLEN MUNICIPAL POOL


EXISTING
RESTROOM

EXISTING SIDEWALK

BASE DIMENSION
LINE


N BICENTENNIAL BLVD

MATCHLINE; SEE SHEET L2.04


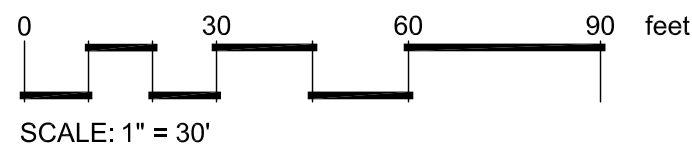


PLAN LEGEND:
P.A. - PLANTING AREA
P.O.B. - POINT OF BEGINNING
SIM. - SIMILAR
TYP. - TYPICAL


- PLAN NOTES:
1. POINT OF BEGINNING: CENTERPOINT OF LANDSCAPE FEATURE. REFER TO CIVIL ENGINEERING PAVING & DIMENSION CONTROL PLAN (C1.02) FOR COORDINATES.
 2. DIMENSIONS OF FIELDS 1, 2, AND 3: REF. SHEET L4.03; DIMENSIONS OF FIELDS 4, 5, AND 6: REF. SHEET L4.04

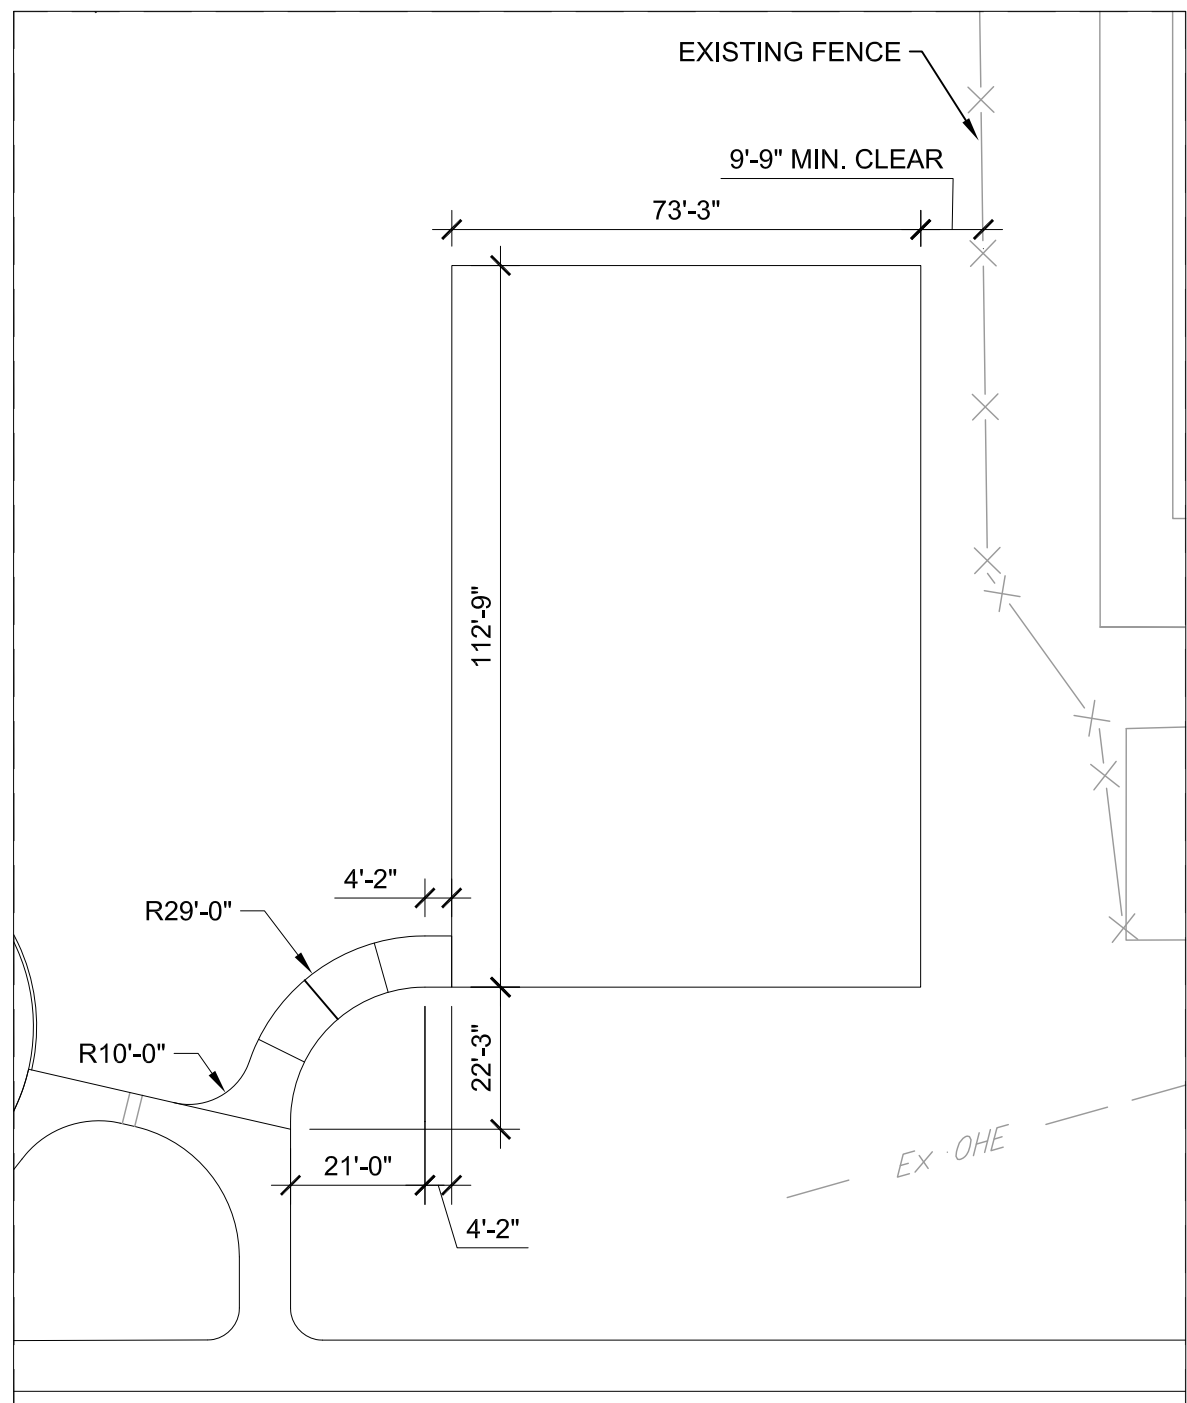

BASKETBALL COURT
ALTERNATE NO. 3

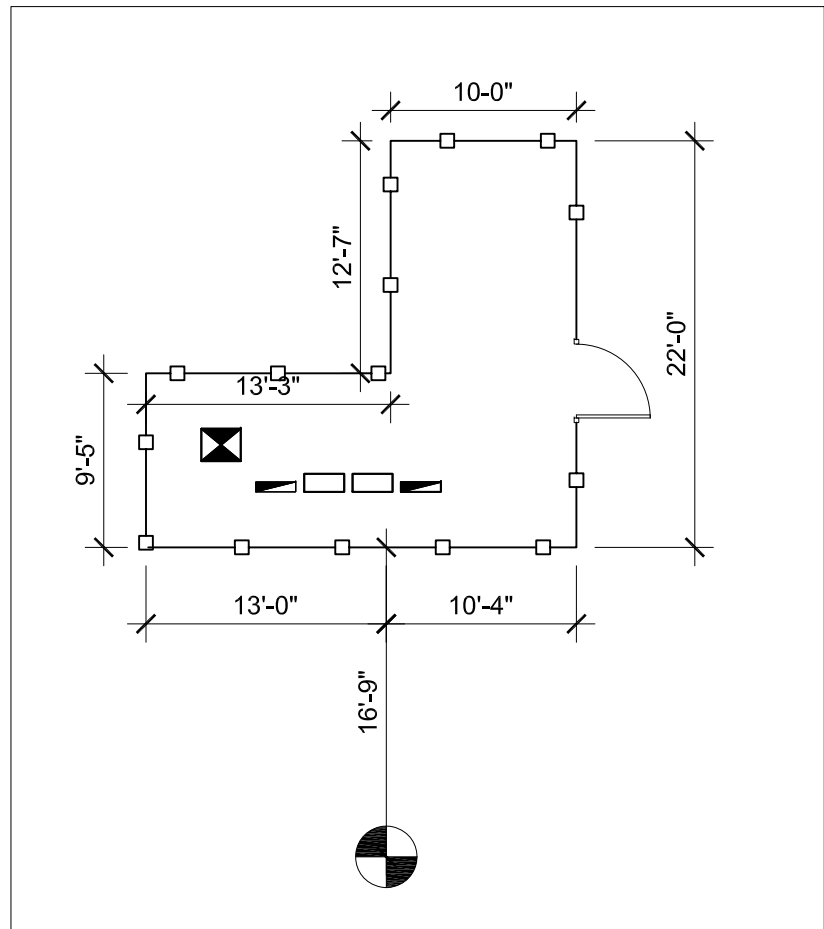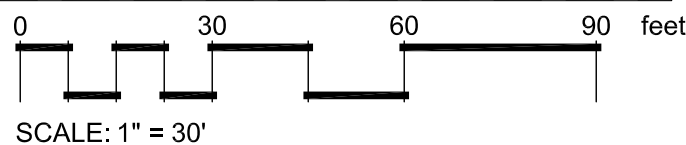

TRANSFORMER
ENCLOSURE

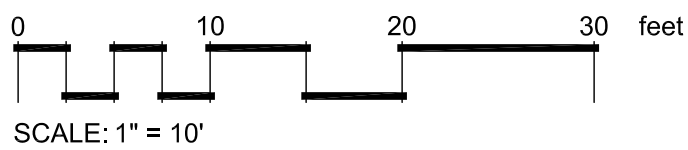

CITY OF MCALLEN
SOFTBALL FIELD FACILITIES
MUNICIPAL PARK
McALLEN, TEXAS



Revision No.	Date	Description
1	07-26-18	ADDENDUM NO. 1



100%
CONSTRUCTION
DOCUMENTS


Project No.: 33348.001
Issued: 07/11/2018
Drawn By: CE
Checked By: TM
Scale: AS SHOWN
Sheet Title

FLATWORK LAYOUT PLAN



L2.02

Sheet Number

MATCHLINE; SEE SHEET L3.01

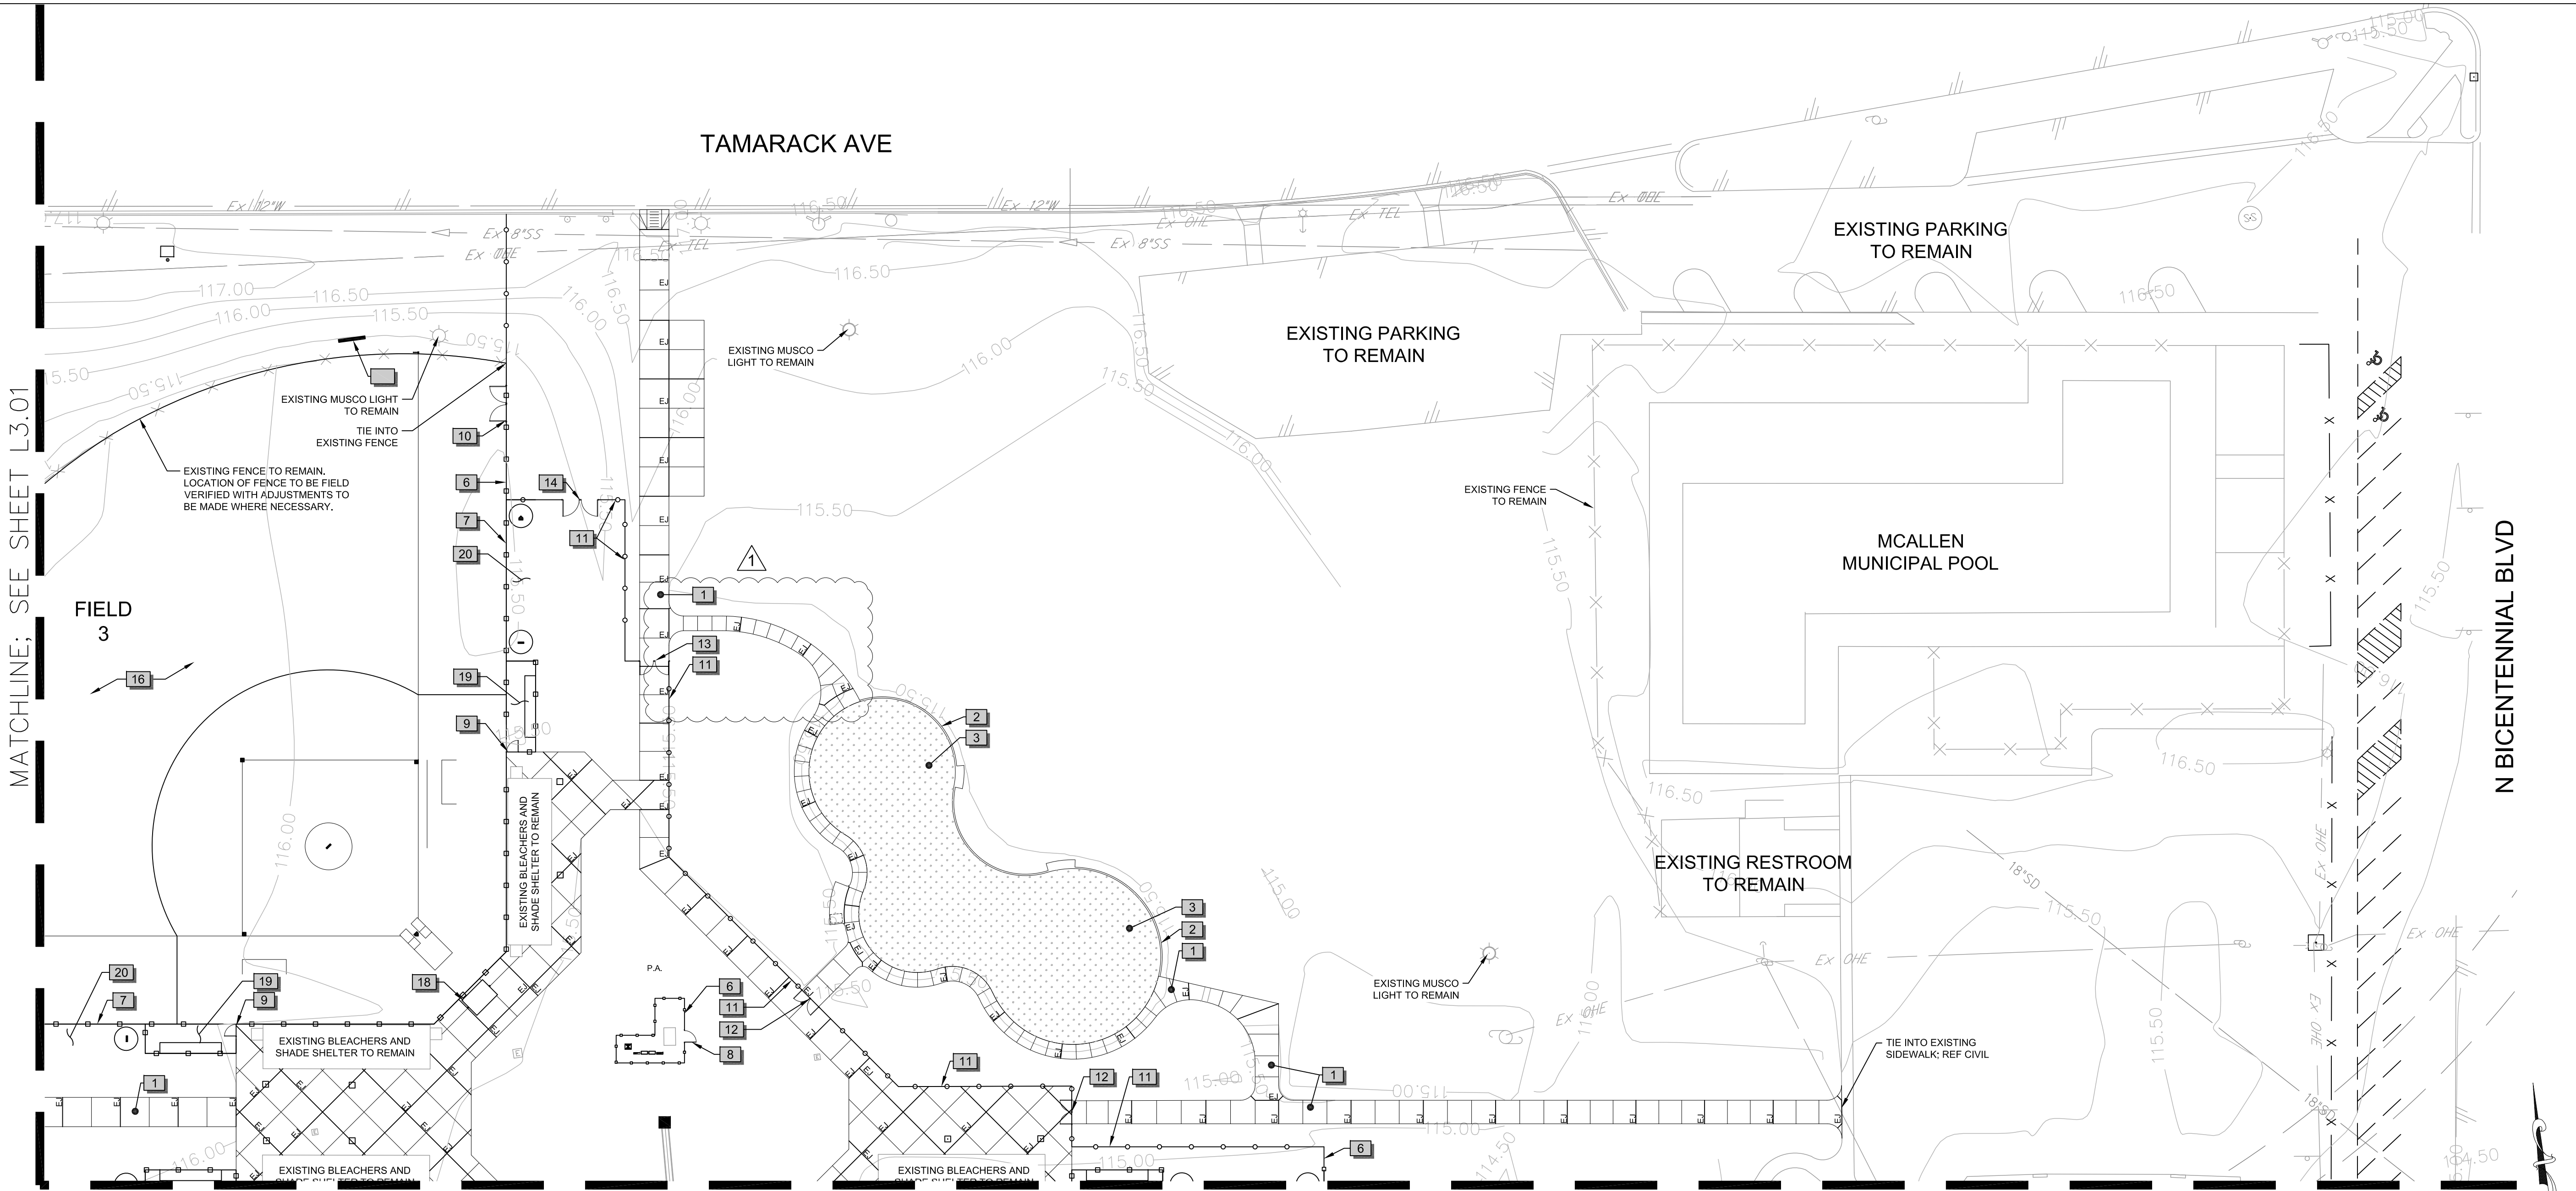

MATCHLINE; SEE SHEET L3.04

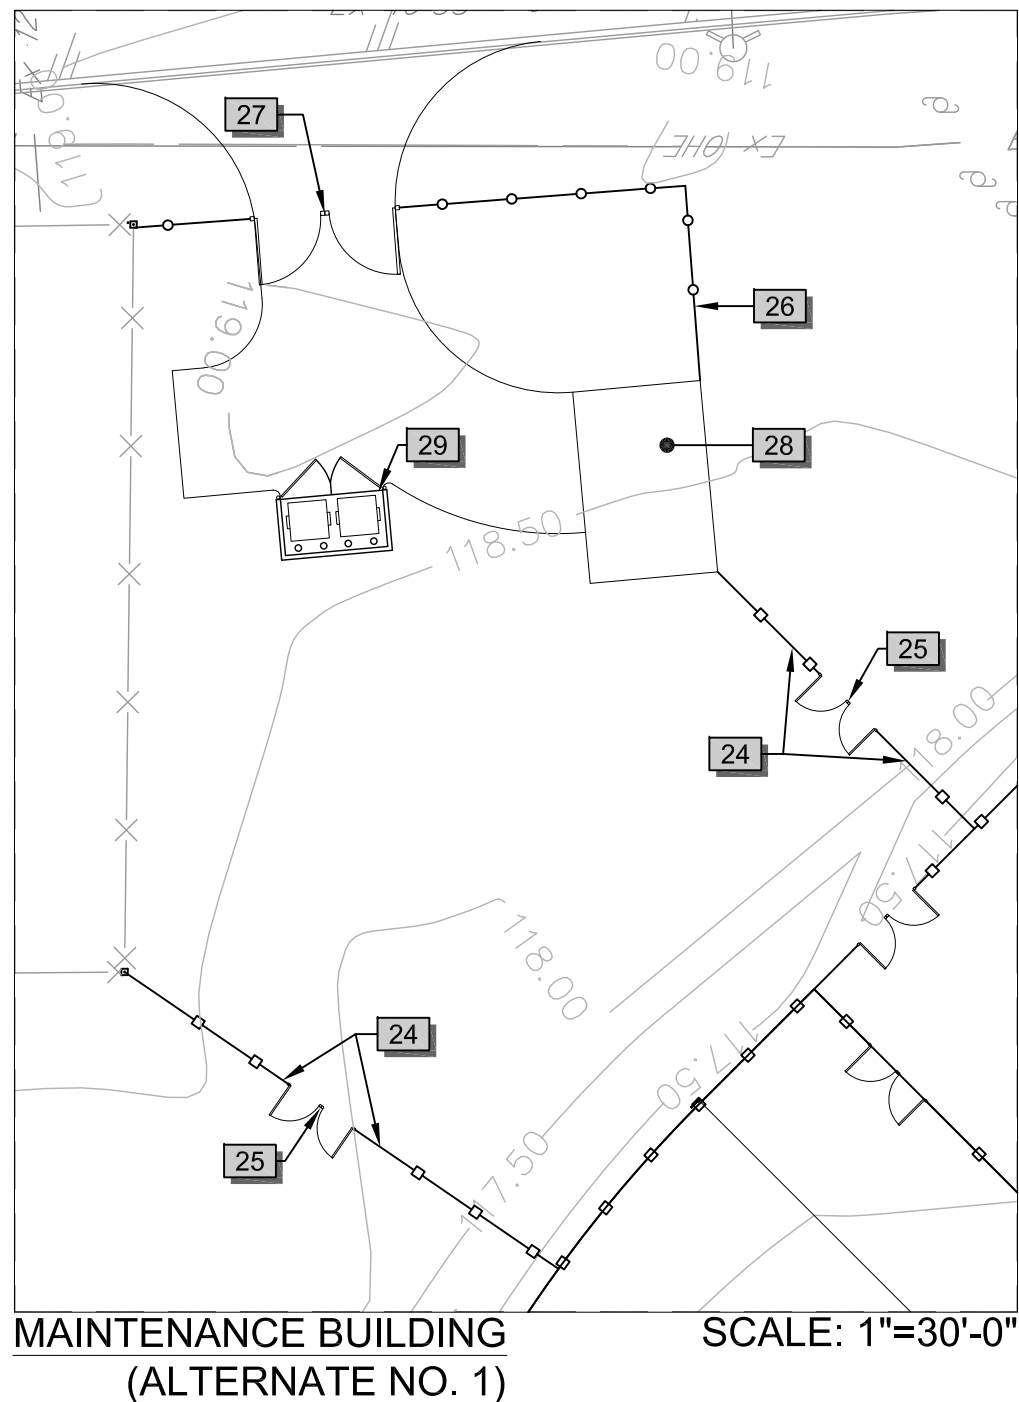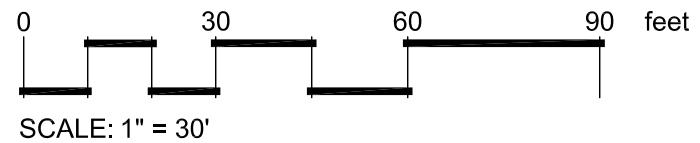

REFERENCE NOTES SCHEDULE

SYMBOL	DESCRIPTION	DETAIL	SYMBOL	DESCRIPTION	DETAIL
1	4" CONCRETE; REF. C8.00		16	SOFTBALL FIELD LAYOUT - FIELDS 1, 2, AND 3	1/L4.03
2	CONCRETE LANDSCAPE CURB		17	SOFTBALL FIELD LAYOUT - FIELDS 4, 5, AND 6	1/L4.04
3	FIBAR PLAYGROUND SURFACE; REF CIVIL SHEET C11.01		18	SCORE KEEPER'S CANOPY	2/L4.06
4	BOLLARD	1/L4.01	19	DUGOUT	4/L4.05
5	FLAG POLE; 35" [H]; 6" BUTT DIA., 3.5" TOP DIA. 13'-9" TAPER LENGTH; 6" X 10" MAX. FLAG SIZE, INSTALLED PER MANUFACTURER'S SPECIFICATIONS; SUBMIT PRODUCT FOR REVIEW AND APPROVAL BY LANDSCAPE ARCHITECT.		20	DUGOUT AND BULLPEN LAYOUT	5/L4.05
6	6' HEIGHT FENCE - CHAIN LINK	4/L4.01	21	SCOREBOARD - FIELDS 4, 5, & 6	1/L4.05
7	8' HEIGHT FENCE - CHAIN LINK	5/L4.01	22	BATTING TUNNEL	1/L4.06
8	6' HEIGHT SWING GATE - CHAIN LINK	8/L4.01	23	RESTROOMS/CONCESSION; REF ARCHITECTURE	
9	8' HEIGHT SWING GATE - CHAIN LINK	9/L4.01			
10	6' HEIGHT DOUBLE SWING GATE - CHAIN LINK	7/L4.01			
11	7' HEIGHT TUBULAR STEEL FENCE	1/L4.02			
12	7'[H] X 8'[W] DOUBLE SWING GATE - TUBULAR STEEL	2/L4.02			
13	7'[H] X 10'[W] DOUBLE SWING GATE - TUBULAR STEEL				
14	7'[H] X 12'[W] DOUBLE SWING GATE - TUBULAR STEEL	4/L4.02			
15	7'[H] X 16'[W] DOUBLE SWING GATE - TUBULAR STEEL	5/L4.02			

ADD ALTERNATES

SYMBOL	DESCRIPTION	DETAIL
24	6' HEIGHT FENCE - CHAIN LINK (ALTERNATE NO.1)	4/L4.01
25	6' HEIGHT DOUBLE SWING GATE - CHAIN LINK (ALTERNATE NO.1)	7/L4.01
26	7' HEIGHT TUBULAR STEEL FENCE (ALTERNATE NO.1)	1/L4.02
27	7'[H] X 24'[W] DOUBLE SWING GATE - TUBULAR STEEL (ALTERNATE NO.1)	6/L4.02
28	CONCRETE PAD FOR MAINTENANCE BUILDING (ALTERNATE NO. 1); REF STRUCTURAL	
29	DUMPSTER ENCLOSURE; DUMPSTER BY OTHERS (ALTERNATE NO.1)	10/L4.01

PLAN LEGEND

P.A. - PLANTING AREA
E.J. - EXPANSION JOINT
REFER TO CIVIL SHEET C8.00 FOR EXPANSION JOINT DETAIL

FENCE LEGEND

— x — x — x — EXISTING FENCE TO REMAIN
— o — o — o — PROPOSED CHAIN LINK FENCE
— | — | — | — PROPOSED TUBULAR STEEL FENCE
REFER TO SHEET L4.03 AND L4.04 FOR FIELD FENCING INFORMATION.

CITY OF McALLEN
SOFTBALL FIELD FACILITIES
MUNICIPAL PARK
McALLEN, TEXAS




5000 WEST MILITARY HWY, SUITE 100
TEL (956) 664-0286
FAX (956) 664-0282
TDD: (956) 664-0282

Revision No.	Date	Description
1	07-26-18	ADDENDUM NO.1



100%
CONSTRUCTION
DOCUMENTS

Project No.:	33348.001
Issued:	07/11/2018
Drawn By:	CE
Checked By:	TM
Scale:	AS SHOWN
Sheet Title	SITE PLAN
L3.02	Sheet Number

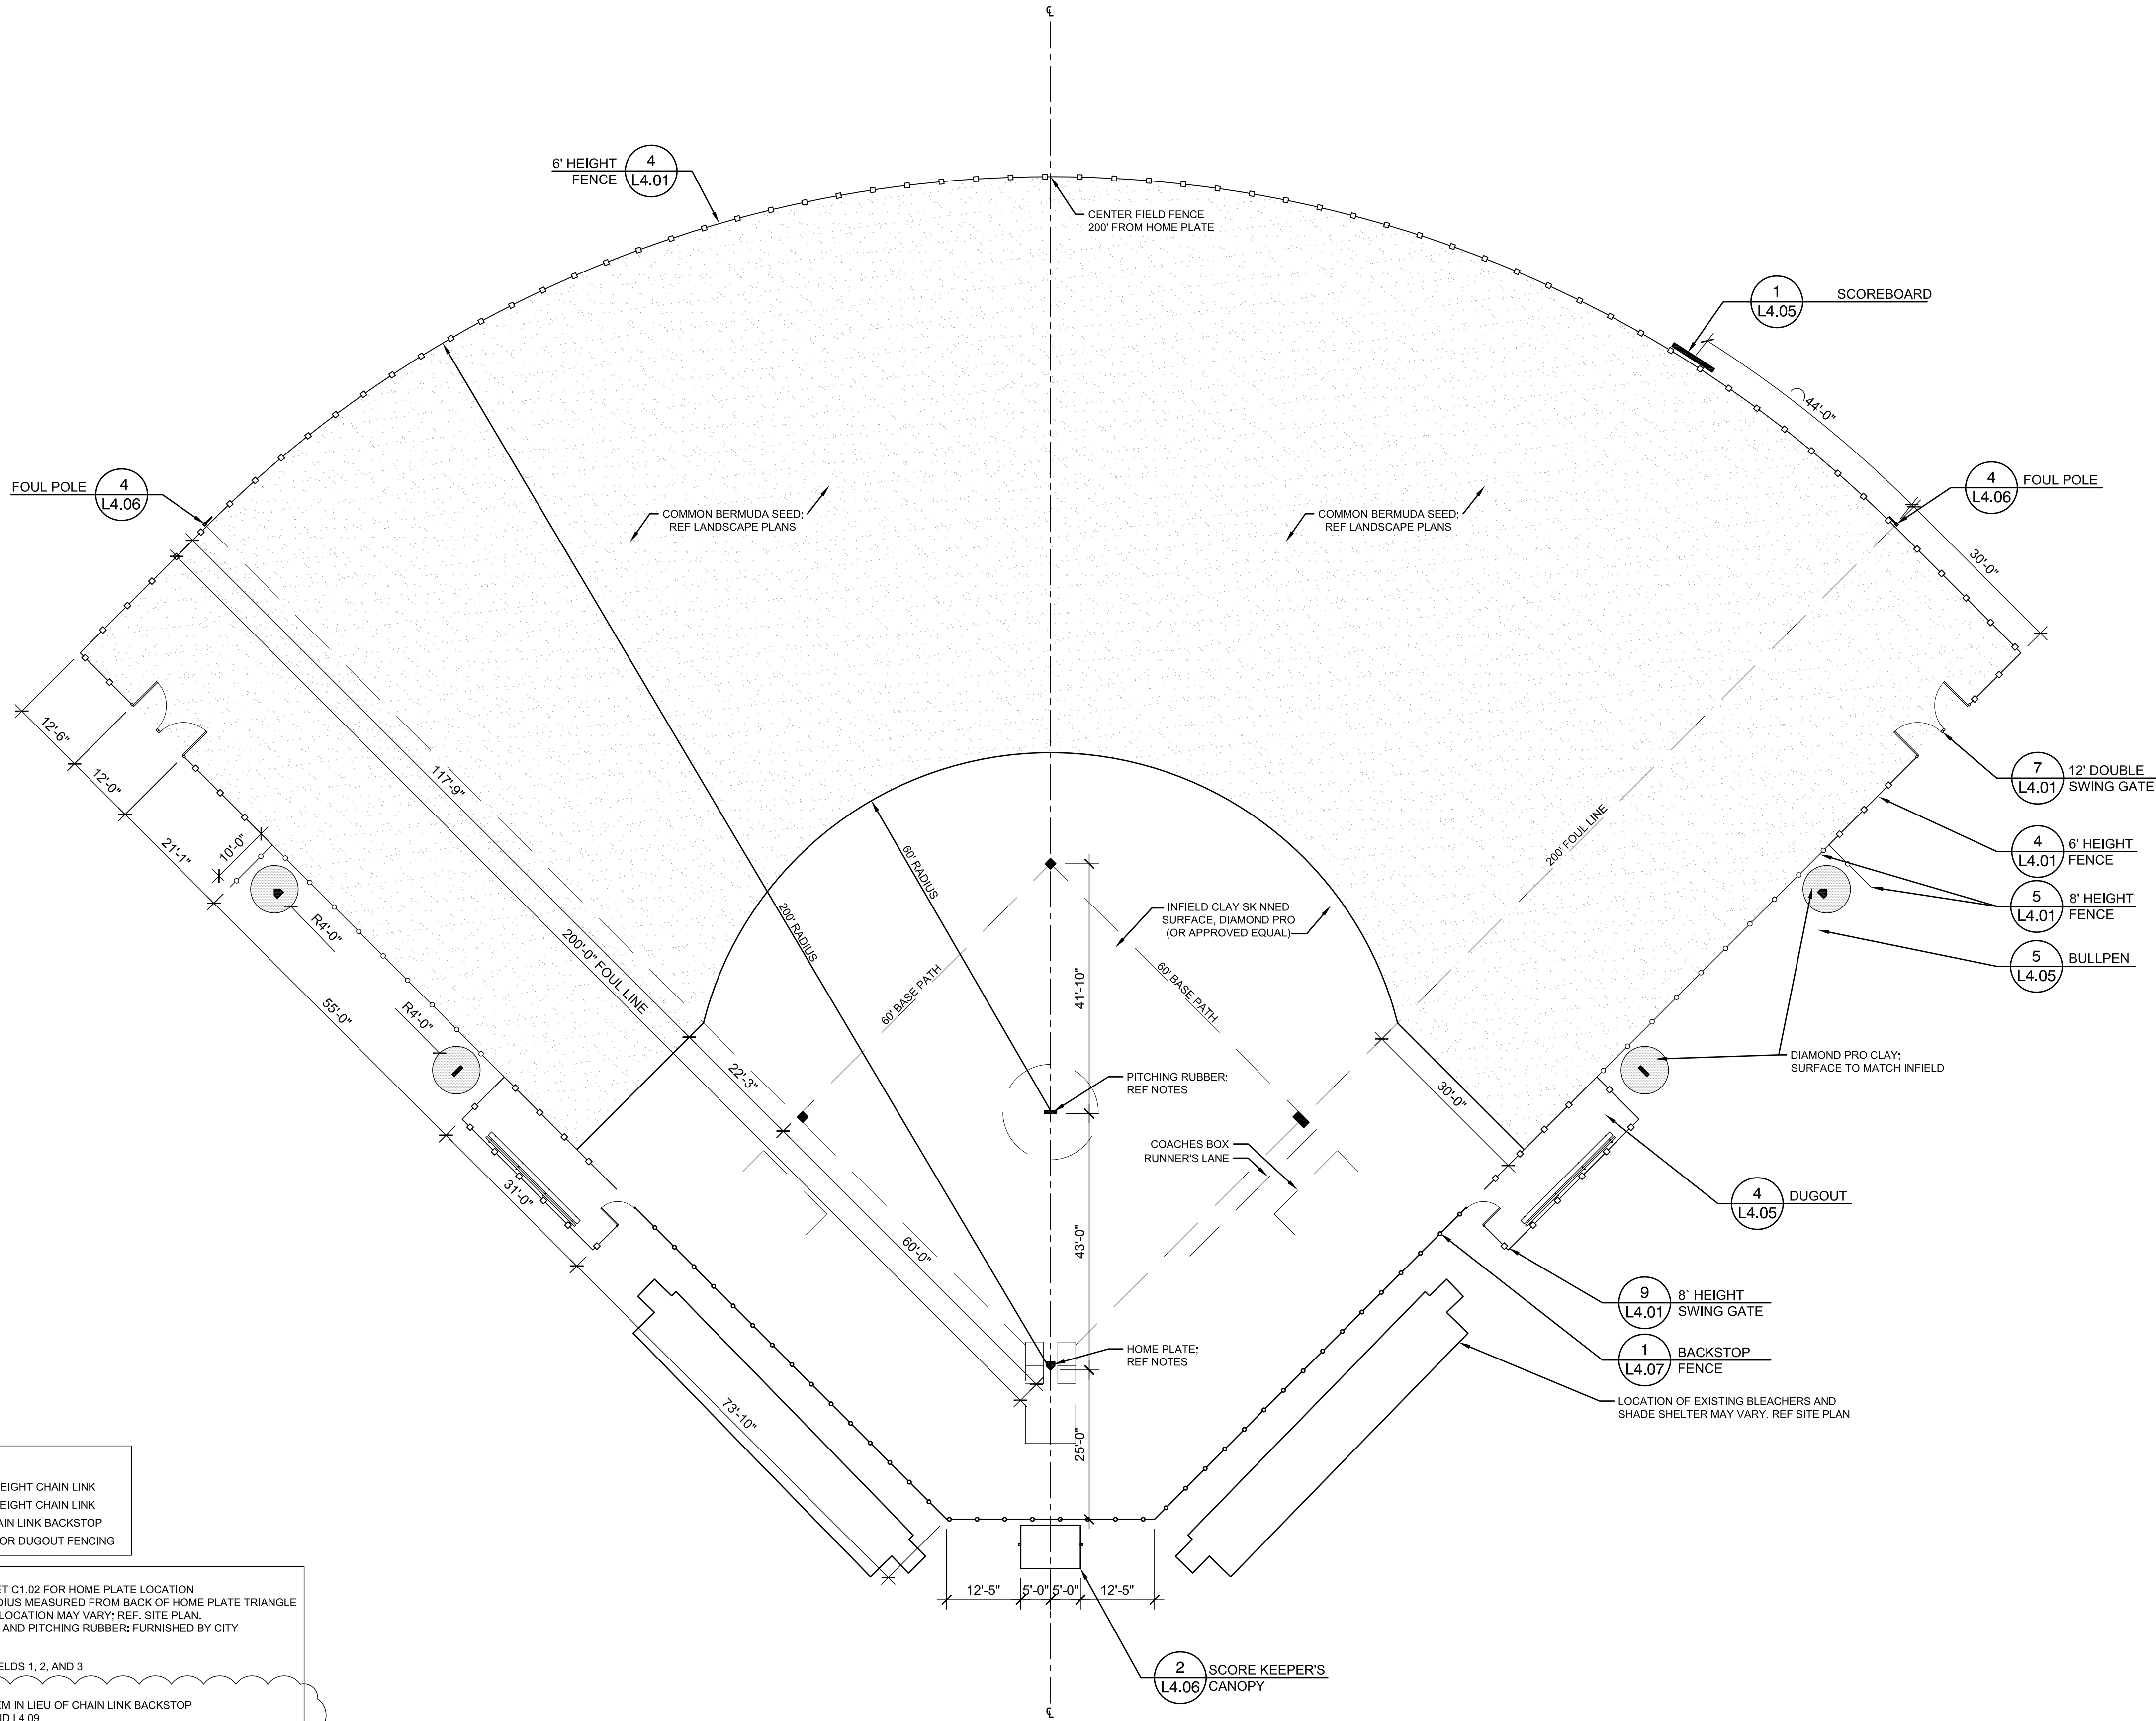

FENCE LEGEND	
	6' HEIGHT CHAIN LINK
	8' HEIGHT CHAIN LINK
	CHAIN LINK BACKSTOP
REFER TO DETAIL 4/L4.05 FOR DUGOUT FENCING	

- NOTES:
1. REFER TO CIVIL SHEET C1.02 FOR HOME PLATE LOCATION
 2. OUTFIELD FENCE RADIUS MEASURED FROM BACK OF HOME PLATE TRIANGLE
 3. MAINTENANCE GATE LOCATION MAY VARY; REF. SITE PLAN.
 4. BASES, HOME PLATE, AND PITCHING RUBBER: FURNISHED BY CITY

ALTERNATE NO. 4
NEW SCOREBOARD FOR FIELDS 1, 2, AND 3

ALTERNATE NO. 5
BACKSTOP NETTING SYSTEM IN LIEU OF CHAIN LINK BACKSTOP
REFER TO SHEETS L4.08 AND L4.09



5000 WEST MILITARY HWY, SUITE 100
FARMERSVILLE, TEXAS 77834
TEL (956) 664-4286
FAX (956) 664-4282
TDD (956) 664-4282

Revision No.	Date	Description
1	07-26-18	ADDENDUM NO. 1



100%
CONSTRUCTION
DOCUMENTS

Project No.:	33348.001
Issued:	07/11/2018
Drawn By:	CE
Checked By:	TM
Scale:	AS SHOWN
Sheet Title	


SITE DETAILS

L4.03


Sheet Number


$$1/4" = 1'-0"$$

$$1/4" = 1'-0"$$

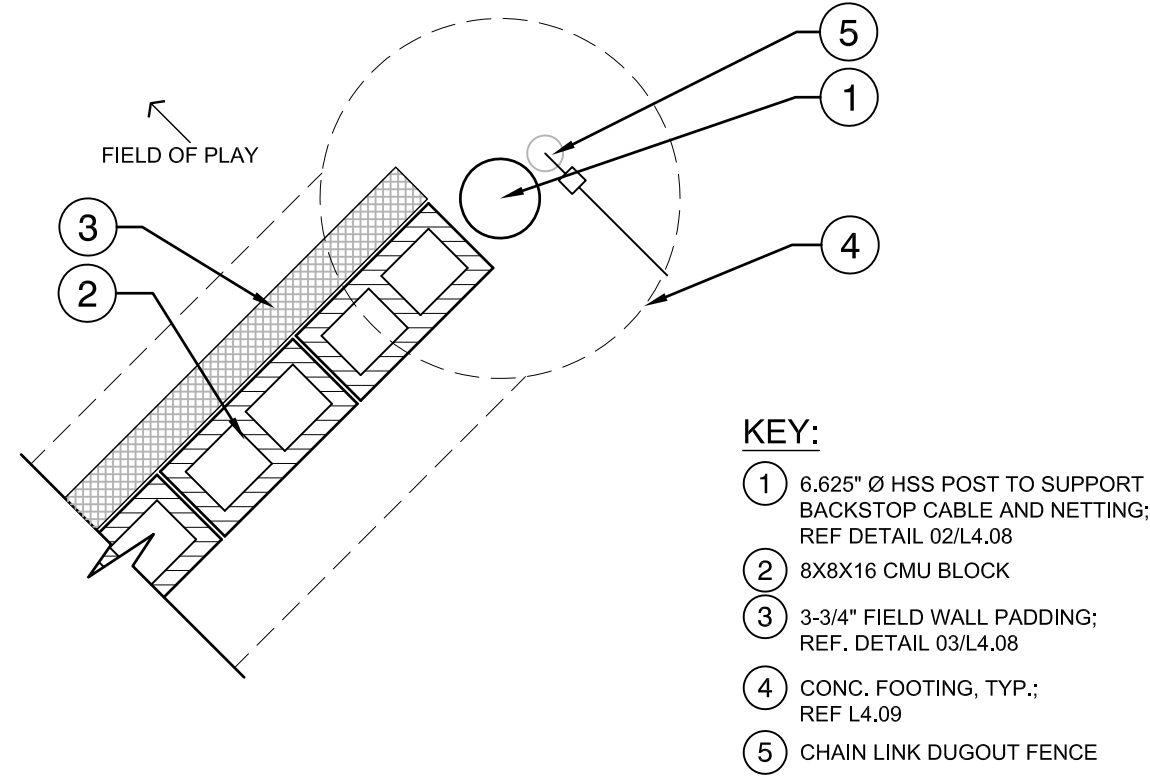


05 BACKSTOP WALL AT OUTSIDE CORNER ALTERNATE NO.5
3/4" = 1'-0"

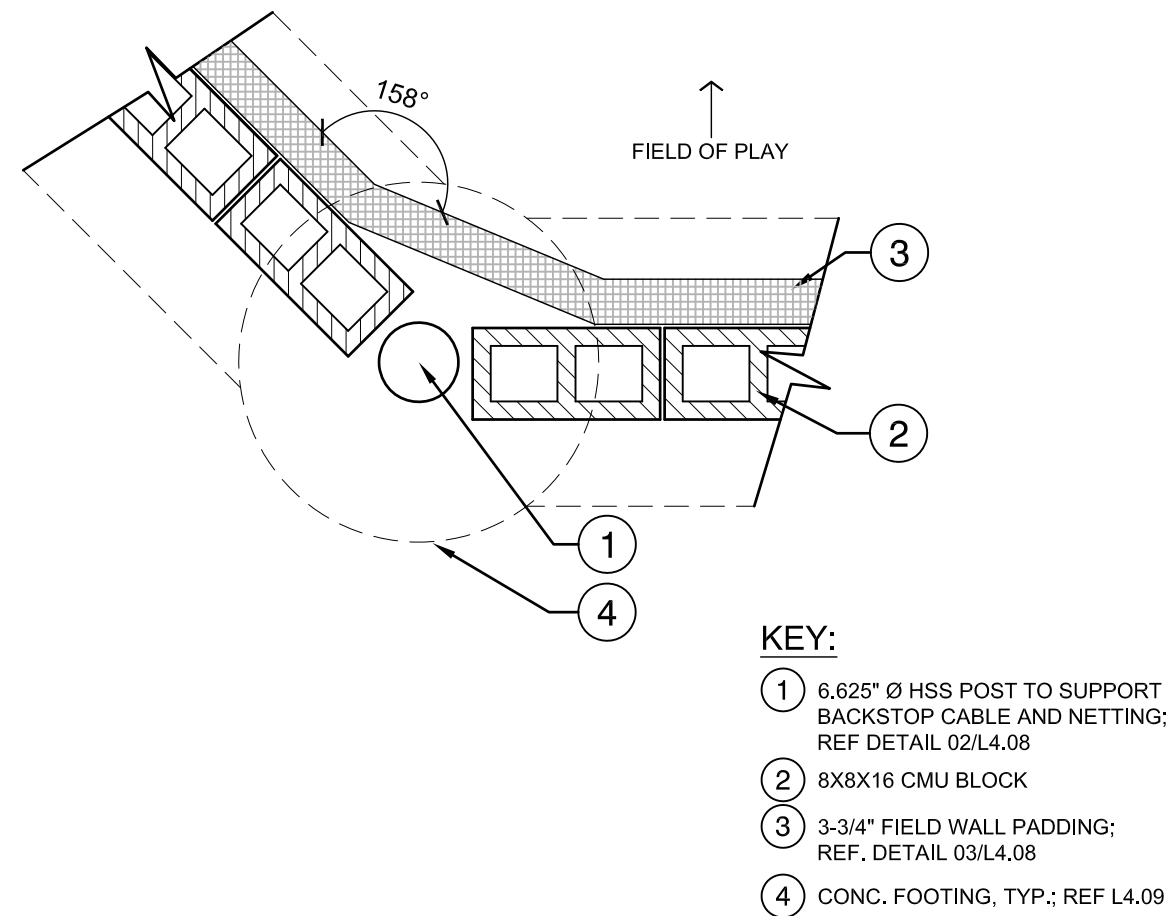


02 BACKSTOP NETTING ELEVATION
3/16" = 1'-0"

04 BACKSTOP WALL AT INSIDE CORNER ALTERNATE NO.5
3/4" = 1'-0"

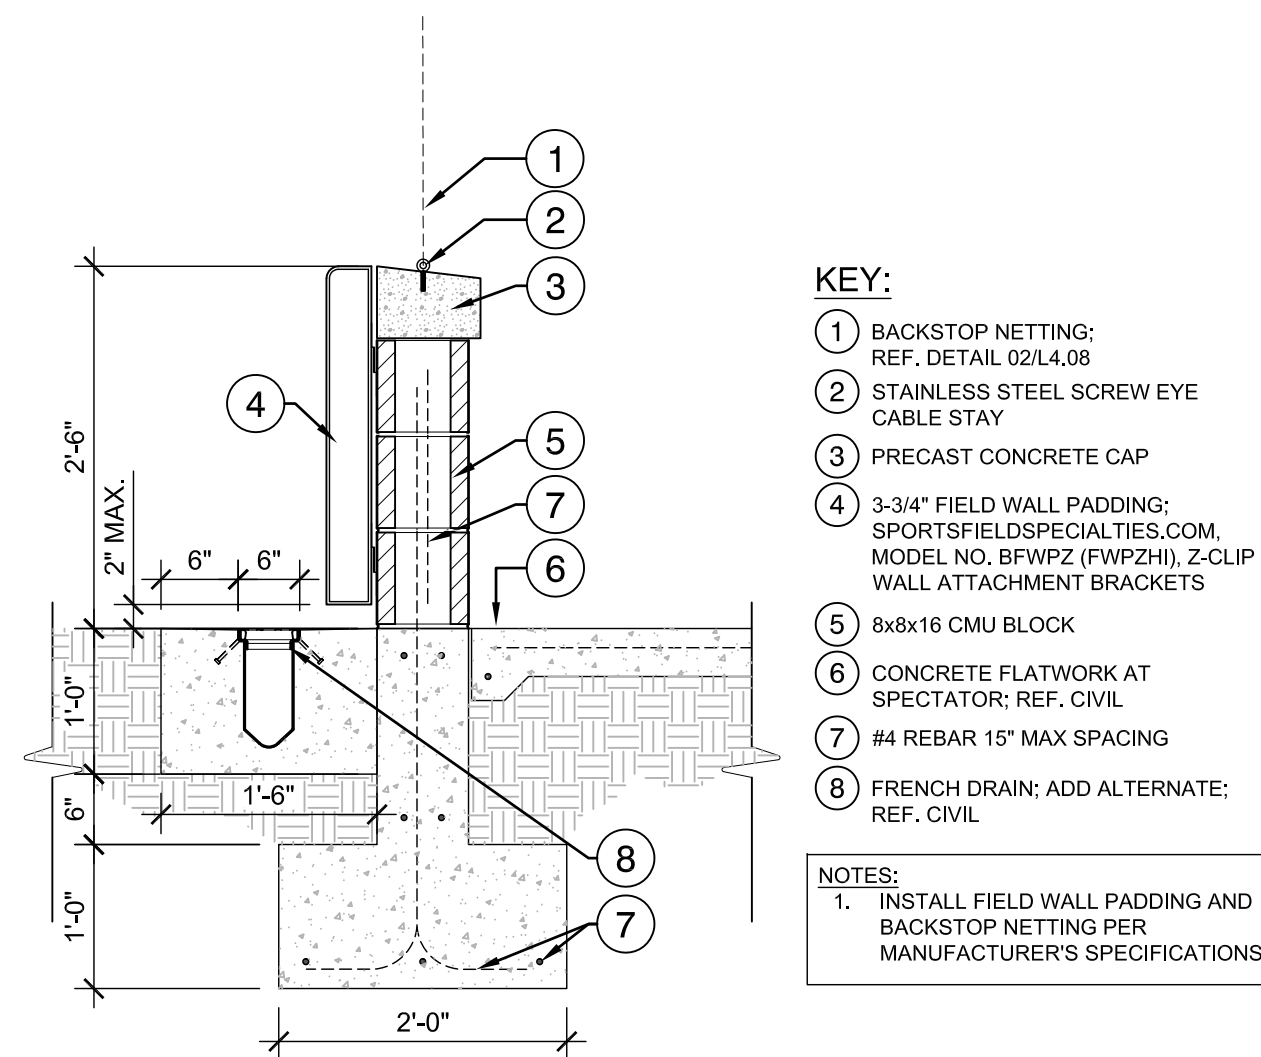

03 BACKSTOP WALL
3/4" = 1'-0"

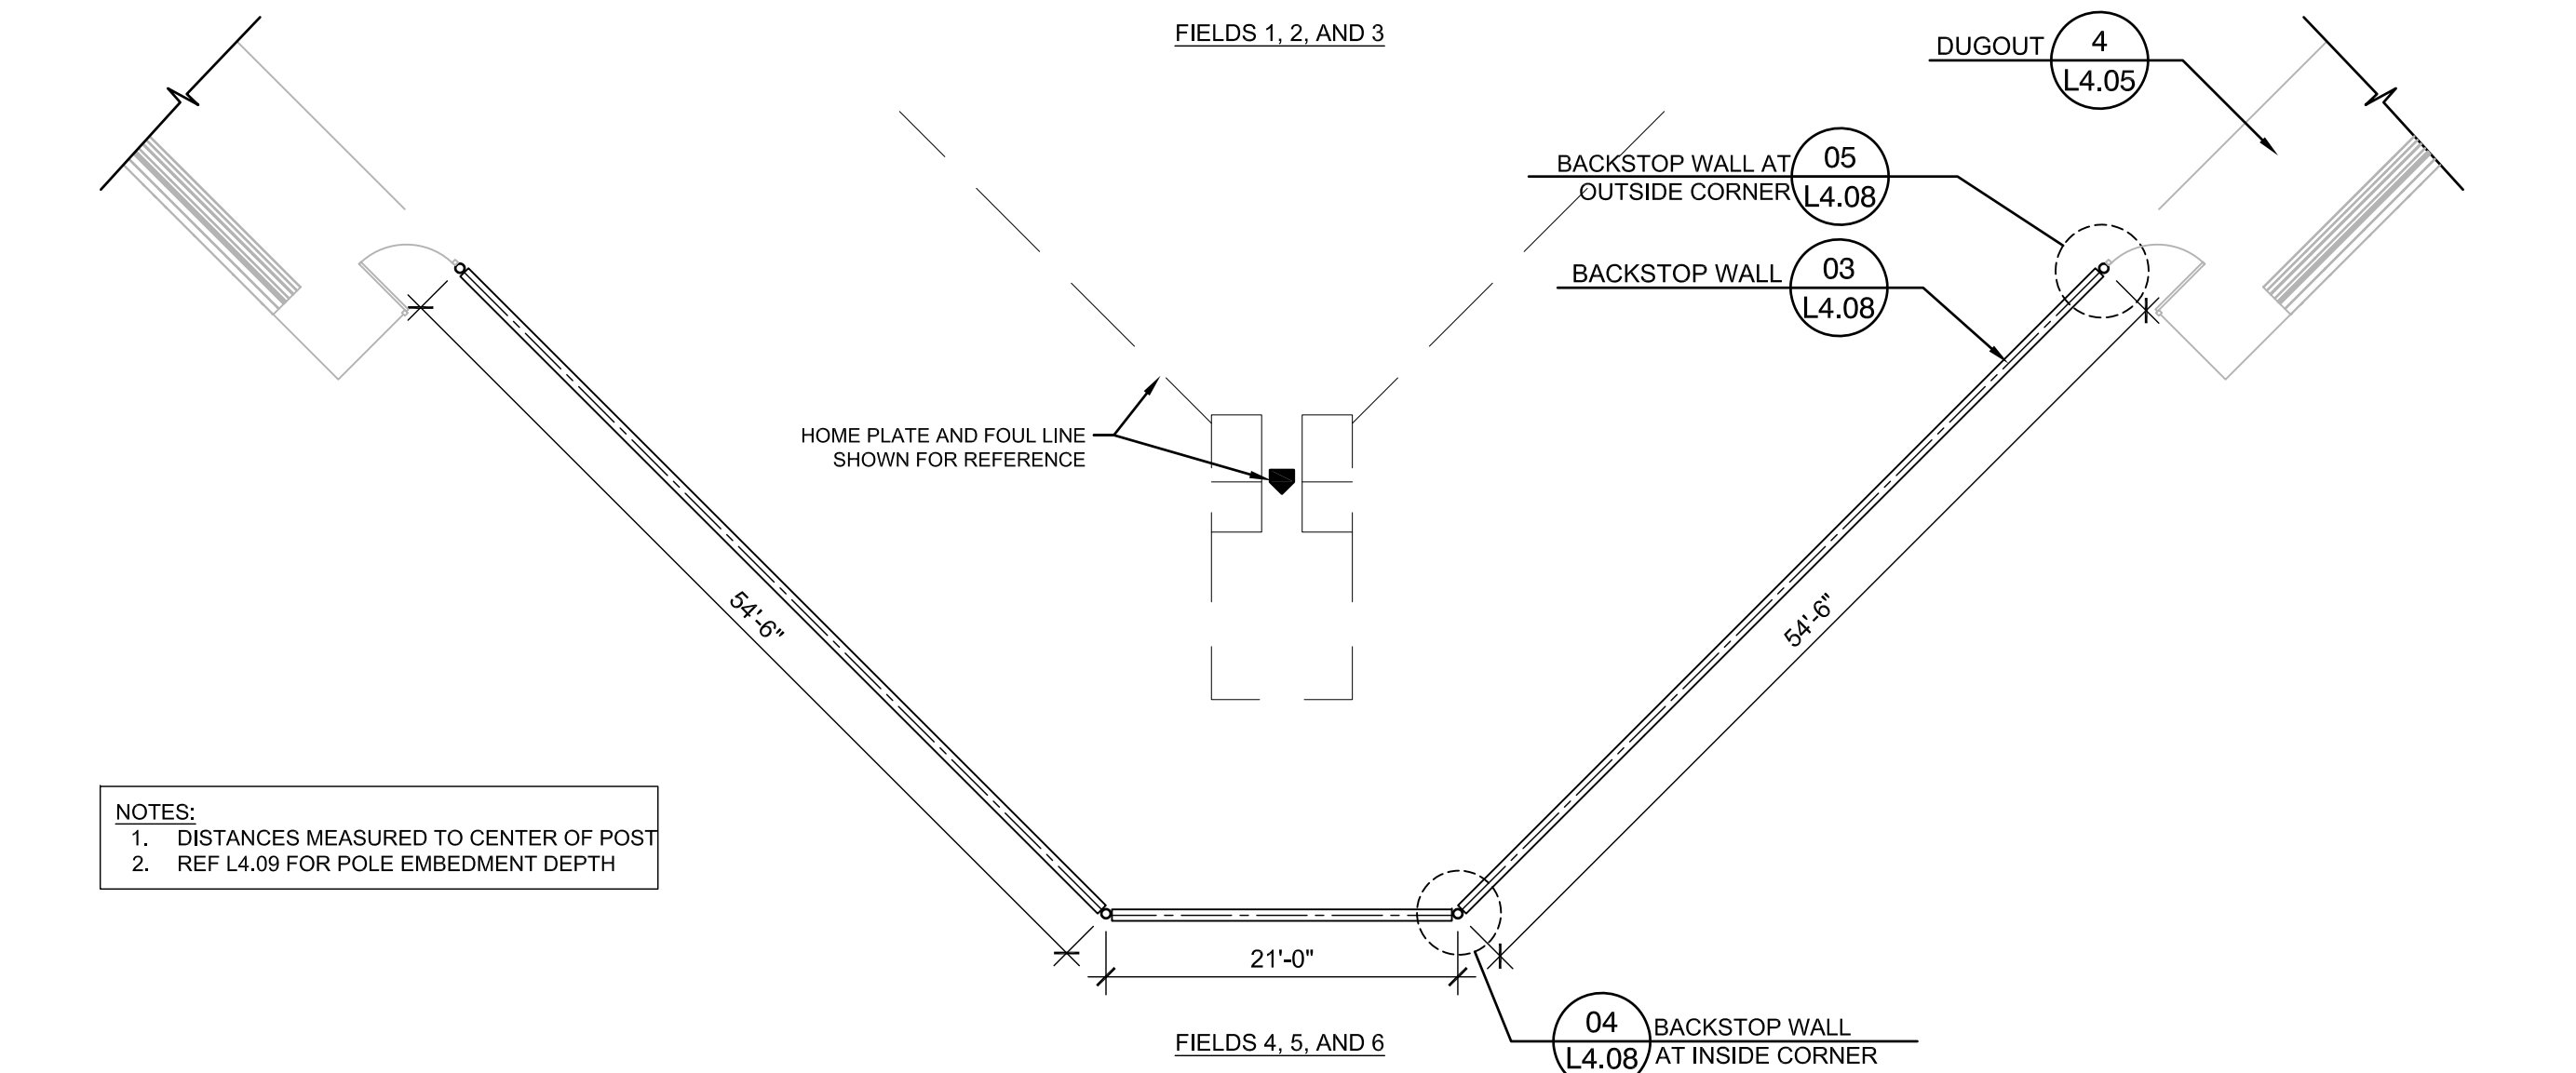

01 BACKSTOP NETTING POST LAYOUT
3/32" = 1'-0"

Revision No.	Date	Description
1	07-26-18	ADDENDUM NO. 1



100%
CONSTRUCTION
DOCUMENTS

Project No.: 33348.001
Issued: 07/11/2018
Drawn By: CE
Checked By: TM
Scale: AS SHOWN
Sheet Title

SITE DETAILS

L4.08

Sheet Number



McALLEN
Parks & Recreation



5000 WEST MILITARY HWY, SUITE 100
McALLEN, TX 78503
TEL (956) 664-0286
FAX (956) 664-0282
TBPB FIRM #F-312


[illegible]


100%
CONSTRUCTION
DOCUMENTS

Sheet Title

L4.09

Sheet Number

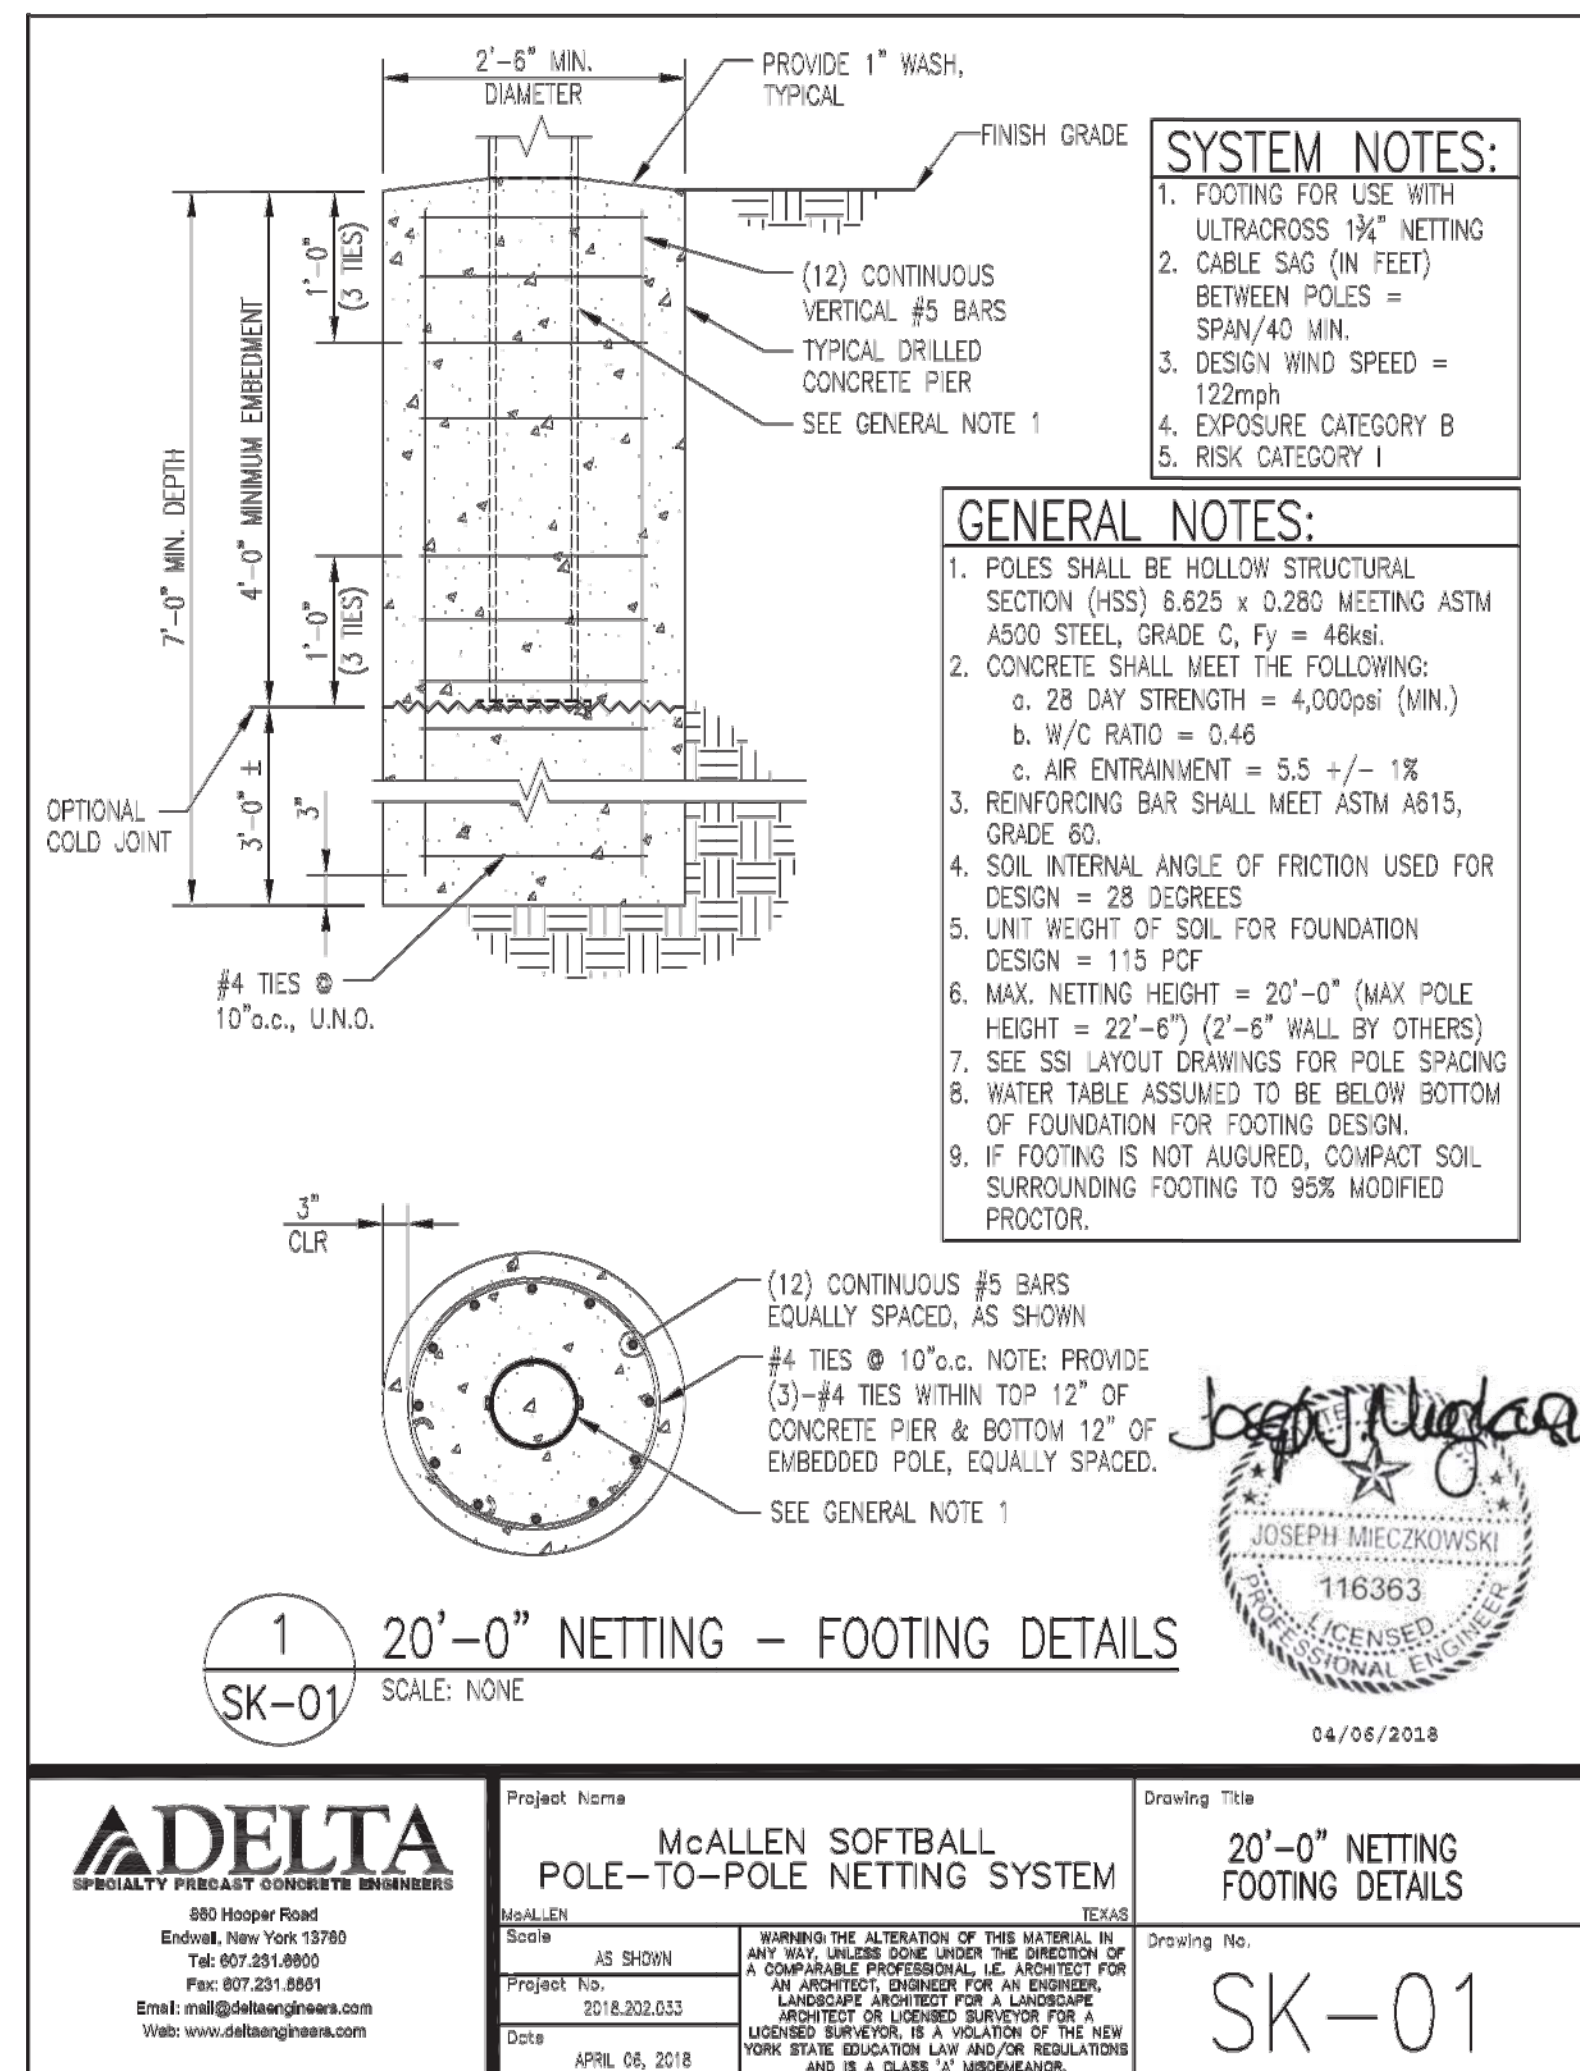

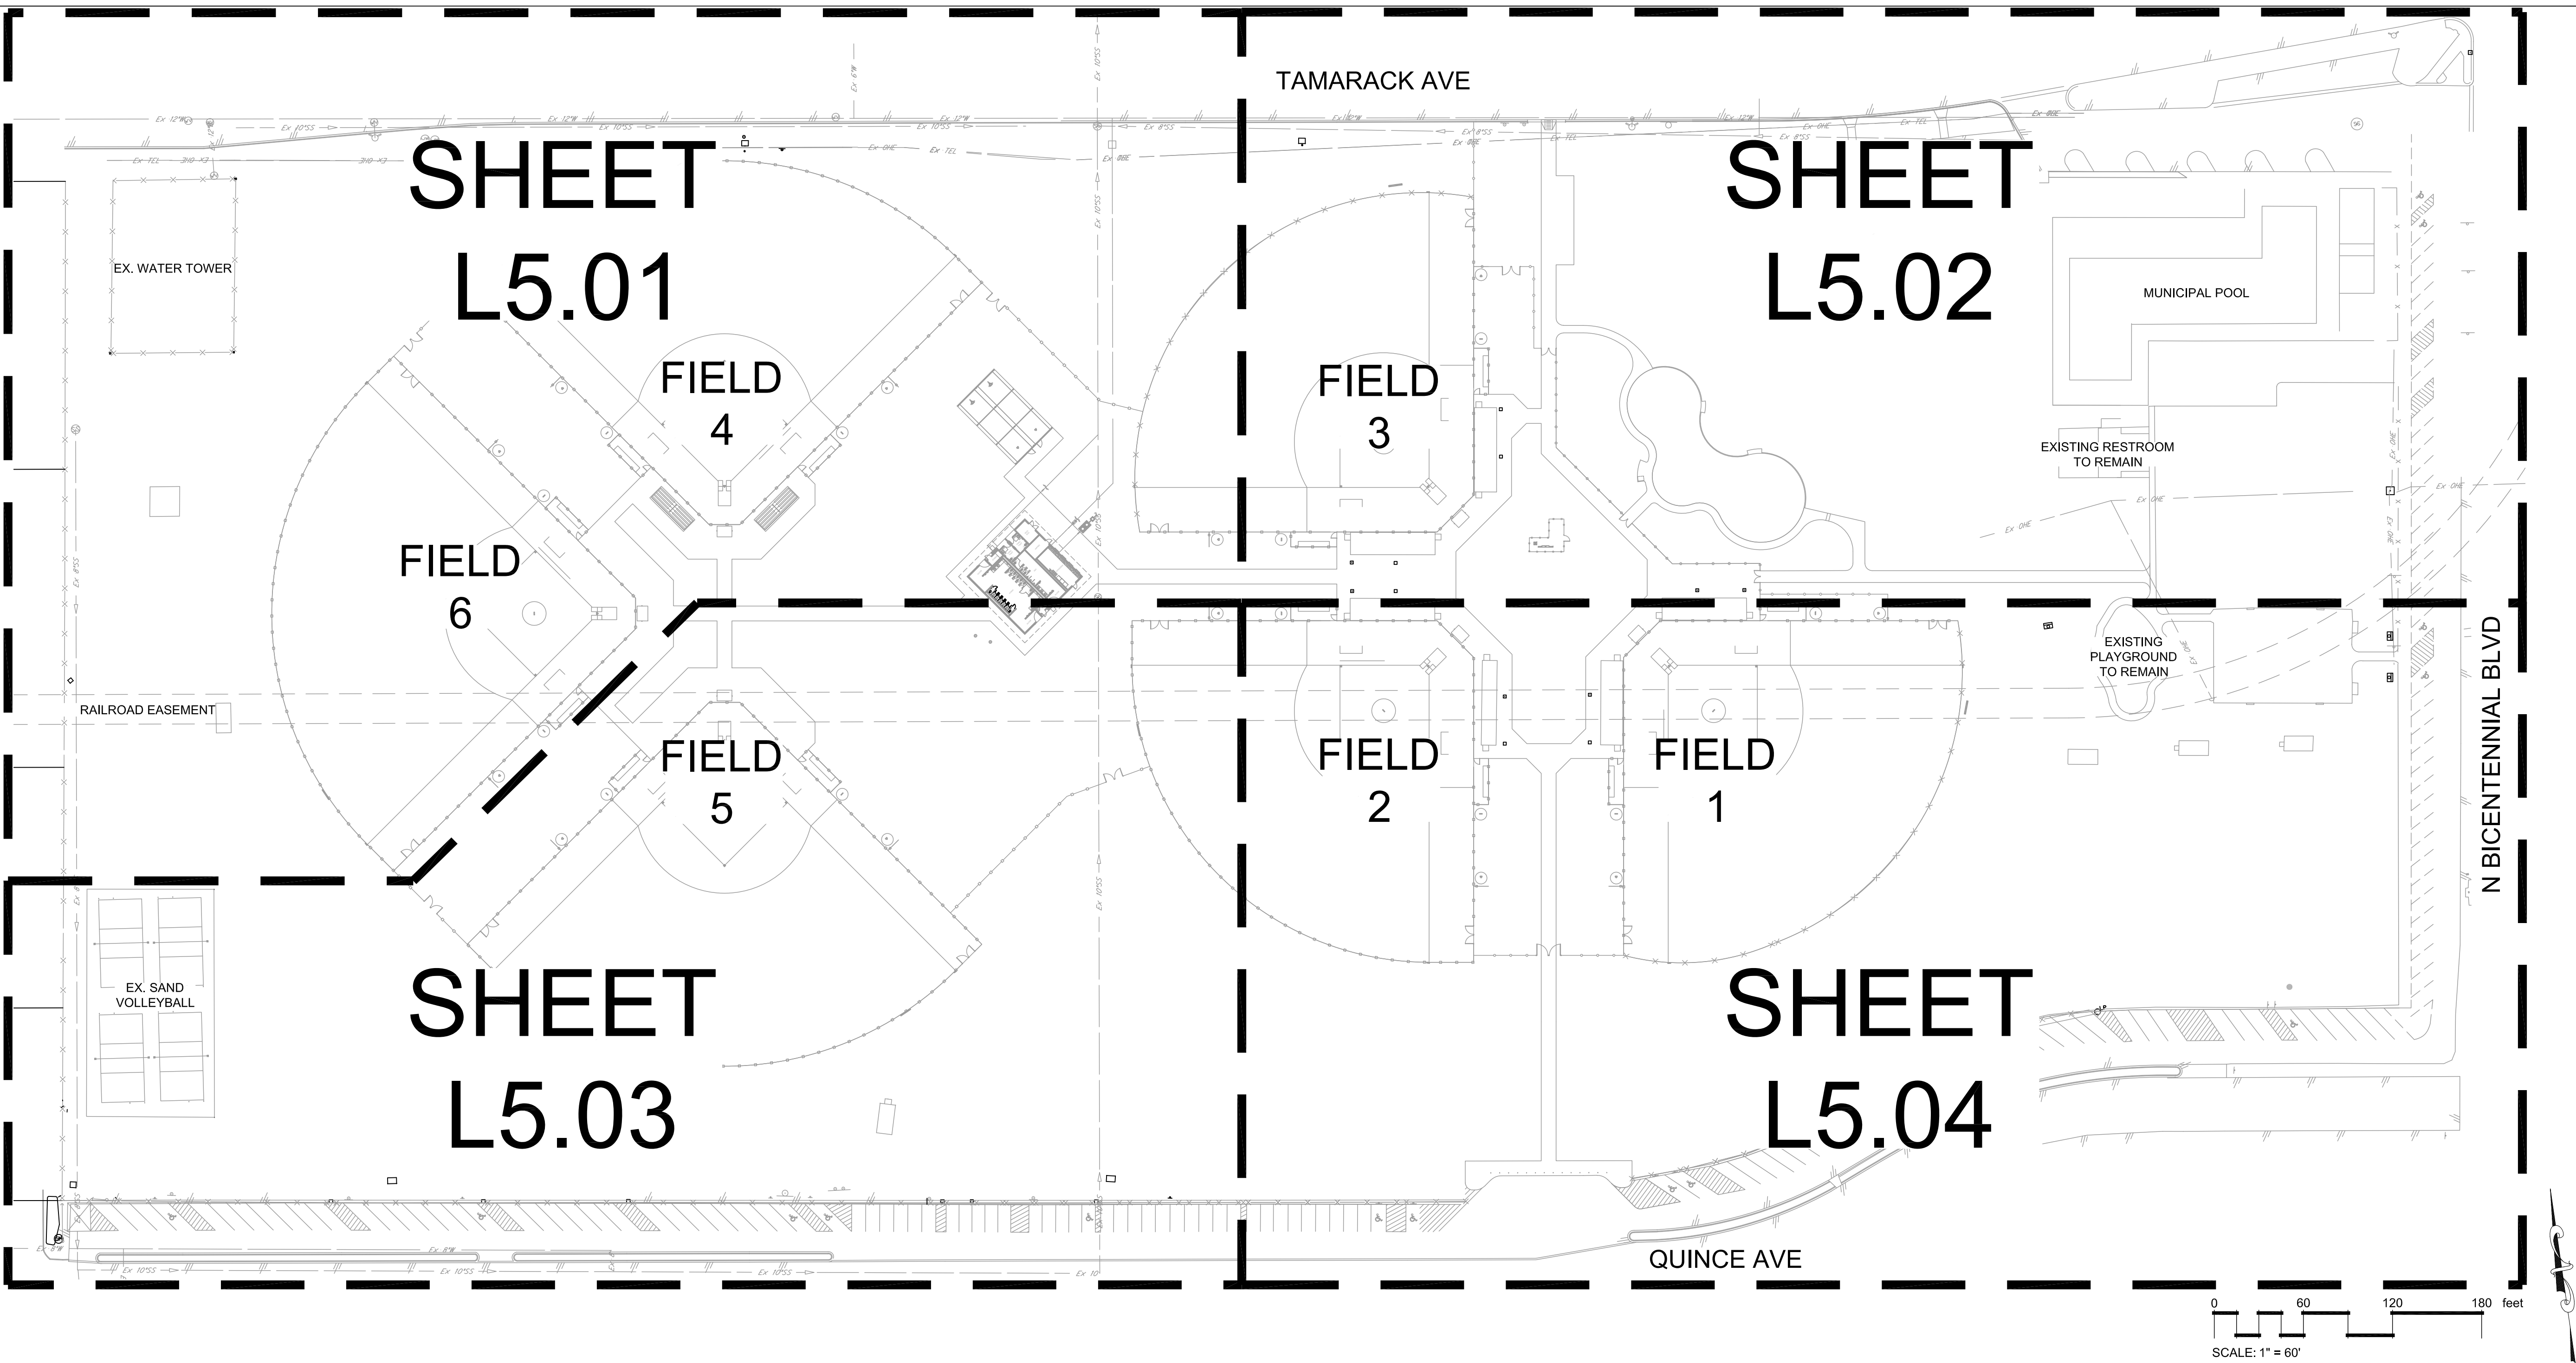

PLANTING NOTES

- EXISTING CONDITIONS: THE LANDSCAPE CONTRACTOR SHALL BE RESPONSIBLE FOR VISITING THE SITE PRIOR TO SUBMITTING BID PROPOSAL, TO BECOME FAMILIAR WITH ALL CONDITIONS AFFECTING THE PROPOSED WORK. THE LANDSCAPE CONTRACTOR SHALL IDENTIFY AND REVIEW ALL UNDERGROUND UTILITY LOCATIONS PRIOR TO COMMENCING WORK AND SHALL EXERCISE EXTREME CAUTION WHEN WORKING CLOSE TO UTILITIES, AND SHALL NOTIFY THE OWNER'S REPRESENTATIVE OF APPARENT CONFLICTS WITH CONSTRUCTION AND UTILITIES SO THAT ADJUSTMENTS CAN BE PLANNED PRIOR TO INSTALLATION. CONTACT THE LOCAL UNDERGROUND UTILITY SERVICES FOR UTILITY LOCATION AND IDENTIFICATION. THE LANDSCAPE CONTRACTOR BEARS FULL RESPONSIBILITY FOR THIS WORK AND DISRUPTION OR DAMAGE TO UTILITIES SHALL BE REPAIRED IMMEDIATELY AT NO EXPENSE TO THE OWNER.
- ALL SITE FEATURES INCLUDING LIGHTS AND OTHER UTILITIES, ABOVE AND BELOW GRADE, TO BE VERIFIED ON SITE PRIOR TO PLANTING AND IRRIGATION INSTALLATION. NOTIFY OWNER'S REPRESENTATIVE TO MAKE ADJUSTMENTS PRIOR TO INSTALLATION.
- LAYOUT AND GRADING: THE LANDSCAPE CONTRACTOR SHALL BE RESPONSIBLE FOR ACCURATELY LAYING OUT THE TURF AREAS BY SCALING THE DRAWINGS. LAYOUT SHALL BE PAINTED OR STAKED ON THE GROUND FOR REVIEW AND APPROVAL OF OWNER'S REPRESENTATIVE PRIOR TO EXCAVATION. FOLLOWING APPROVAL OF LAYOUT, CLOSELY COORDINATE THE INSTALLATION OF THE IRRIGATION SYSTEM TO CONFORM TO THE APPROVED LAYOUT.

THE LANDSCAPE CONTRACTOR SHALL BE RESPONSIBLE FOR FINE GRADING OF THE TURF AREAS. THE LANDSCAPE CONTRACTOR AND OWNER SHALL REVIEW THE EXTENT OF GRADING OF AREA PRIOR TO COMMENCING WORK. ENTIRE SITE SHALL BE GRADED TO FINISH GRADE PRIOR TO SCHEDULING PLANTING INSTALLATION.

TURF AREAS SHALL BE RAKED SMOOTH, REMOVING AND DISPOSING OF STONES OVER 1" DIAMETER AND STICKS, ROOTS, AND OTHER EXTRANEIOUS MATTER AND LEGALLY DISPOSING OF THEM OFF OWNER'S PROPERTY. ALL AREAS SHALL BE FINE GRADED TO ACHIEVE POSITIVE DRAINAGE WITHOUT PUDDLES OR STANDING WATER AND FEATHER INTO NATURAL GRADE. ROLL AND RAKE, REMOVE RIDGES, AND FILL DEPRESSIONS TO MEET FINISH GRADES TO WITHIN PLUS OR MINUS 1/2 INCH OF FINISH ELEVATION. LIMIT FINISH GRADING TO AREAS THAT CAN BE PLANTED IN THE IMMEDIATE FUTURE.

LANDSCAPE CONTRACTOR SHALL BE RESPONSIBLE FOR EROSION CONTROL OF SLOPED AREAS. CONTRACTOR TO RESTORE TURF OR PLANTING AREAS IF ERODED OR OTHERWISE DISTURBED AFTER FINISH GRADING.

- TOPSOIL: THE LANDSCAPE CONTRACTOR SHALL BE RESPONSIBLE FOR IMPORTING AND PLACING TOPSOIL TO PREPARE THE TURF AREAS FOR THE SPECIFIED GRASS SOD AND/OR SEEDING. TURF AREAS SHALL RECEIVE A 2" LAYER OF AMENDED TOPSOIL PLACED ON TOP OF THE SUBGRADE MATERIAL. THE LANDSCAPE ARCHITECT, LANDSCAPE CONTRACTOR AND OWNER SHALL REVIEW THE EXTENT OF THIS WORK PRIOR TO COMMENCEMENT OF INSTALLATION. DO NOT SPREAD TOPSOIL IF SOIL OR SUBGRADE IS FROZEN, MUDDY OR EXCESSIVELY WET. TOPSOIL SHALL BE A MIN. OF 2% ORGANIC WITH PH BETWEEN 5.3 - 6.0.

FINISH GRADES OF LAWNS SHALL BE 1/4" BELOW ADJACENT PAVING OR HEADER.

- WEED CONTROL TO BE COMPLETED PRIOR TO PREPARING PLANTING AREAS BY APPLICATION OF A 50/50 BLEND OF POST-EMERGENT HUMIC ACID COMPLEX AND ROUNDUP HERBICIDE. APPLY 10 LB OF MICROLIFE HUMATES PLUS PER 1,000 SQ FT TO RESTORE SOIL HEALTH.

GRASS SEEDING: LIMITS OF GRASS SEEDING AREAS SHOWN ON THE DRAWINGS ARE SCHEMATIC AND NOT TO BE CONSTRUED TO BE PRECISE. THE LANDSCAPE ARCHITECT, LANDSCAPE CONTRACTOR AND OWNER SHALL REVIEW THE LIMITS OF SEEDING PRIOR TO COMMENCING INSTALLATION. IN BID PROPOSAL, FURNISH UNIT PRICES FOR GRASS SEEDING PER SQUARE YARD. THE CONTRACT AMOUNT WILL BE ADJUSTED BASED ON ACTUAL, APPROVED QUANTITIES INSTALLED.

THE LANDSCAPE ARCHITECT, LANDSCAPE CONTRACTOR AND OWNER SHALL REVIEW THE LIMITS OF SEEDING PRIOR TO COMMENCING INSTALLATION. LANDSCAPE CONTRACTOR SHALL PROVIDE A UNIFORM STAND OF GRASS BY WATERING AND MAINTAINING SEEDED AREAS UNTIL DATE OF SUBSTANTIAL COMPLETION. RESEED AREAS, WITH SPECIFIED MATERIALS, WHICH FAIL TO PROVIDE A UNIFORM STAND UNTIL OWNER'S REPRESENTATIVE REVIEWS ALL AFFECTED AREAS. REPLACE IMMEDIATELY UNLESS REQUIRED TO SEED IN THE SUCCEEDING PLANTING SEASON. RESTRICT TRAFFIC FROM SEEDED AREAS UNTIL ESTABLISHED. ERECT SIGNS, FLAGGING AND BARRIERS AS REQUIRED. SOW GRASS SEED WHEN SOIL TEMPERATURE IS ABOVE 65 DEGREES F (IN EARLY SPRING THROUGH LATE SUMMER).

- PROVIDE UNIT PRICES FOR ALL PLANT MATERIALS. UNIT PRICE IS TO INCLUDE COST OF MATERIAL, LABOR AND TAXES AS REQUIRED TO INSTALL THE PLANTS. UNIT PRICES SHALL BE USED IN THE CASE THAT FEWER OR MORE PLANTS ARE TO BE PLANTED.
- REGULAR CLEAN UP AT THE JOB SITE AND ACCESS ROUTES SHALL TAKE PLACE ON A DAILY BASIS UNLESS OTHERWISE APPROVED OR REQUIRED BY THE OWNER'S REPRESENTATIVE. DEMOLITION AND INSTALLATION SCHEDULING IS TO BE COORDINATED WITH OWNER'S REPRESENTATIVE. DAILY AND ANY BARRIERS/PROTECTIVE DEVICES ARE TO BE INSTALLED AS NEEDED TO PROTECT THE SAFETY OF THE PUBLIC. SPECIAL CARE SHALL BE TAKEN TO KEEP ALL VEHICULAR ROUTES OPEN AND PEDESTRIAN ACCESS UNOBSTRUCTED FOR SAFE PASSAGE DURING DEMOLITION AND CONSTRUCTION.
- CONTRACTOR TO PROVIDE A NINETY-DAY MAINTENANCE AGREEMENT FOR ALL WORK PERFORMED.
- WARRANTY: CONTRACTOR TO PROVIDE IN WRITING TO OWNER A GUARANTEE FOR ALL PLANT MATERIAL PROVIDED. PROVIDE A ONE-YEAR REPLACEMENT WARRANTY FOR ALL PLANT MATERIALS. WARRANTY SHALL COVER PLANTS WHICH HAVE DIED OR PARTIALLY DIED (THEREBY RUINING THEIR NATURAL SHAPE), BUT SHALL NOT INCLUDE DAMAGE BY VANDALISM, BROWSING, HAIL, ABNORMAL FREEZES, DROUGHT OR NEGLIGENCE BY THE OWNER. THE WARRANTY IS INTENDED TO COVER CONTRACTOR NEGLIGENCE, INFESTATIONS, DISEASE AND DAMAGE OR SHOCK TO PLANTS. PLANTS REPLACED UNDER WARRANTY WILL BE WARRANTED FOR ONE YEAR FOLLOWING REPLACEMENT.

PLANT SCHEDULE OVERALL

SOD/SEED	QTY	BOTANICAL NAME / COMMON NAME
HYDRO	544,592 sf	Cynodon dactylon / Bermuda Grass
SEED	93,077 sf	Cynodon dactylon / Common Bermuda Grass

QUANTITIES SHOWN PER SHEET.


CITY OF McALLEN
SOFTBALL FIELD FACILITIES
MUNICIPAL PARK
McALLEN, TEXAS

5000 WEST MILITARY HWY, SUITE 100
FARMERSVILLE, TX 77834
TEL (956) 684-0286
FAX (956) 684-0282
TDD: (956) 684-0282

Revision No.	Date	Description
1	07-26-18	ADDENDUM NO. 1

100%
CONSTRUCTION
DOCUMENTS

Project No.:	33348.001
Issued:	07/11/2018
Drawn By:	CE
Checked By:	TM
Scale:	AS SHOWN
Sheet Title	OVERALL PLANTING PLAN & NOTES
L5.00	Sheet Number

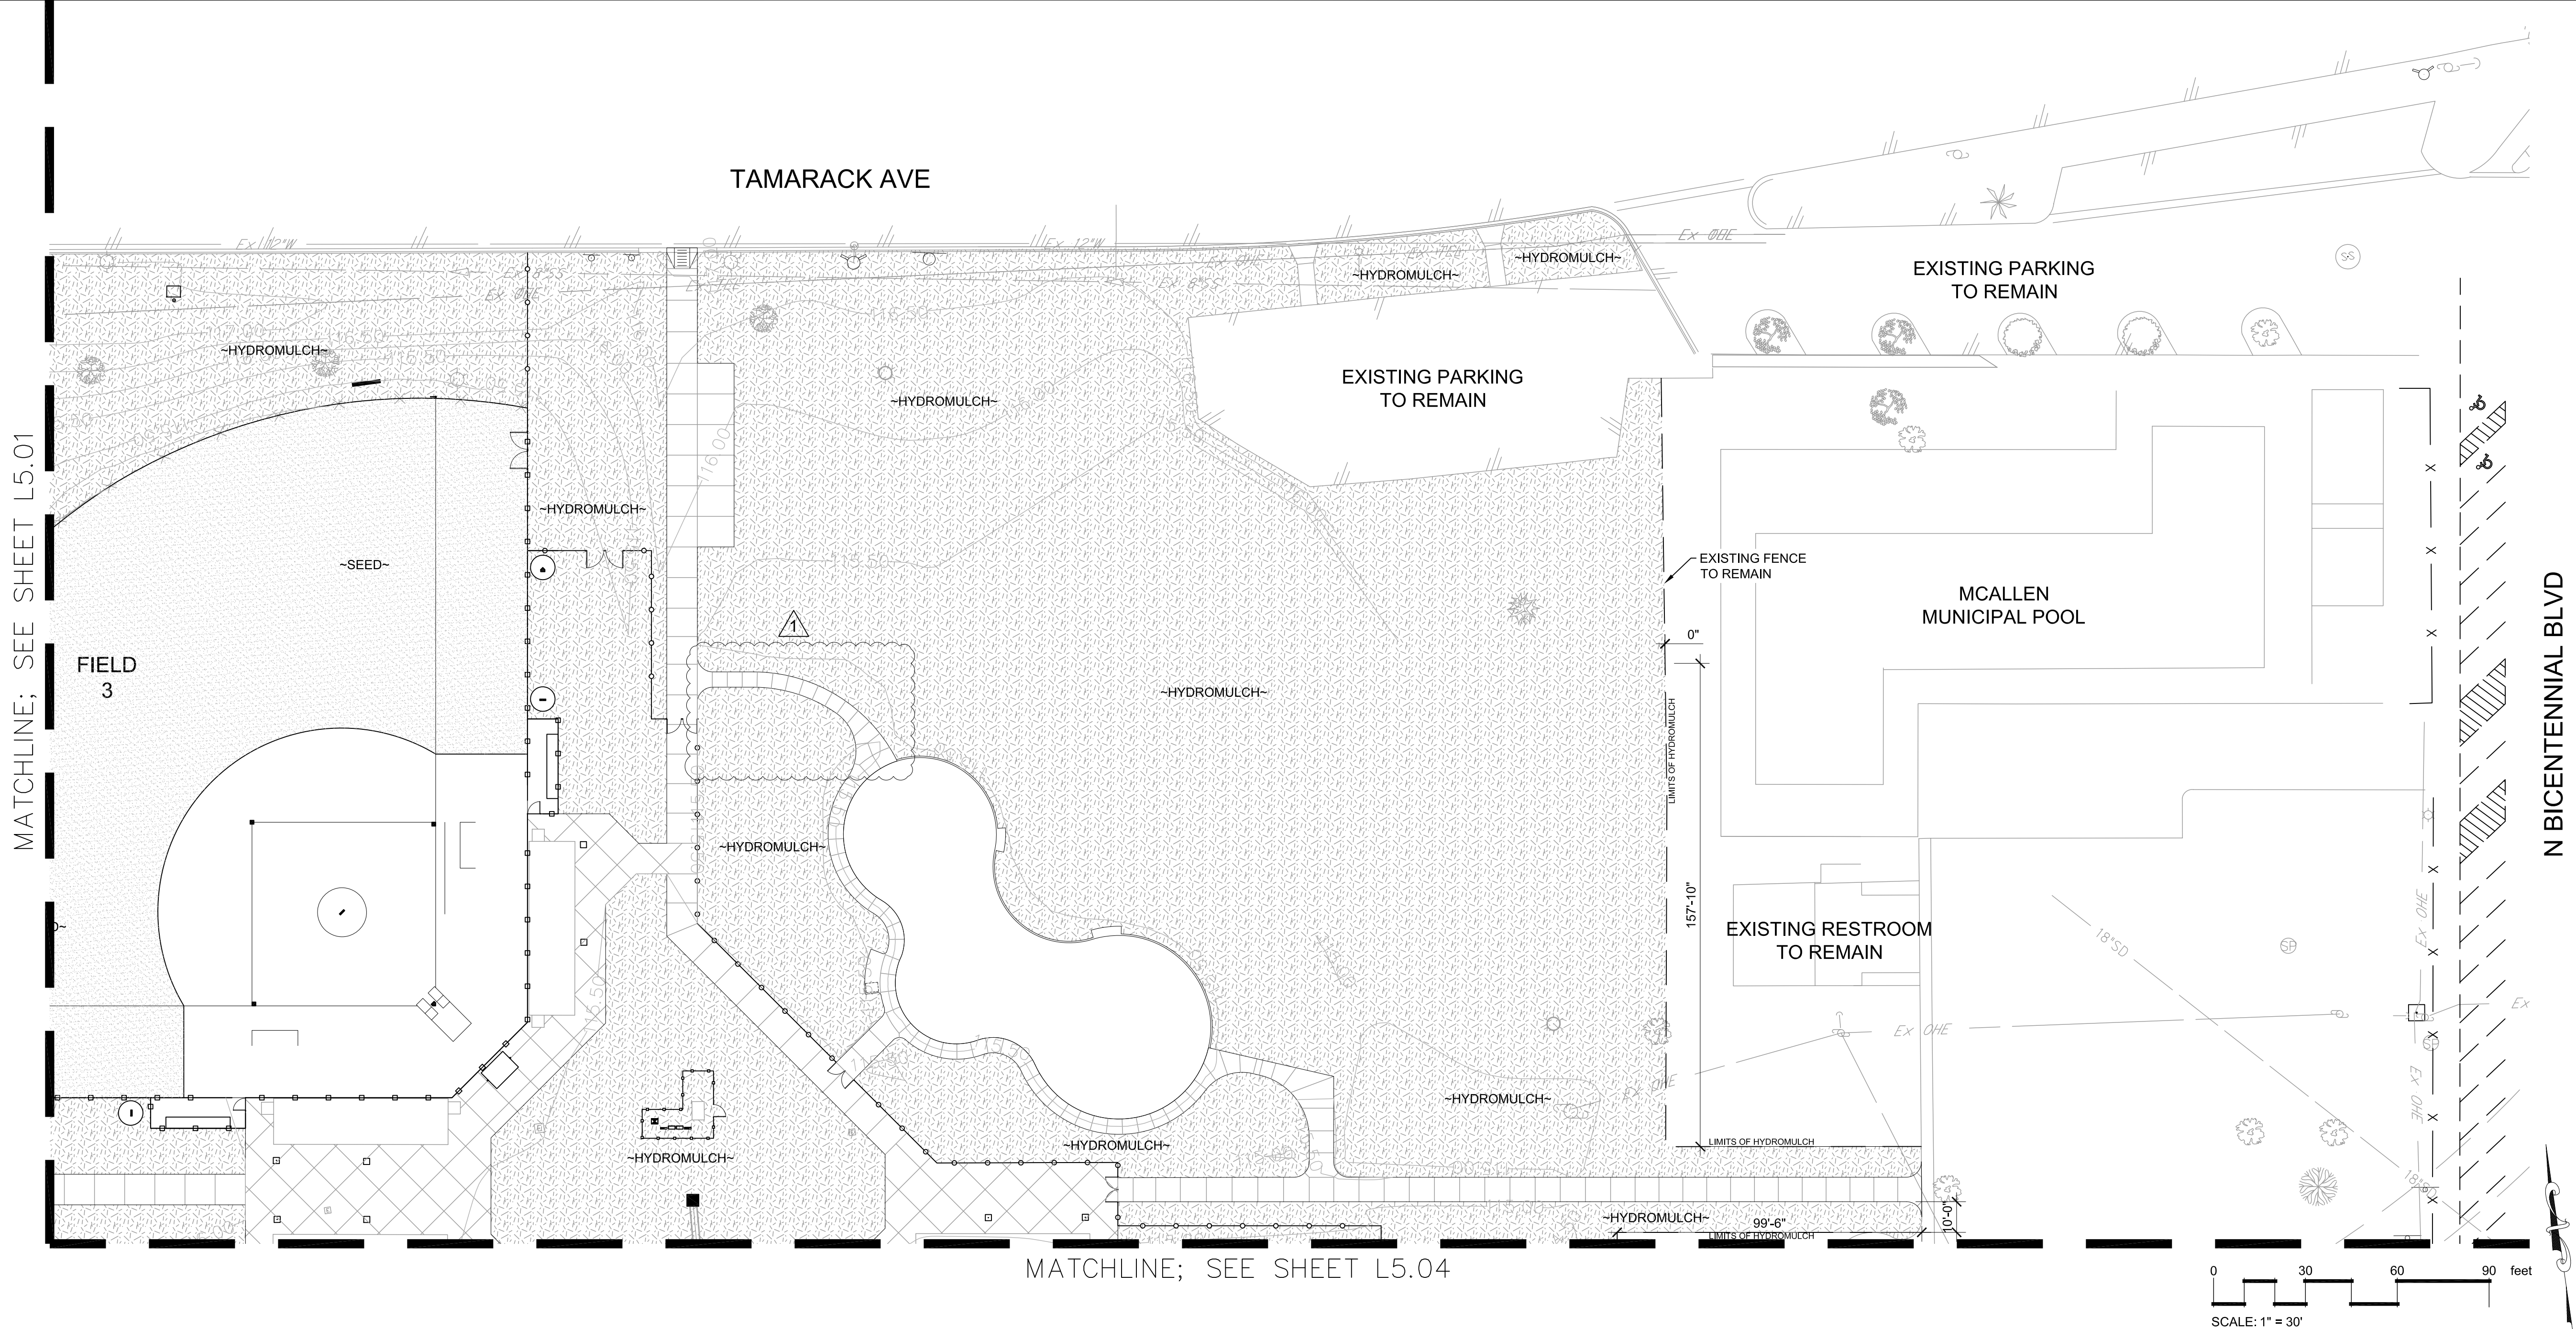

PLANT SCHEDULE L5.02

SOD/SEED	QTY	BOTANICAL NAME / COMMON NAME	CONT
HYDRO	1	Cynodon dactylon / Bermuda Grass	Hydro
SEED	20,861 sf	Cynodon dactylon / Common Bermuda Grass	Seed

QUANTITIES SHOWN PER SHEET.

CITY OF McALLEN
SOFTBALL FIELD FACILITIES
MUNICIPAL PARK
McALLEN, TEXAS





5000 WEST MILITARY HWY, SUITE 100
TEL (956) 684-0286
FAX (956) 684-0282
TDD: (956) 684-0282

Revision No.	Date	Description
1	07-26-18	ADDENDUM NO. 1



07/26/2018

100%
CONSTRUCTION
DOCUMENTS

Project No.:	33348.001
Issued:	07/11/2018
Drawn By:	CE
Checked By:	TM
Scale:	AS SHOWN
Sheet Title	PLANTING PLAN
L5.02	Sheet Number