


Sep 06, 2018 - 9:23am
 M:\2018\18022 HCA RGRH Inpatient Rehab\Dwg\Elec\E2.02_FLOOR PLANS - LIGHTING.dwg
 crothlauf

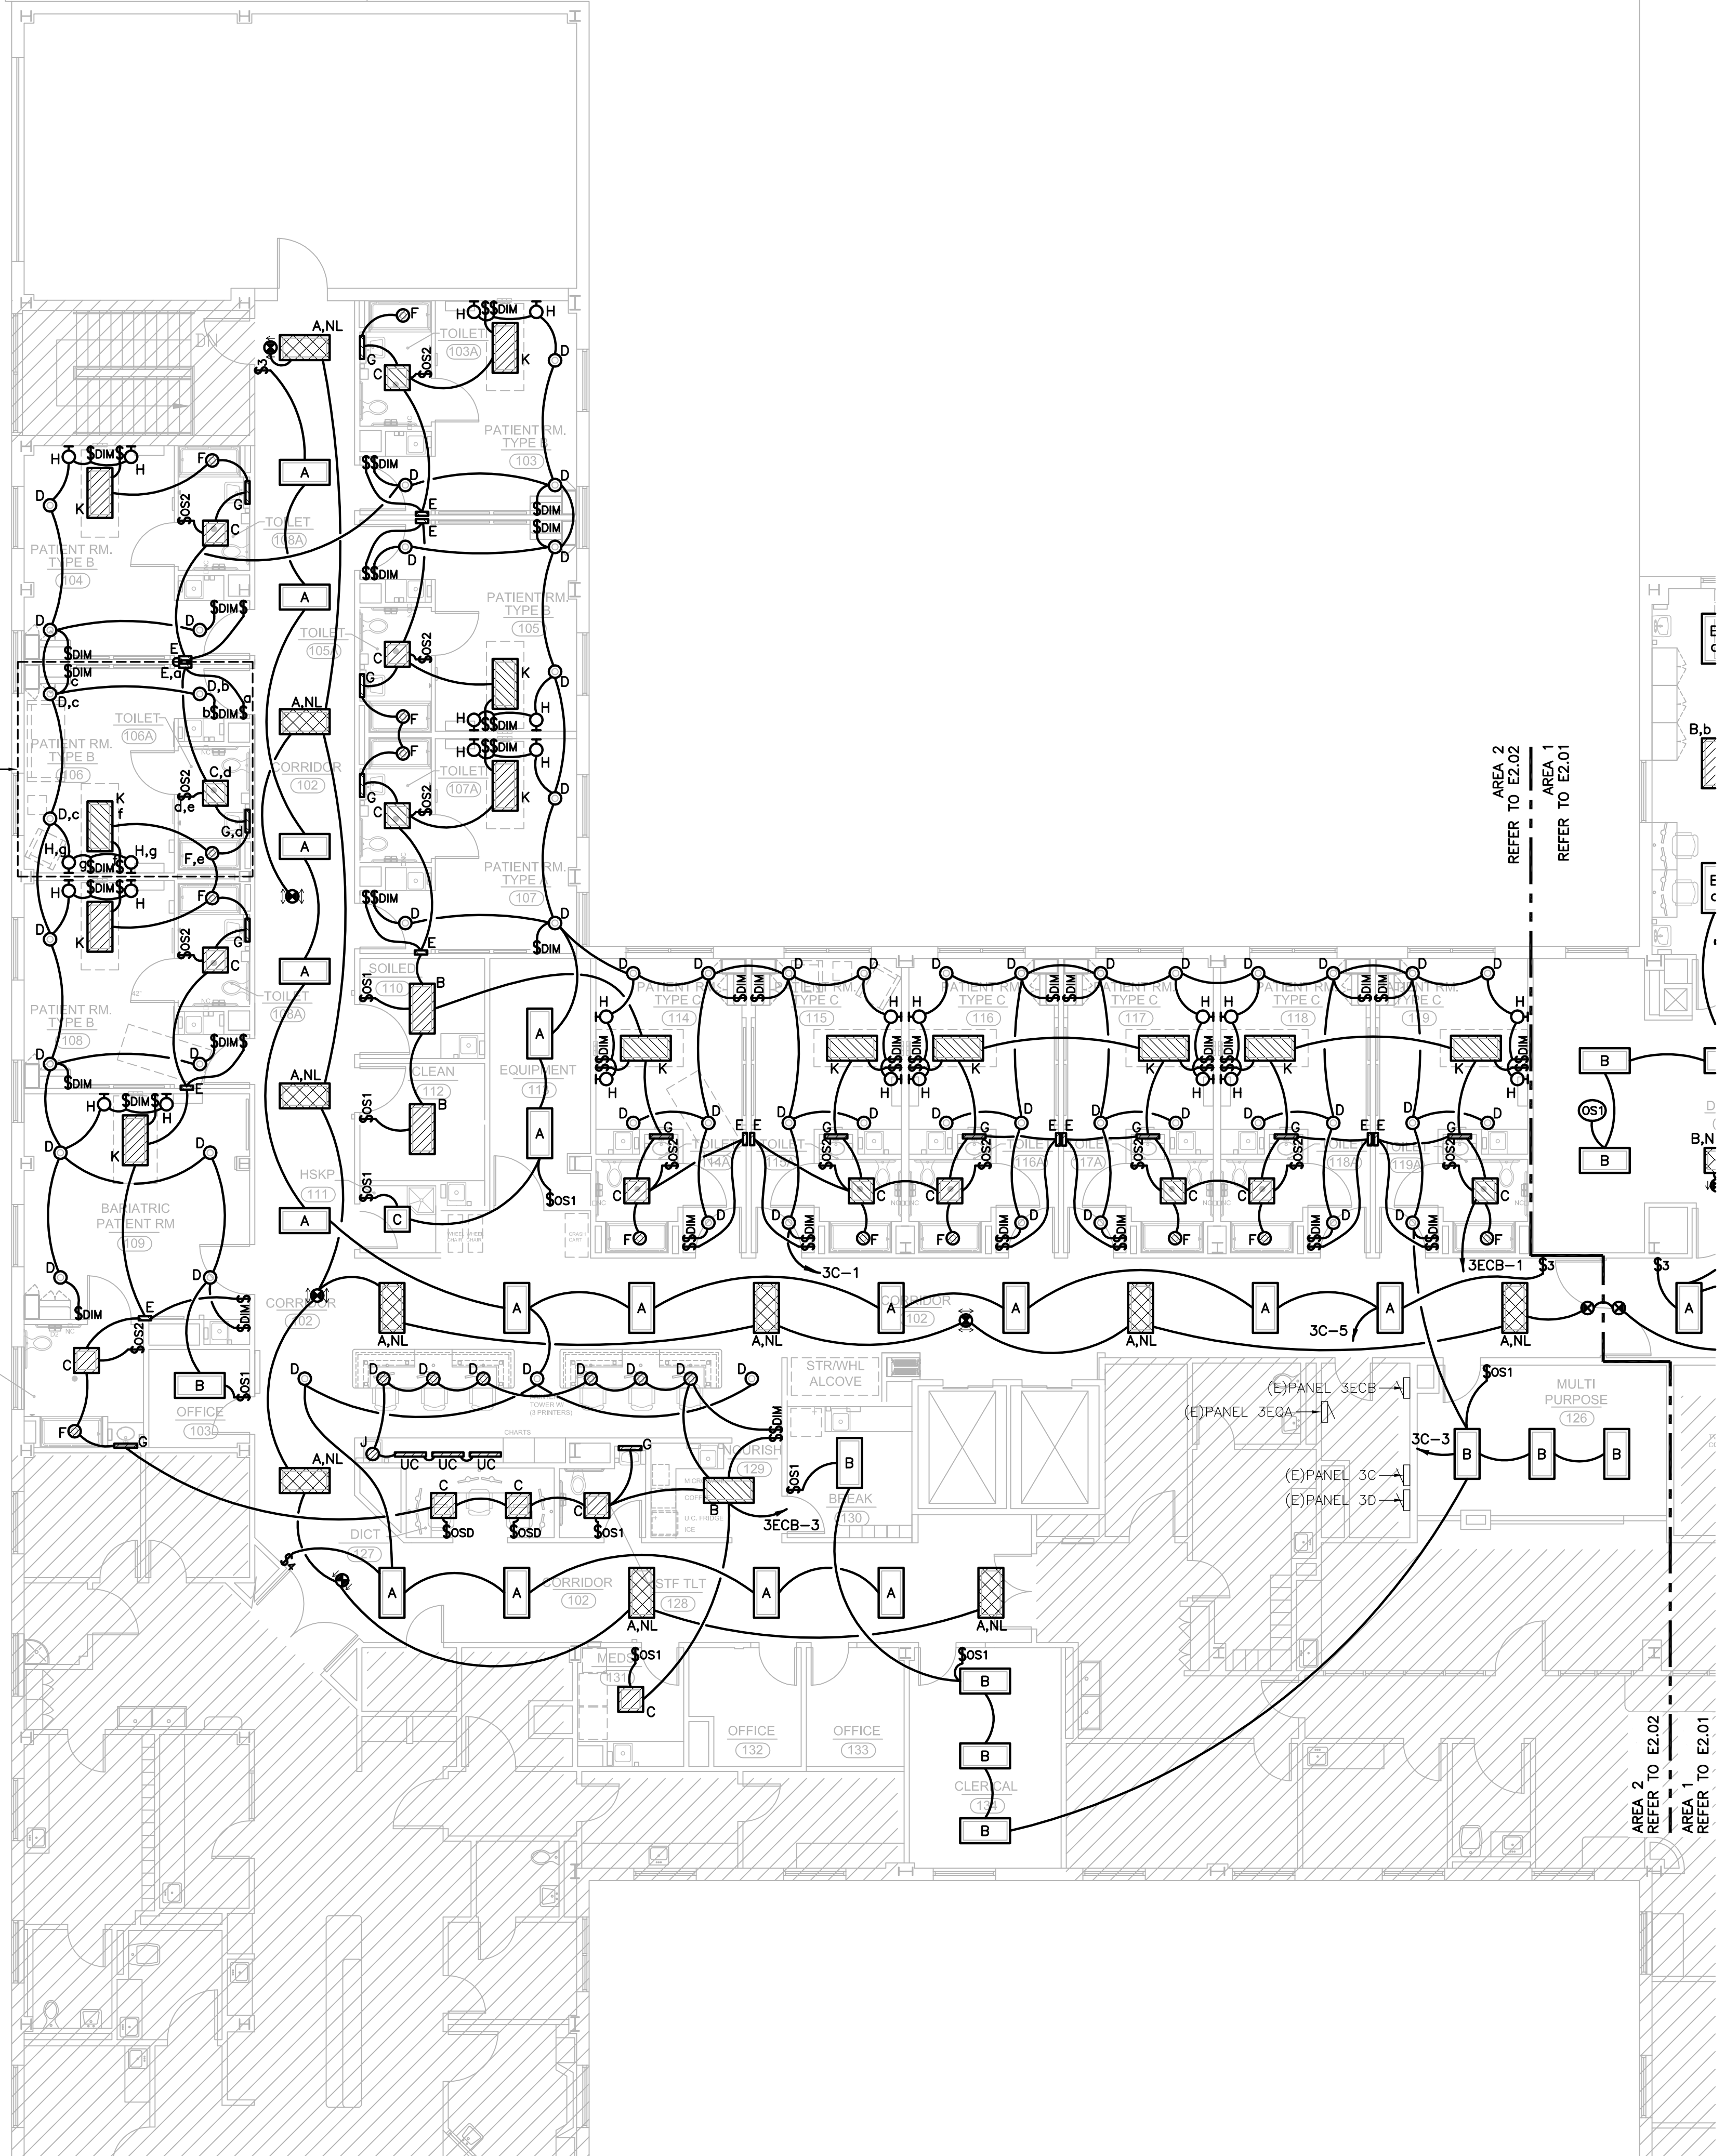

TYPICAL PATIENT ROOM:
 SWITCHING SCHEME
 APPLIES TO OTHER
 TYPICAL PATIENT ROOMS.
 NOTE: FIXTURE TYPE "K"
 AMBIENT FUNCTION IS
 CONTROLLED BY PILLOW
 SPEAKER, EXAM FUNCTION
 IS CONTROLLED BY WALL
 SWITCH "I".

RENOVATION LEGEND	
SYMBOL	DESCRIPTION
(Symbol)	EXISTING TO REMAIN "(E)"
(Symbol)	RELOCATED "(R)"
(Symbol)	NEW CONSTRUCTION

- GENERAL LIGHTING NOTES**
- REFER TO THE GENERAL NOTES ON THE INFORMATION SHEET FOR ADDITIONAL INFORMATION.
 - REFER TO ARCHITECTURAL DRAWINGS FOR EXACT LOCATION, MOUNTING HEIGHT, AND ROTATION OF ALL LIGHTING FIXTURES. REFER TO THE ARCHITECTURAL PLANS FOR CEILING TYPES, COORDINATE ALL FIXTURE TYPES AND APPROPRIATE MOUNTING HARDWARE PRIOR TO PURCHASING.
 - PROVIDE NEW OCCUPANCY SENSORS. THE OCCUPANCY SENSOR LOCATIONS AND QUANTITIES ARE DIAGRAMMATIC ONLY AND ARE SHOWN FOR GENERAL INTENT AND PRICING ONLY. EXACT SENSOR LOCATION AND PLACEMENT IS TO BE PER THE SELECTED MANUFACTURER LAYOUT. SENSORS ARE TO BE POSITIONED AND AIMED IN SUCH A WAY THAT SENSORS ONLY RESPOND TO MOTION IN THE ROOM CONTAINING THE SENSORS. INSTALL SENSORS A SAFE DISTANCE AWAY FROM HVAC SUPPLY AND RETURN GRILLES IN ORDER TO AVOID FALSE ACTIVATION; EXACT MOUNTING DISTANCES SHALL BE PER SENSOR MANUFACTURER. WALL-MOUNTED OR CEILING-MOUNTED SENSORS SHALL BE SUITABLE FOR THE ENVIRONMENT IN WHICH THEY ARE PLACED IN. OCCUPANCY SENSORS ARE TO BE SUPPLIED FROM THE SAME POWER SOURCE THE LIGHTING FIXTURES ARE CONNECTED TO. ALL SENSORS SHALL HAVE NORMALLY CLOSED CONTACTS AND ALLOW CURRENT TO POWER THE LIGHTING FIXTURES IN THE EVENT OF A SENSOR FAILURE. PROVIDE ALL SENSOR POWER PACKS, HARDWARE, AND CIRCUITS AS NEEDED.
 - ALL NEW SWITCHES CONTROLLING EMERGENCY FIXTURES SHALL BE RED AND HAVE A RED COVER PLATE.
 - ALL EXIT LIGHTS ARE FIXTURE TYPE "X".

HEITKAMP SWIFT ARCHITECTS
 Architecture • Interiors • Planning
 1165 BRITTMORE RD.
 HOUSTON, TEXAS 77043
 (T) 713.626.4300
 (F) 713.626.4301

in association with:
GF Garner-Fritsche ENGINEERING, INC.
 8554 Katy Freeway, Suite 101, Houston, TX 77024
 713.432.1422 - Fax 713.432.1253
 www.garnerfritsche.com
 Texas Reg. No. F-5712
 GFE Project No. 18022

{b} bennett design group
 1165 Brittmore Rd.
 Houston, Texas 77043
 p. 713.850.8833 f. 713.850.0383

Rio Grande REGIONAL HOSPITAL
 An HCA Affiliated Hospital


3rd Floor INPATIENT REHAB UNIT

FOR INTERIM REVIEW ONLY
 THIS DOCUMENT IS RELEASED FOR THE PURPOSE OF INTERIM REVIEW ONLY. UNDER THE AUTHORITY OF:
 Name: GREG W. MERCIER
 P.E. No. 114431
 DATE: 09/06/2018
 AND IS NOT INTENDED TO BE USED FOR BIDDING OR CONSTRUCTION PURPOSES.

REVISIONS

NO.	ISSUE	DATE

SHEET
E2.02
 ISSUED FOR PRICING ONLY

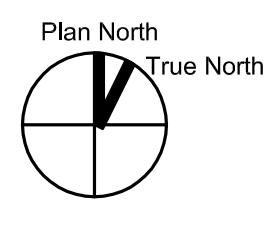

PARTIAL FLOOR PLAN - LIGHTING - AREA 2

1/8" = 1'-0" 1